




1 BASEMENT WASHROOMS B05 & B06
 A2/A16 SCALE 1:50

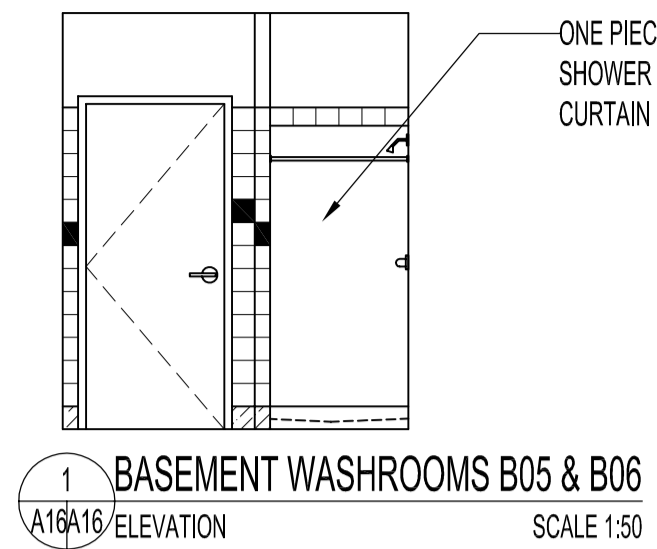


1 BASEMENT WASHROOMS B05 & B06
 A16/A16 ELEVATION SCALE 1:50

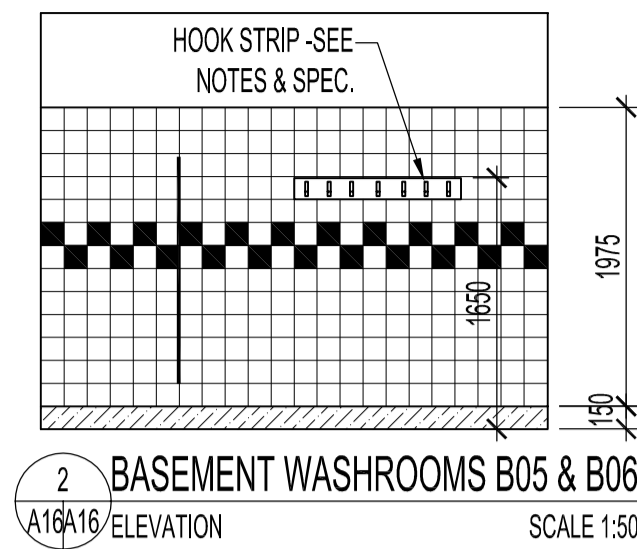


2 BASEMENT WASHROOMS B05 & B06
 A16/A16 ELEVATION SCALE 1:50

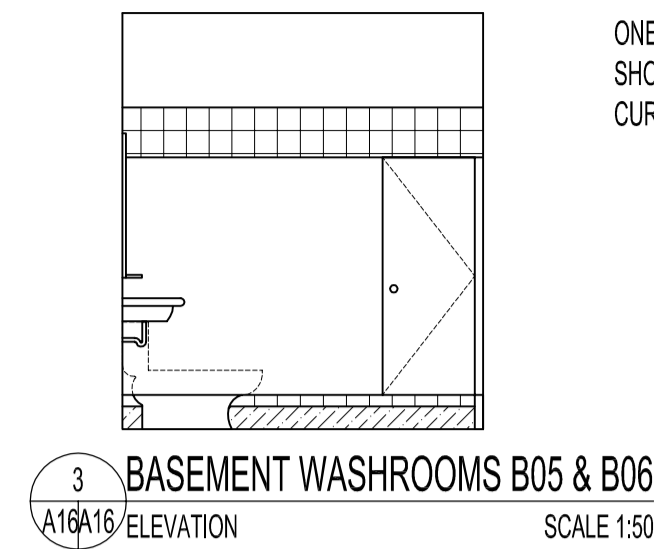


3 BASEMENT WASHROOMS B05 & B06
 A16/A16 ELEVATION SCALE 1:50

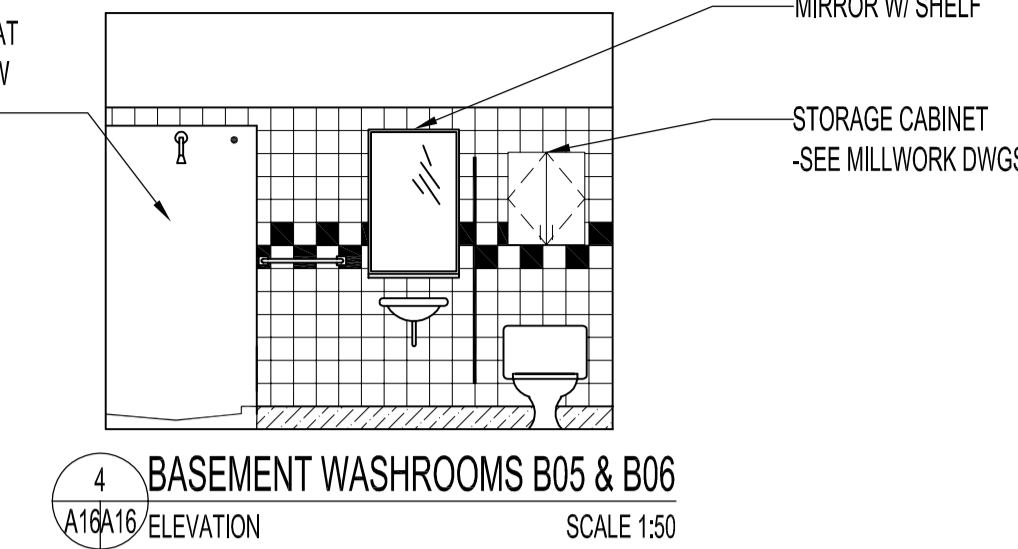


4 BASEMENT WASHROOMS B05 & B06
 A16/A16 ELEVATION SCALE 1:50

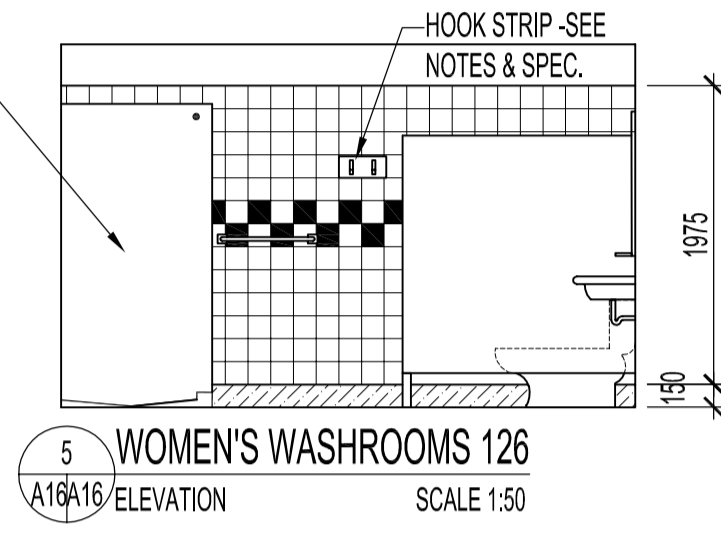


5 WOMEN'S WASHROOMS 126
 A16/A16 ELEVATION SCALE 1:50

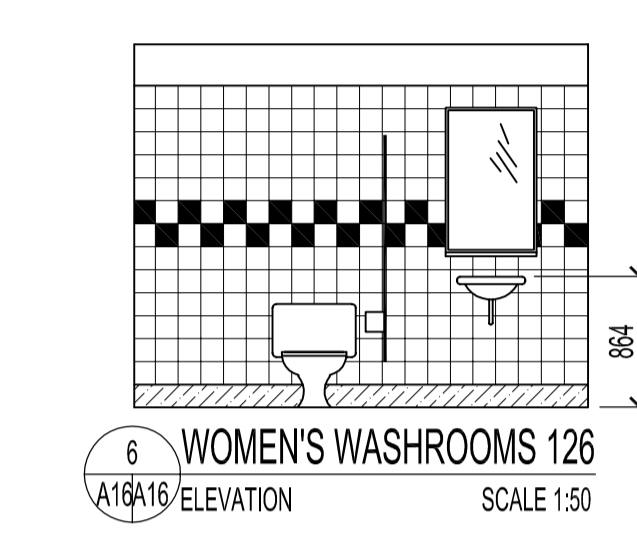


6 WOMEN'S WASHROOMS 126
 A16/A16 ELEVATION SCALE 1:50

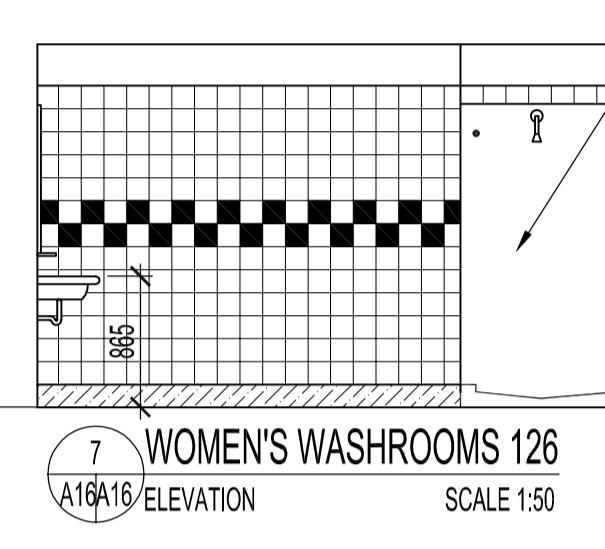


7 WOMEN'S WASHROOMS 126
 A16/A16 ELEVATION SCALE 1:50

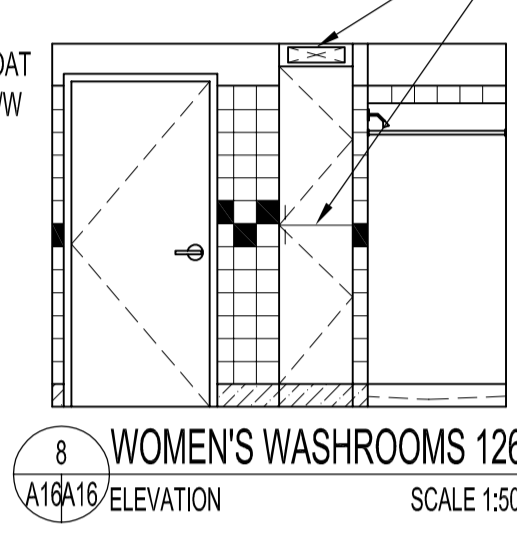


8 WOMEN'S WASHROOMS 126
 A16/A16 ELEVATION SCALE 1:50

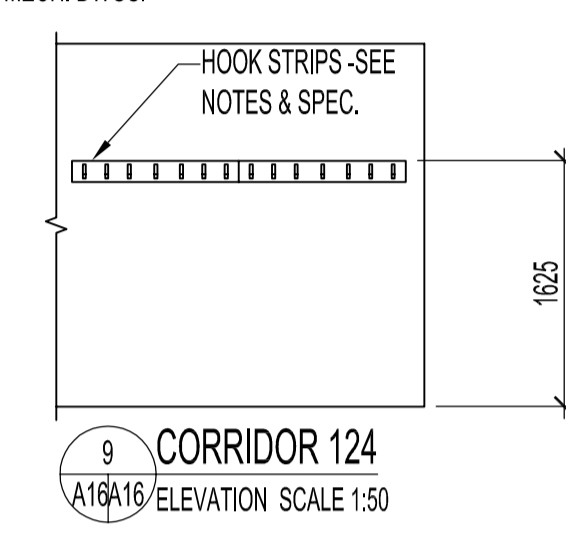


9 CORRIDOR 124
 A16/A16 ELEVATION SCALE 1:50

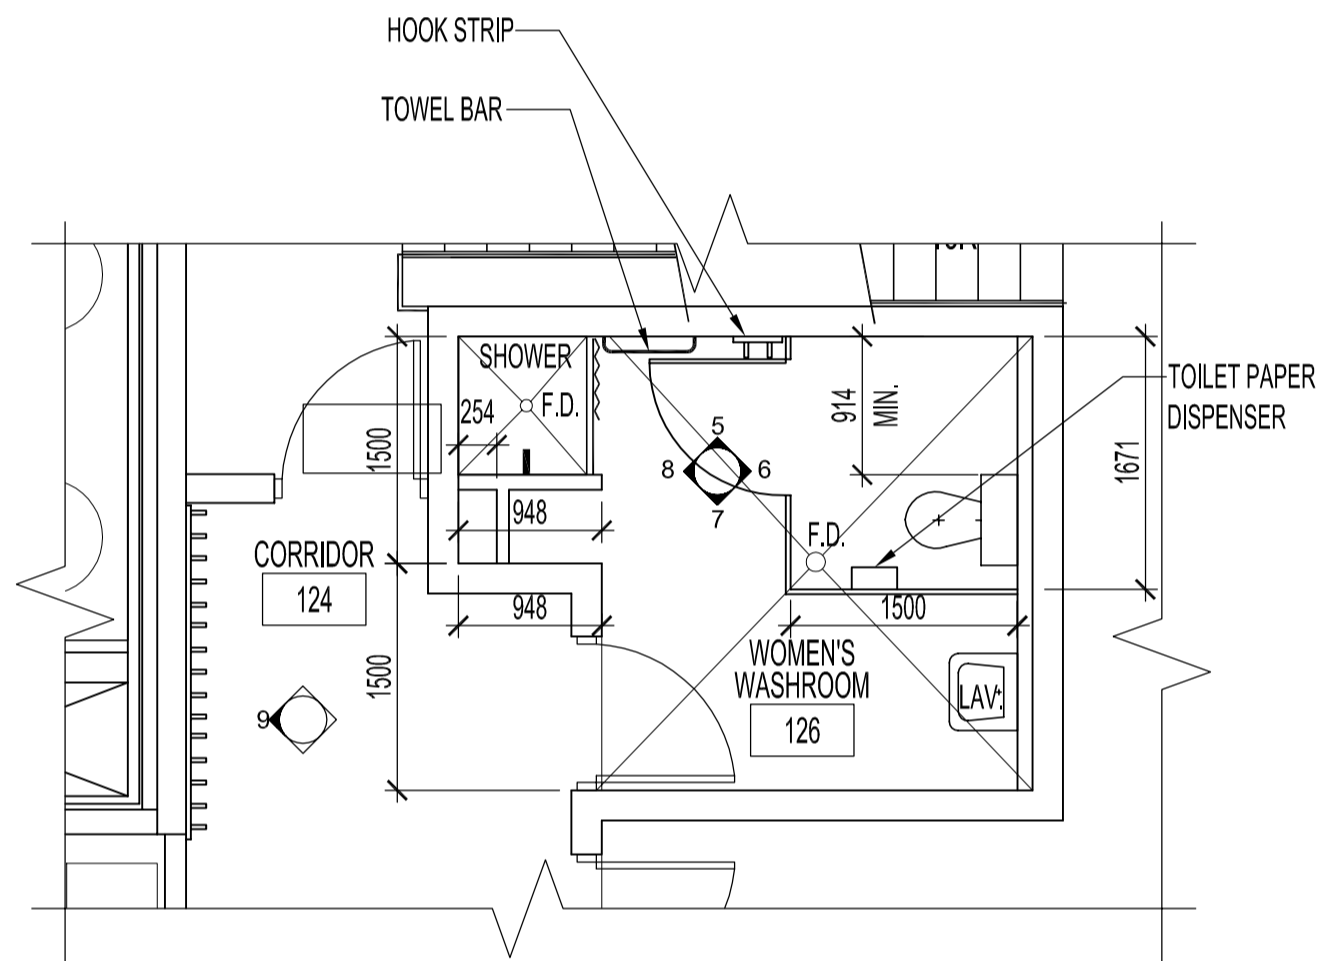


1 CORRIDOR 124 & MAIN FLOOR WOMEN'S WASHROOM 126
 A3/A16 SCALE 1:50

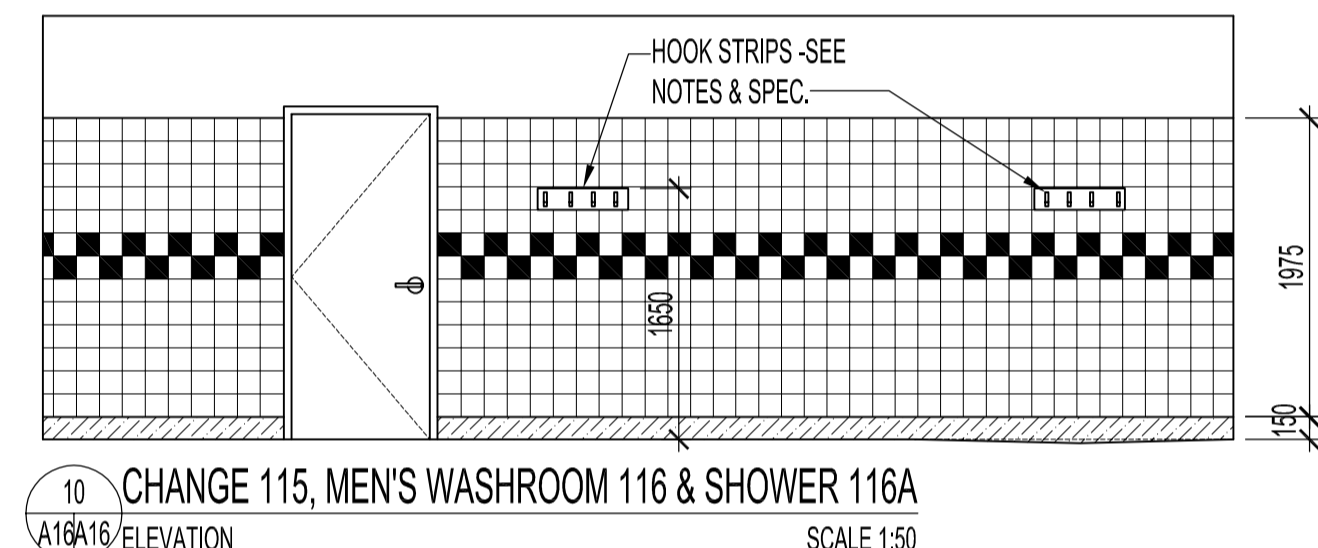


10 CHANGE 115, MEN'S WASHROOM 116 & SHOWER 116A
 A16/A16 ELEVATION SCALE 1:50

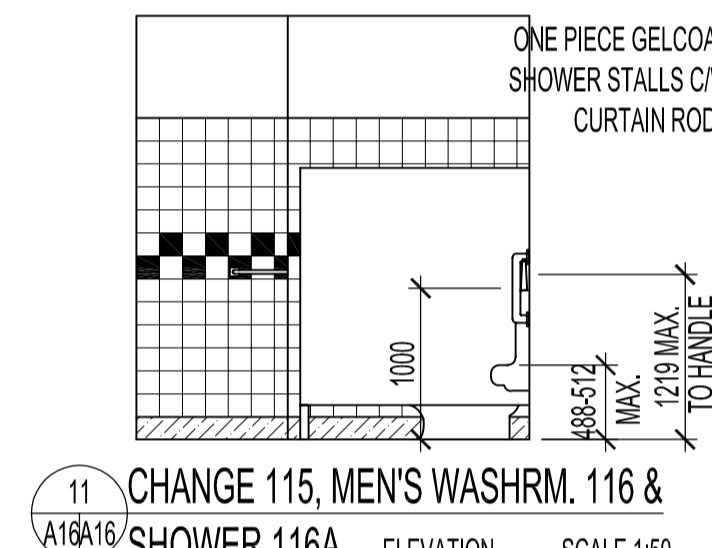


11 CHANGE 115, MEN'S WASHRM. 116 & SHOWER 116A
 A16/A16 ELEVATION SCALE 1:50

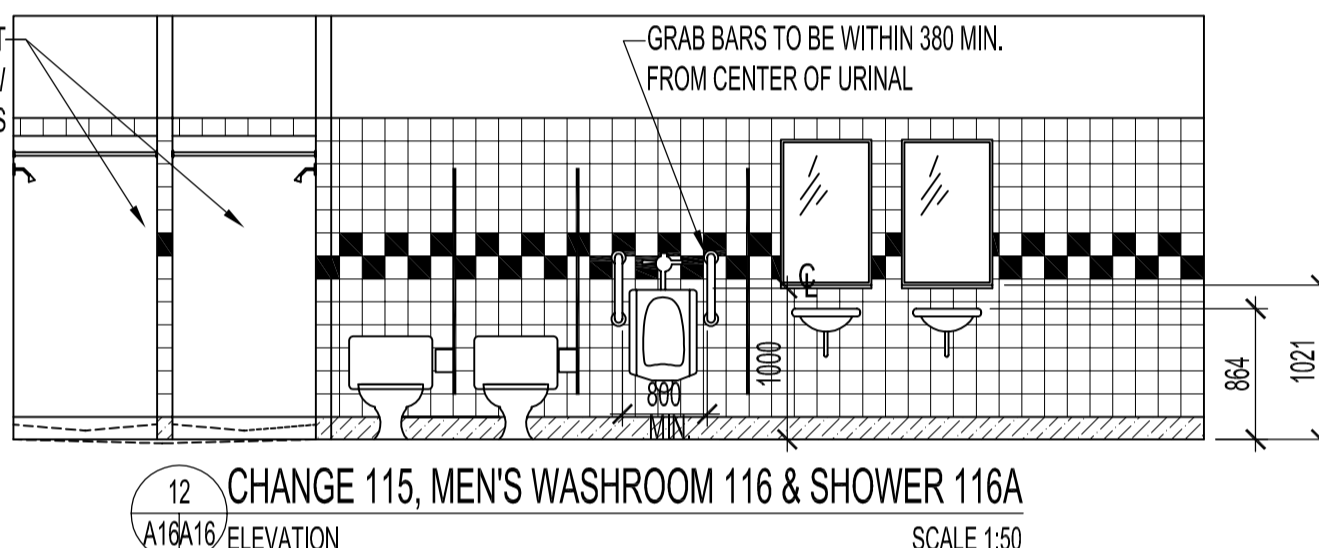


12 CHANGE 115, MEN'S WASHROOM 116 & SHOWER 116A
 A16/A16 ELEVATION SCALE 1:50

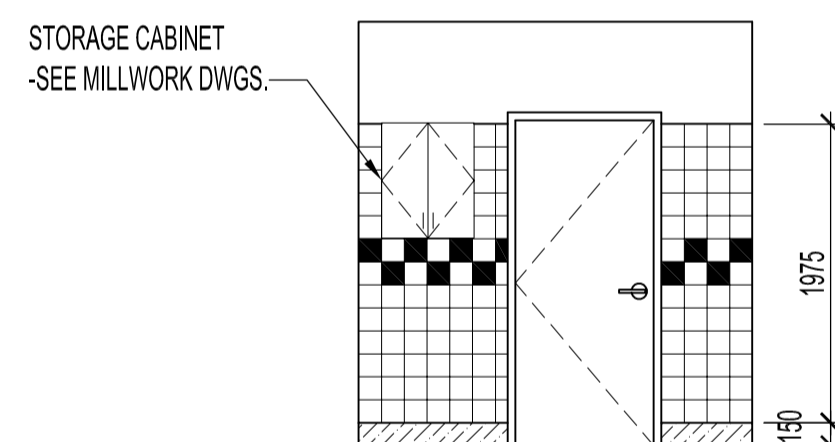


13 MEN'S WASHROOM 116
 A16/A16 ELEVATION SCALE 1:50

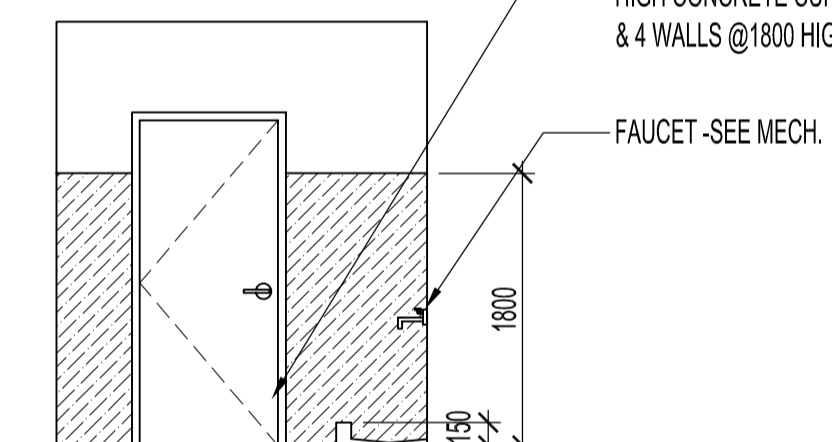


14 JANITOR 114
 A16/A16 ELEVATION SCALE 1:50

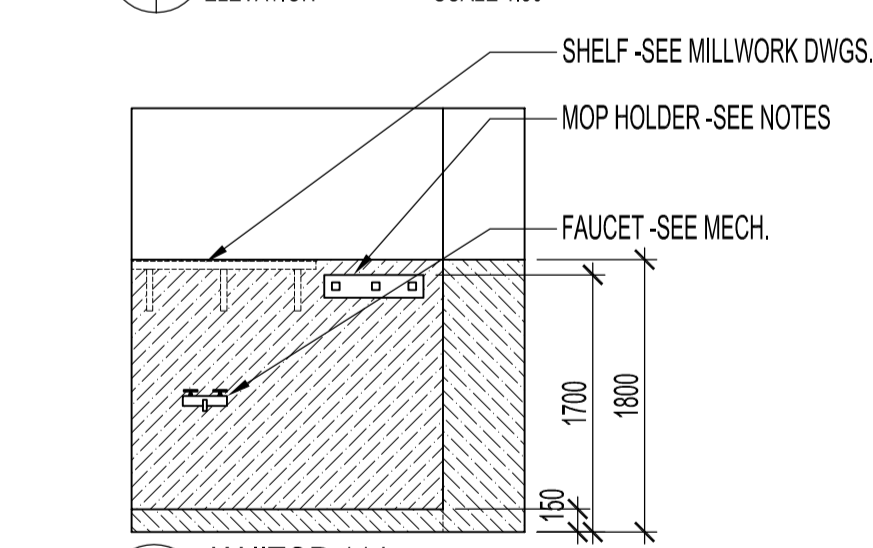


15 JANITOR 114
 A16/A16 ELEVATION SCALE 1:50

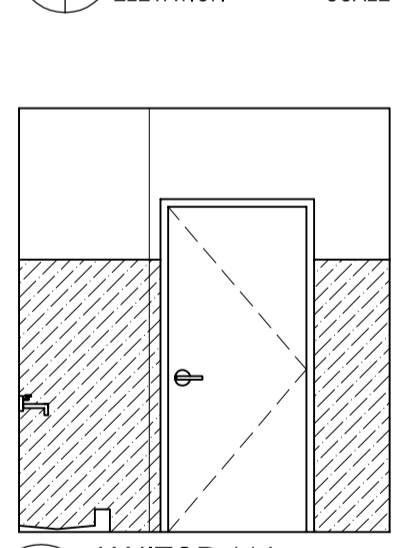

16 JANITOR 114
 A16/A16 ELEVATION SCALE 1:50

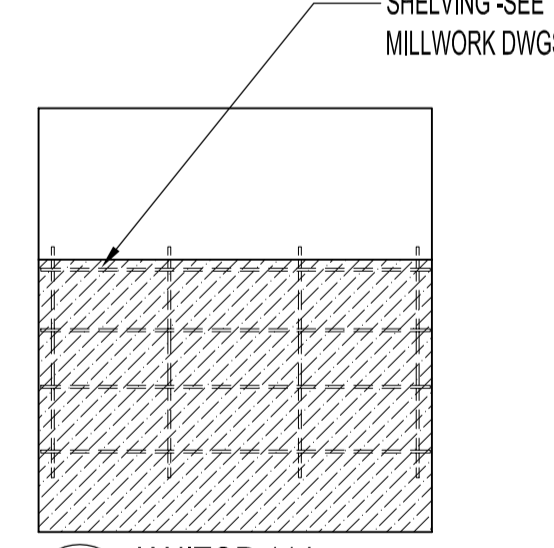


17 JANITOR 114
 A16/A16 ELEVATION SCALE 1:50

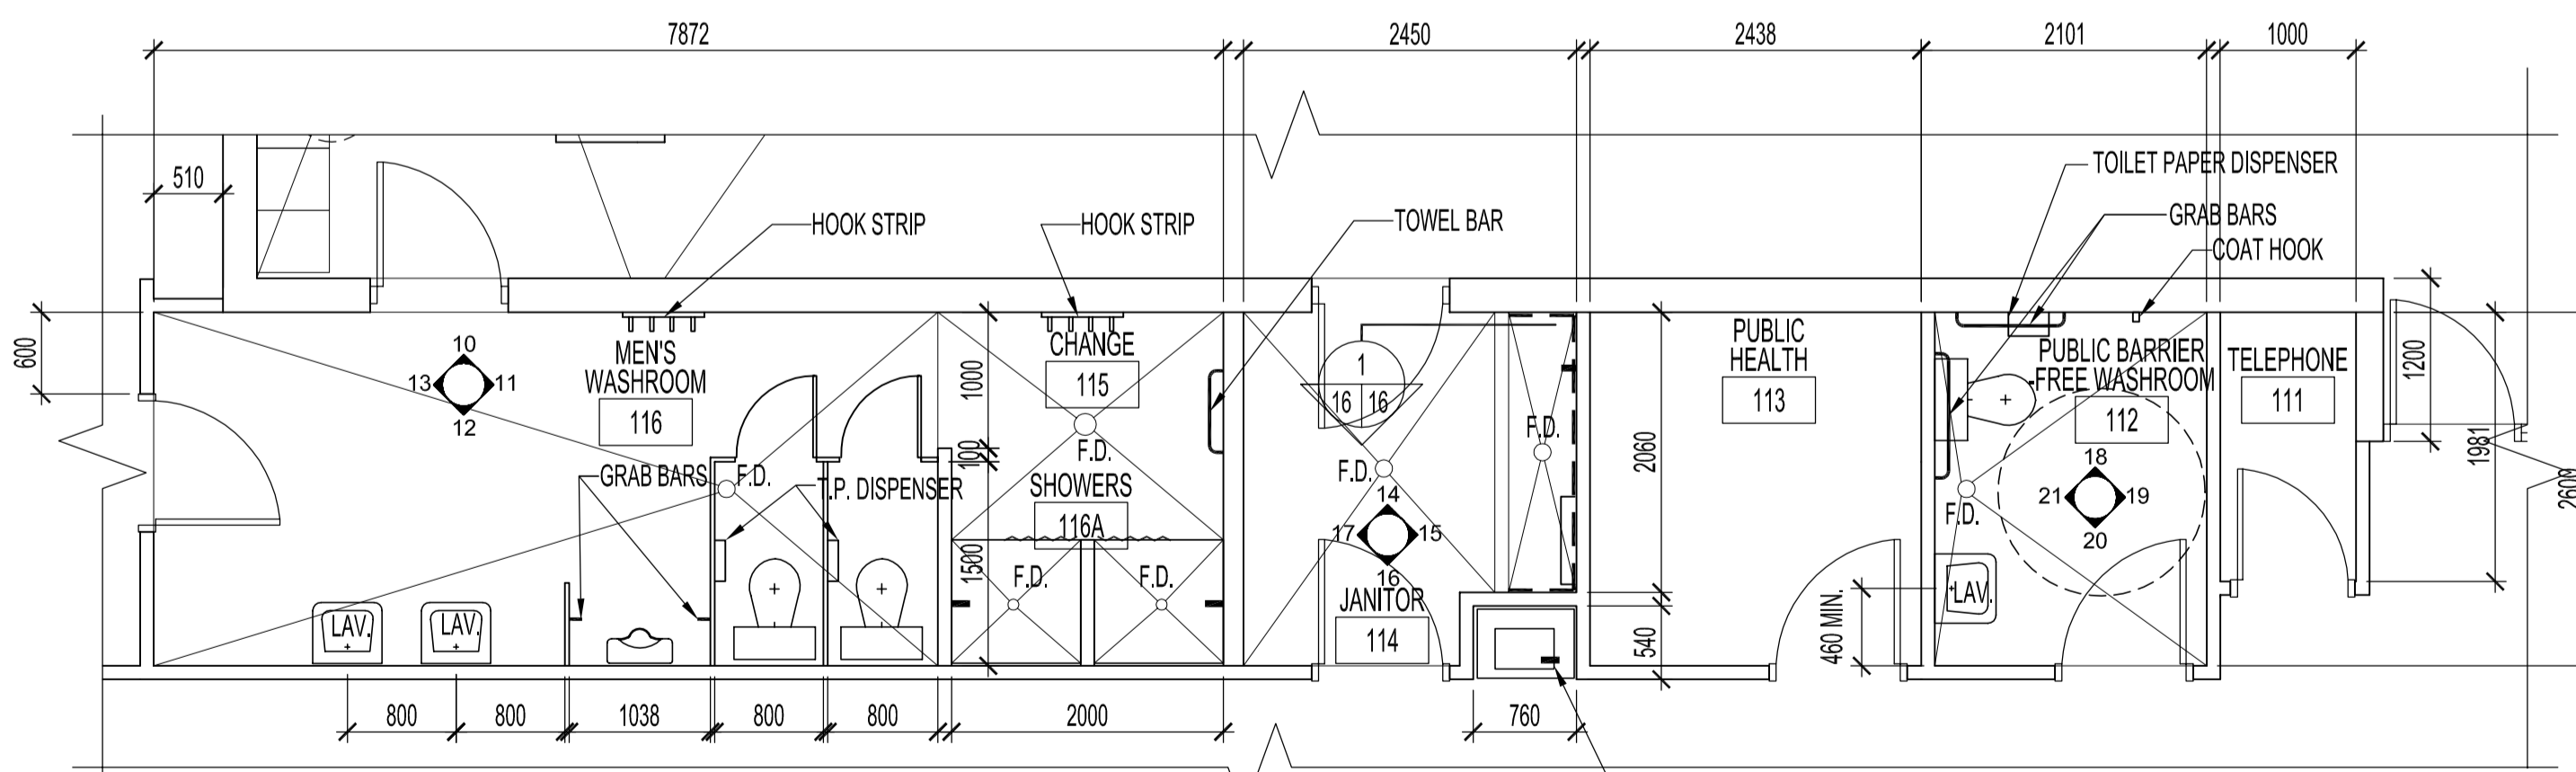



2 PARTIAL MAIN FLOOR PLAN
 A3/A16 SCALE 1:50

LEGEND


- HEAVY DASHED LINES INDICATE CEMENT BACKER BOARD @ FULL WALL HEIGHTS
- EPOXY WALL & FLOOR COATING TYPICAL FOR ALL ELEVATIONS UNLESS NOTED OTHERWISE-SEE NOTES & SPECS.
- 150 CERAMIC TILE TO 1975 HEIGHT W/ ACCENT TILES. SEE SPECS. FOR TYPES

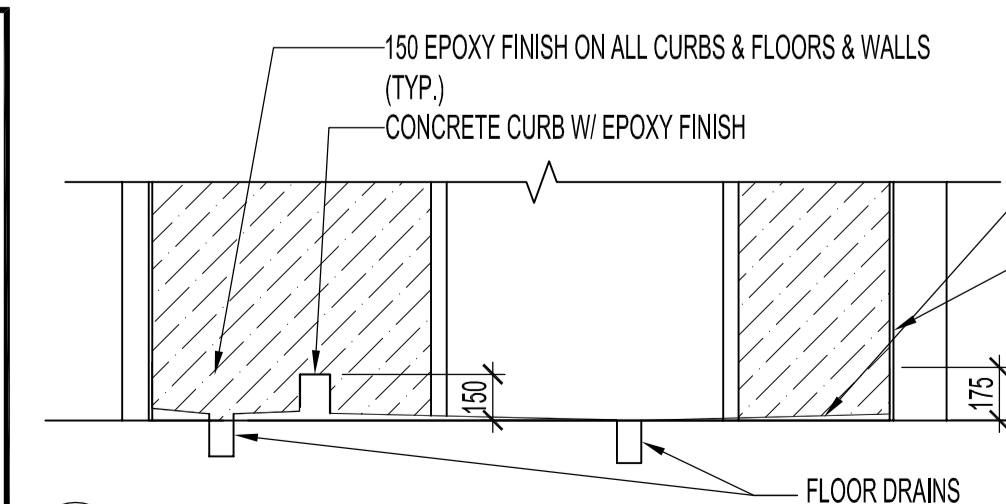


1 SECTION - JANITOR 114
 A16/A16 SCALE 1:25

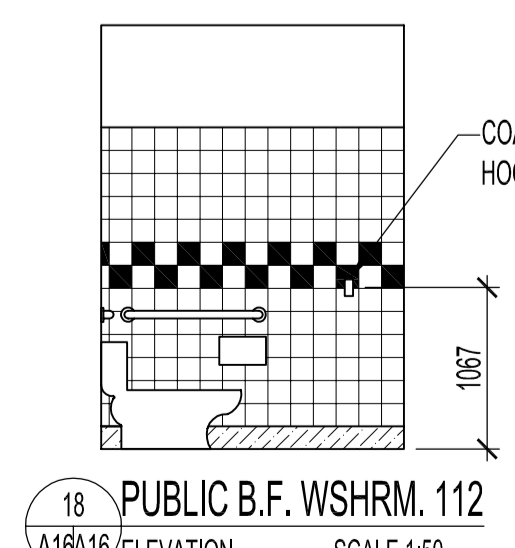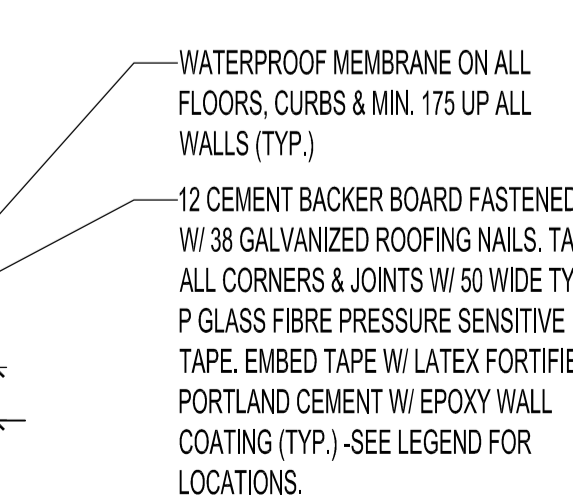


18 PUBLIC B.F. WSHRM. 112
 A16/A16 ELEVATION SCALE 1:50

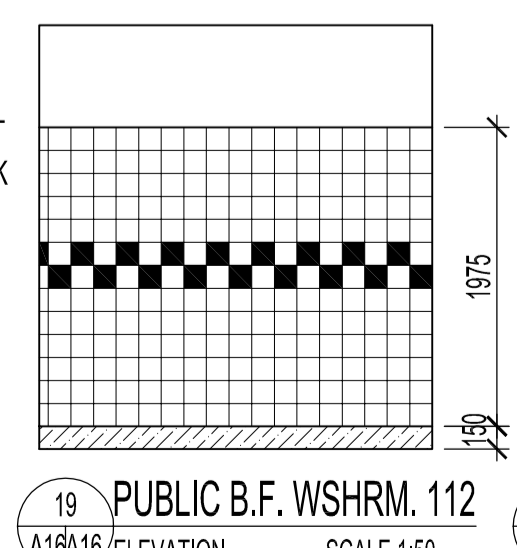

19 PUBLIC B.F. WSHRM. 112
 A16/A16 ELEVATION SCALE 1:50

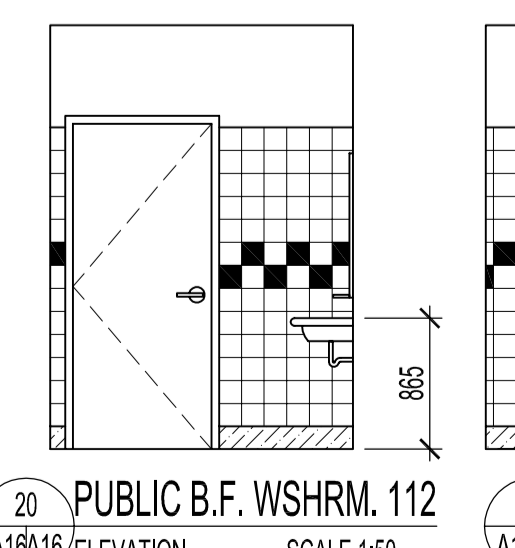

20 PUBLIC B.F. WSHRM. 112
 A16/A16 ELEVATION SCALE 1:50

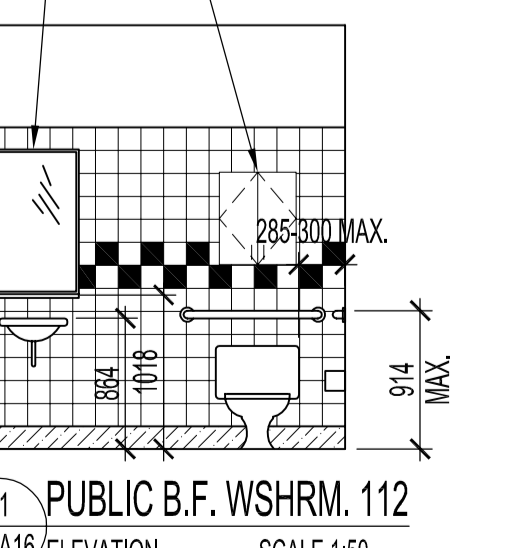

21 PUBLIC B.F. WSHRM. 112
 A16/A16 ELEVATION SCALE 1:50

NOTES :
GENERAL NOTES:
 -ALL ACCESSORIES, PLUMBING FIXTURES TO BE INSTALLED AT STANDARD HEIGHTS UNLESS NOTED OTHERWISE.
 -ALL ACCESSORIES, PLUMBING FIXTURES IN BARRIER FREE WASHROOMS TO BE INSTALLED TO THE LATEST MANITOBA BUILDING CODE STANDARDS FOR BARRIER-FREE ACCESS.
WALL, FLOOR & CEILING FINISHES:
 -ALL FLOORS TO HAVE EPOXY COATING W/ 150 EPOXY COVEBASE UNLESS NOTED OTHERWISE.
 -SEE SPECIFICATIONS, ROOM FINISH SCHEDULE ON A7, ELEVATIONS & SECTION 1 ON DWG. A16 FOR ALL WALL, FLOOR & CEILING FINISHES.
WASHROOM, SHOWER, CORRIDOR & JANITOR ACCESSORIES
 -ALL ACCESSORIES TO BE BOBRICK BRAND. SEE SPECIFICATIONS FOR TYPES & AMOUNTS.
 -SEE SPECIFICATIONS FOR ALL WASHROOM PARTITIONS & SHOWER STALLS.
MILLWORK
 -SEE FURNITURE & MILLWORK PLAN FOR MILLWORK REQUIREMENTS.

ORIGINAL STAMPED BY: R. K. FOK LI Arch.
 DATE: 2006.07.18

NO.	REVISION/DESCRIPTION	BY	DATE
SEALS			

DRAWN BY	MMK	CHECKED BY	APPROVED
DATE	2006.07.10	USER APPROVAL	

CITY OF WINNIPEG
 PLANNING, PROPERTY &
 DEVELOPMENT DEPARTMENT
 CIVIC ACCOMMODATIONS DIVISION
 300 - 65 GARRY ST. R3C 4K4

PROJECT
 WEST TRANSCONA
 FIRE PARAMEDIC STATION 21
 1446 REGENT AVENUE W.
 SHEET TITLE
 ENLARGED WASHROOM PLANS
 ELEVATIONS & SECTIONS

SCALE	PROJECT NO.	SHEET NO.
AS SHOWN	2004-058	A16