


10 WALL SECTION
WB-B0110 1 : 50



11 WALL SECTION
WB-B0206 1 : 50

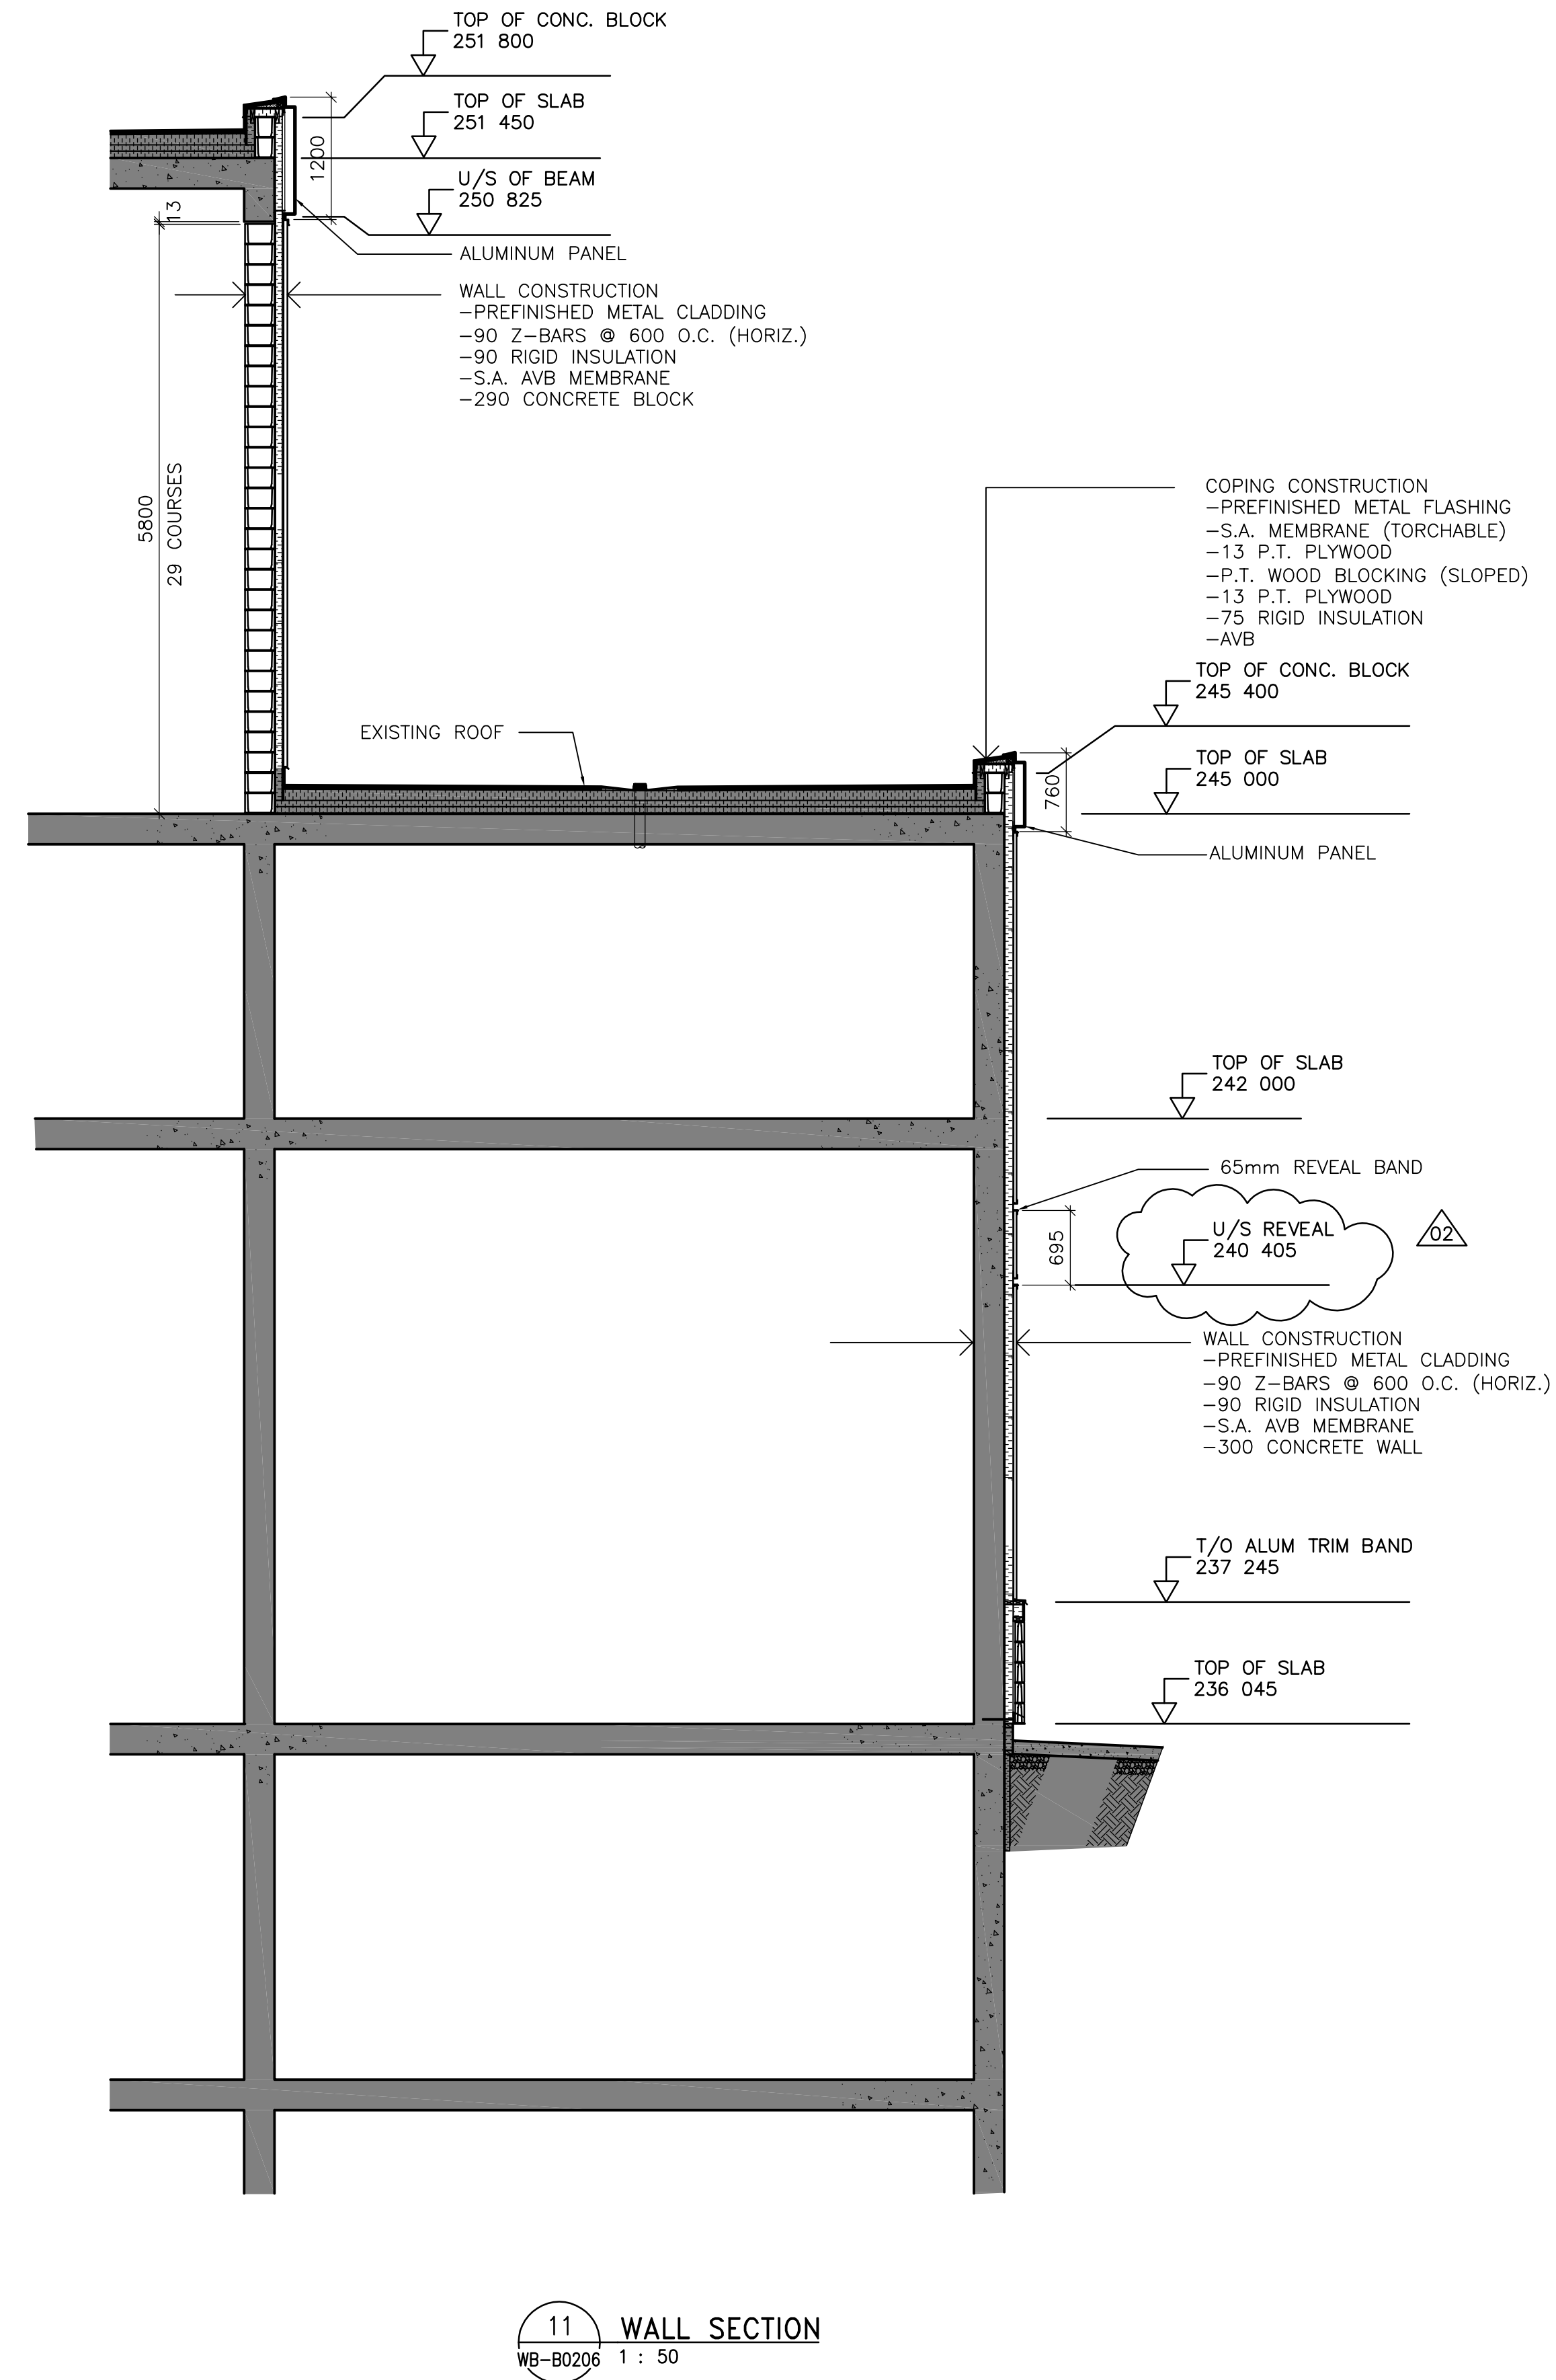

NO.	REVISIONS	DATE	BY
02	793-2006 ADDENDUM 2	07/04/05	LK
01	793-2006 ADDENDUM 1	07/03/29	LK
00	ISSUED FOR TENDER	07/03/19	LK

DESIGNED BY: NC	CHECKED BY: LK
DRAWN BY: IC	APPROVED BY: AHL
SCALE: AS SHOWN	RELEASED FOR CONSTRUCTION BY: R. SOROKOWSKI
DATE: 2005/11/28	DATE: 2007/03/19

ENGINEER'S SEAL
ORIGINAL SIGNED BY
NEIL COOPER
2007/03/19
CONSULTANT DRAWING NO.
WB-B0253

THE CITY OF WINNIPEG
WATER AND WASTE DEPARTMENT
ENGINEERING DIVISION

WATER TREATMENT PLANT
MAIN BUILDING
BUILDING ENVELOPE

ARCHITECTURAL
WALL SECTIONS

CITY FILE NUMBER
SHEET OF
CITY DRAWING NUMBER
1-0601B-A-B0253-001-02D