


**A PARTIAL ELECTRICAL SITE PLAN**  
SCALE: 1 : 750

**NOTES**  
1. FIBRE OPTIC CABLE IS TO BE 62.5/125 MICRON MULTIMODE CONDUCTOR SUITABLE FOR DIRECT EARTH BURIAL.

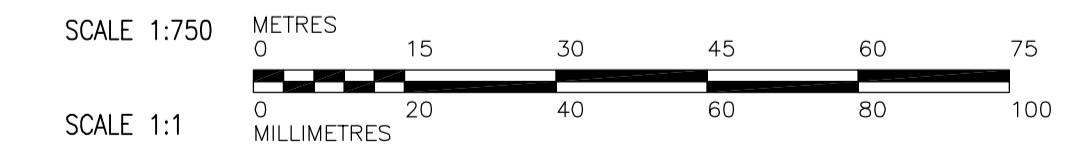

**APEGM**  
Certificate of Authorization  
Earth Tech Canada Inc.  
No. 730

B.M. ELEV.			
DESIGNED BY	BLM	CHECKED BY	PS
DRAWN BY	ERC	APPROVED BY	AHL
SCALE:	AS SHOWN	RELEASED FOR CONSTRUCTION BY:	R. SOROKOWSKI
NO. REVISIONS	DATE	DATE	DATE
01	ISSUED FOR ADDENDUM 4	07/12/14	ERC
00	ISSUED FOR TENDER	07/11/09	ERC
2006/11/15			

**CH2M HILL**  
Frederickson Cooper ARCHITECTS

**EarthTech**  
A Tech International Ltd. Company

ENGINEER'S SEAL  
ORIGINAL SIGNED BY  
P. STRYK  
2007/11/09  
CONSULTANT DRAWING NO.  
WY-E0180

**THE CITY OF WINNIPEG**  
WATER AND WASTE DEPARTMENT  
ENGINEERING DIVISION

WATER TREATMENT PLANT  
CONSTRUCTION OF ROADS AND LANDSCAPING

ELECTRICAL  
SITE LIGHTING PLAN

CITY FILE NUMBER  
SHEET OF  
CITY DRAWING NUMBER  
1-0601Y-A-E0180-001-01D