



- * PARKING LOT CABLING TO BE AS SHOWN ON DRAWING WY-E0181 TO EACH PARKING POST. REFER TO TRENCH DETAIL
- * REFER TO DRAWING WY-E0181 FOR EXACT LOCATION OF PARKING RECEPTACLES


A PARKING PEDESTAL DETAIL
WY-E0181 SCALE: NTS

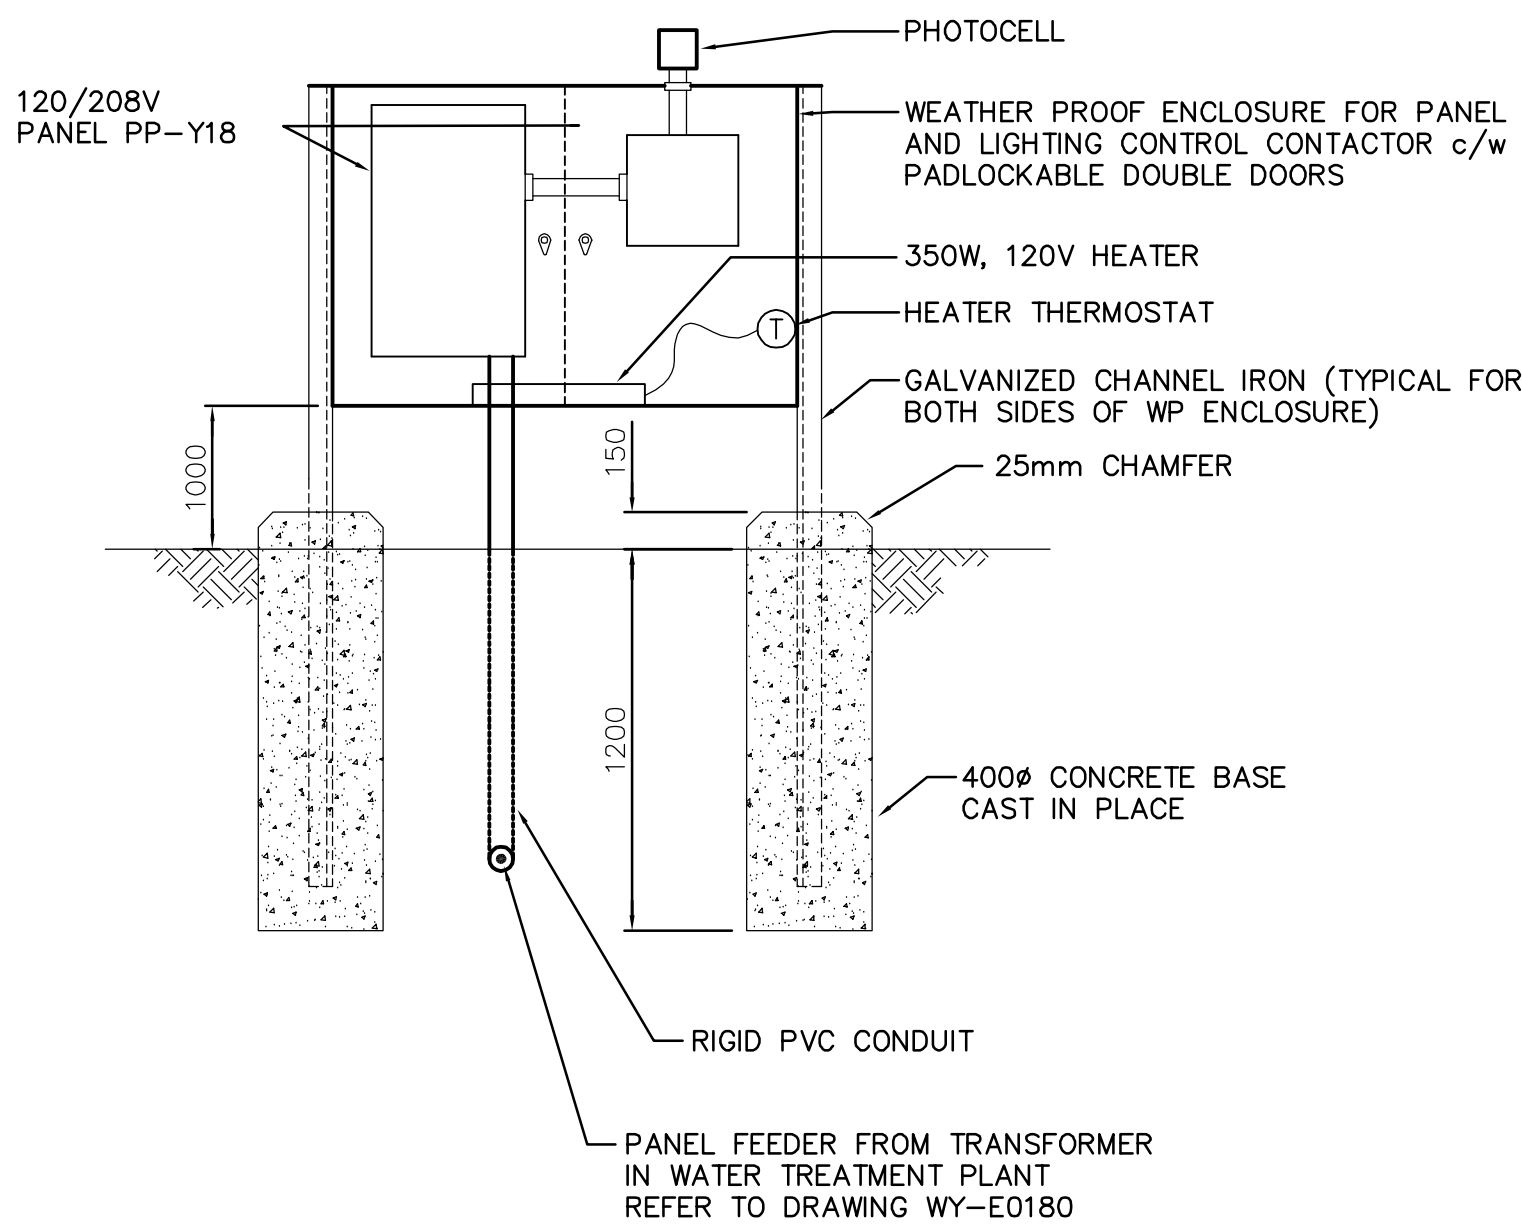

B PARKING PANEL PP-Y18 DETAIL
WY-E0180 SCALE: NTS
B WY-E0181


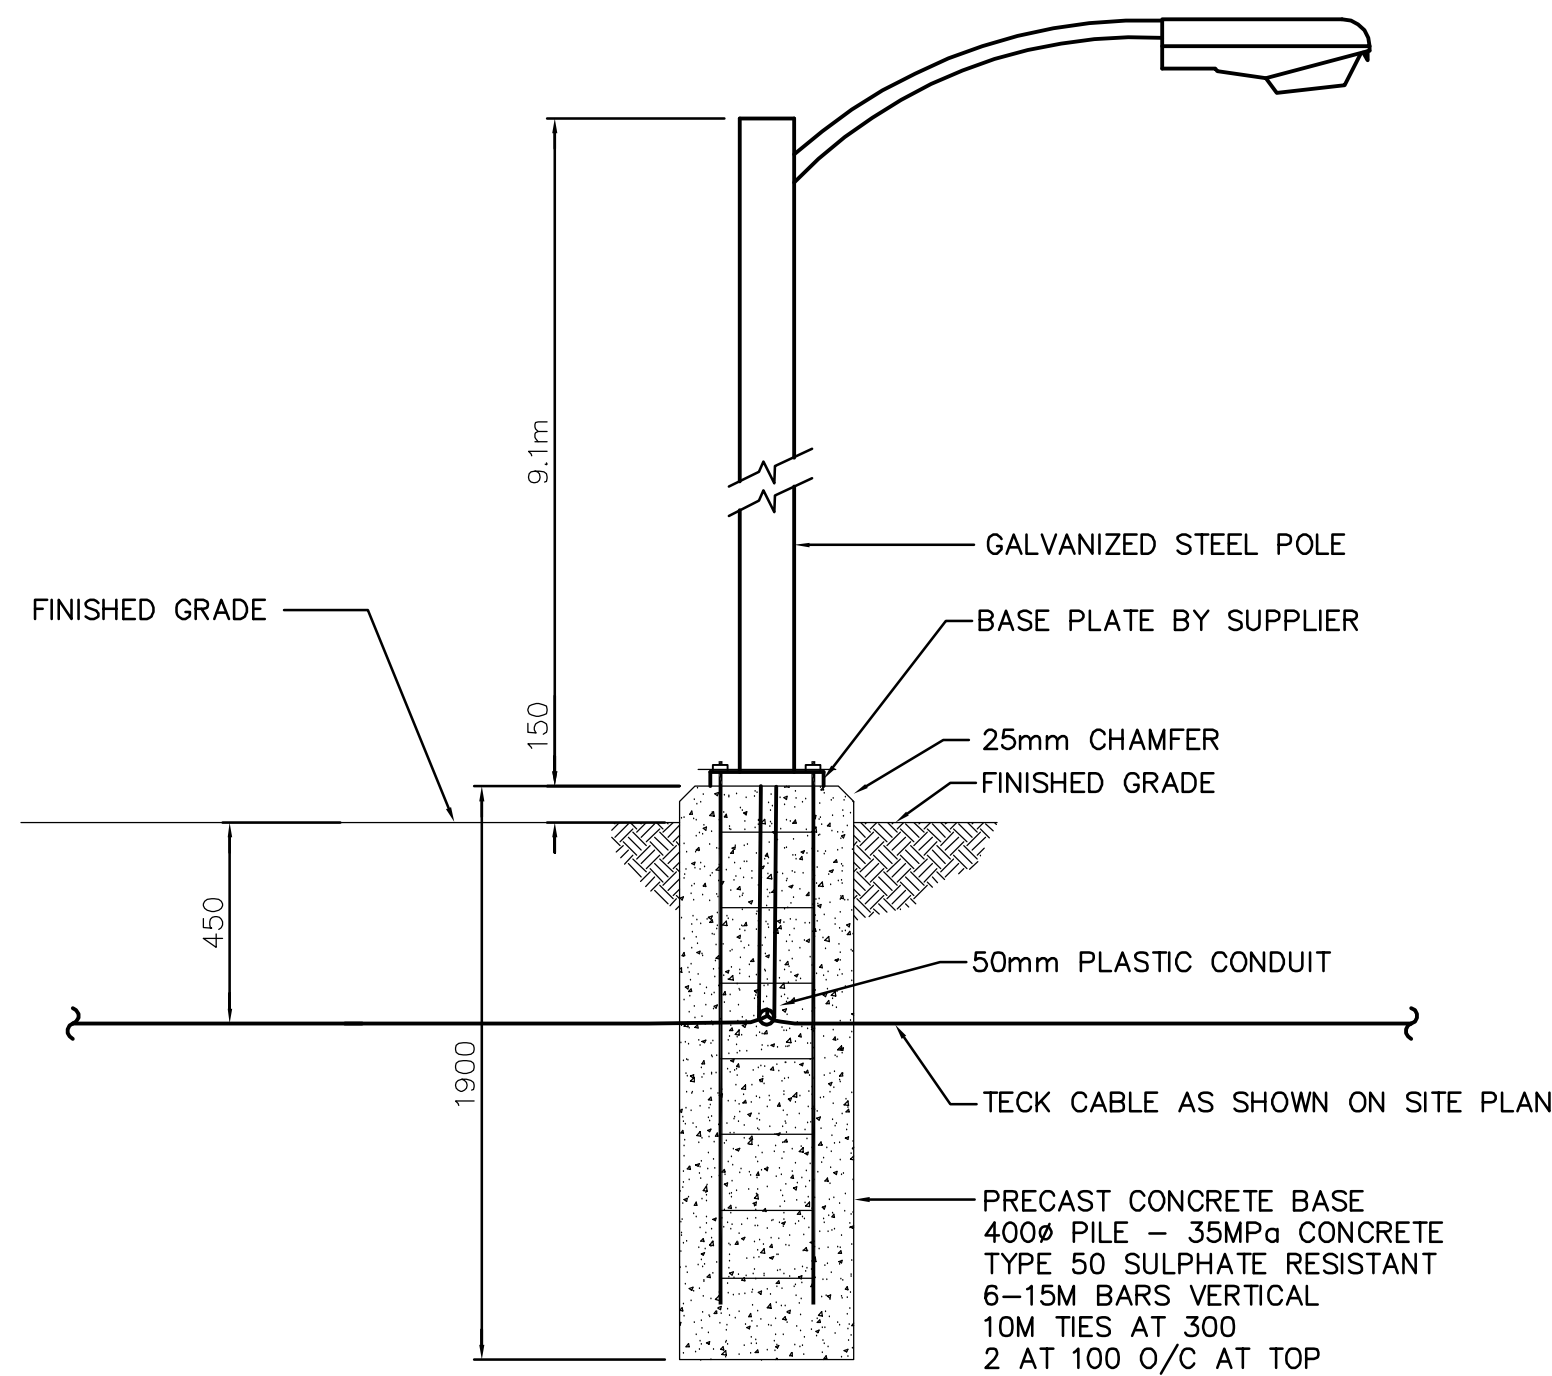


C LIGHT STANDARD (TYPE A) MOUNTING DETAIL
WY-E0180 SCALE: NTS


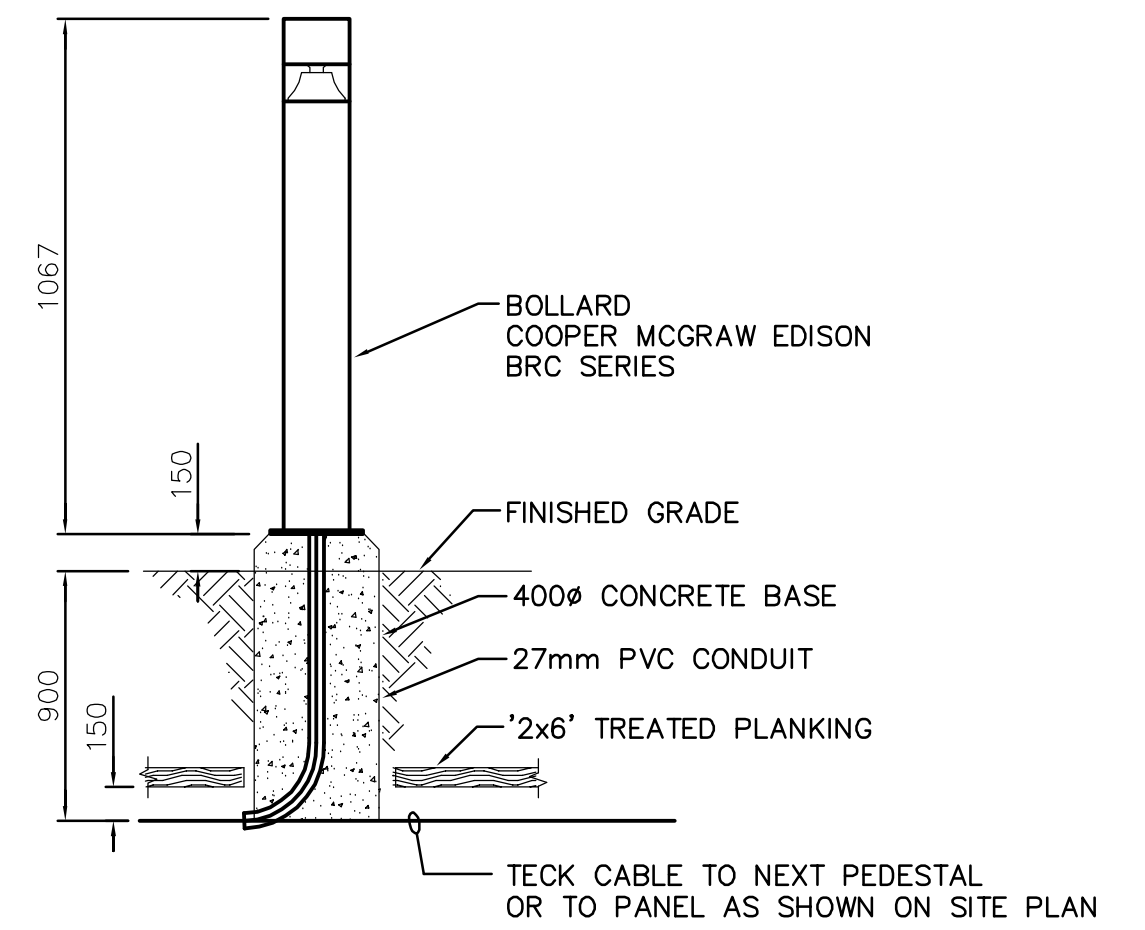


- * PARKING LOT CABLING TO BE AS SHOWN ON DRAWING WY-E0181 TO EACH BOLLARD. REFER TO TRENCH DETAIL
- * REFER TO DRAWING WY-E0181 FOR EXACT LOCATION OF BOLLARDS


D BOLLARD LUMINAIRE (TYPE B) DETAIL
WY-E0181 SCALE: NTS

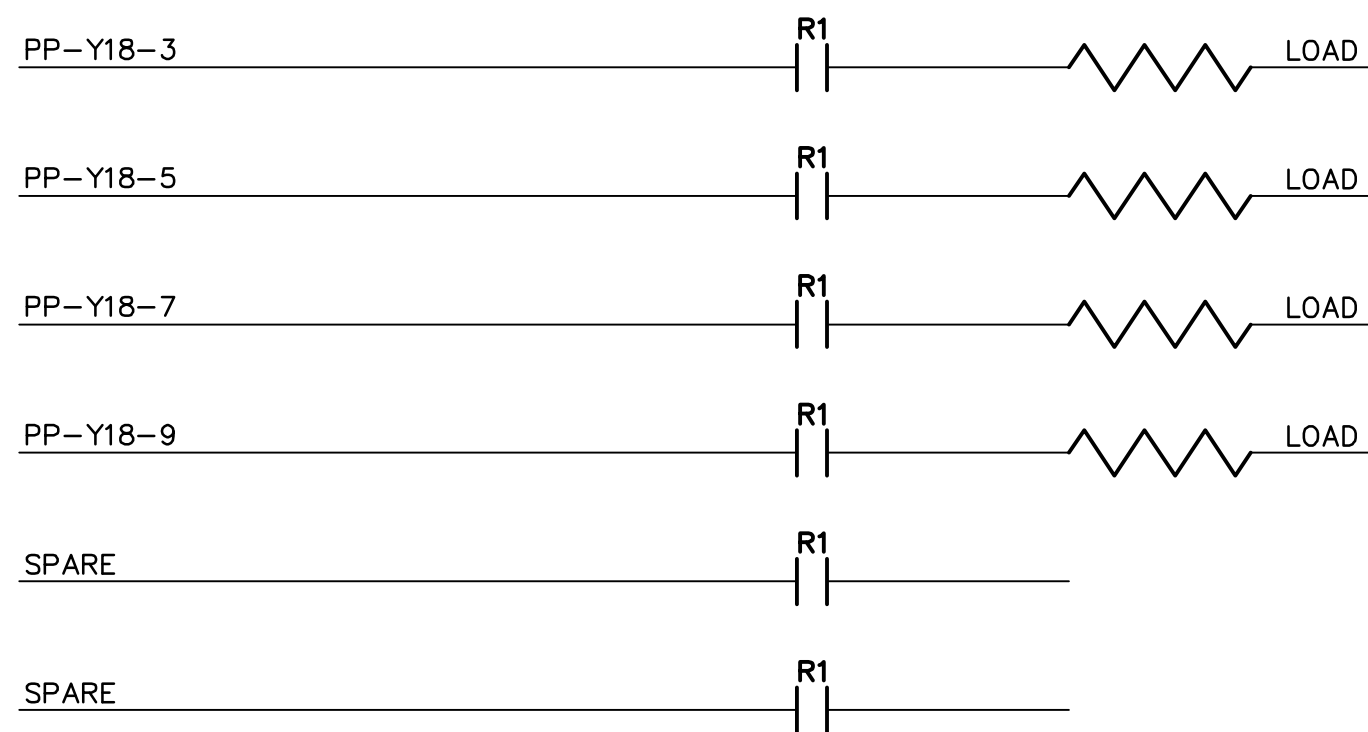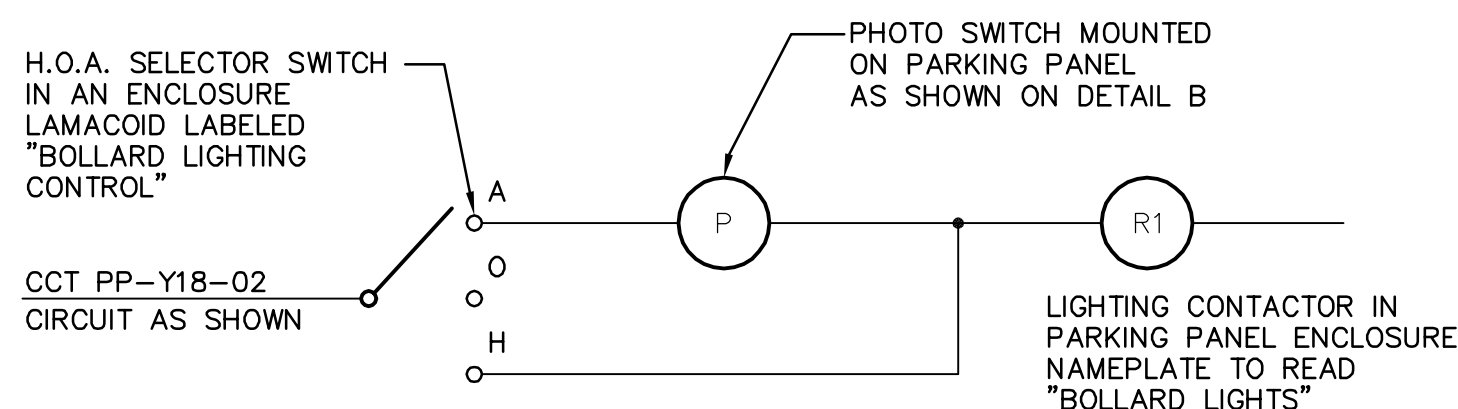

E BOLLARD LIGHTING CONTROL DETAIL
WY-E0180 SCALE: NTS

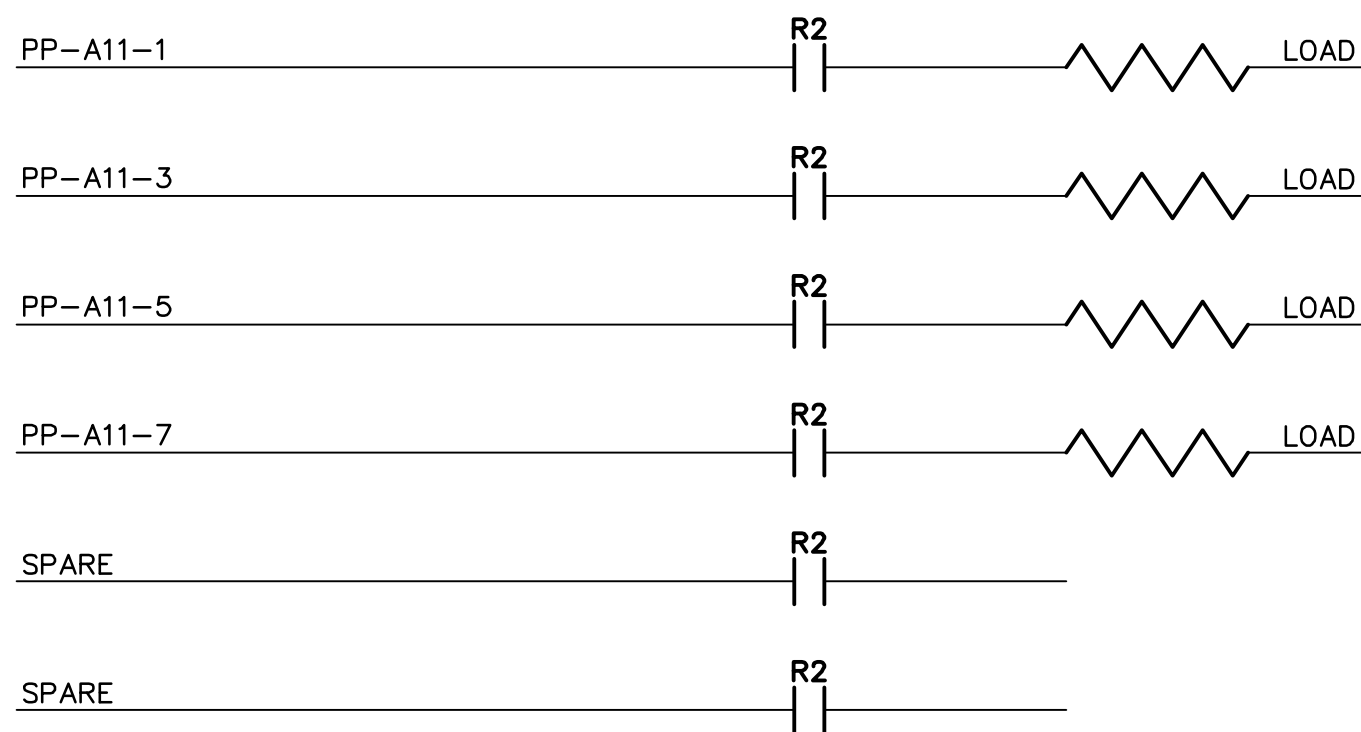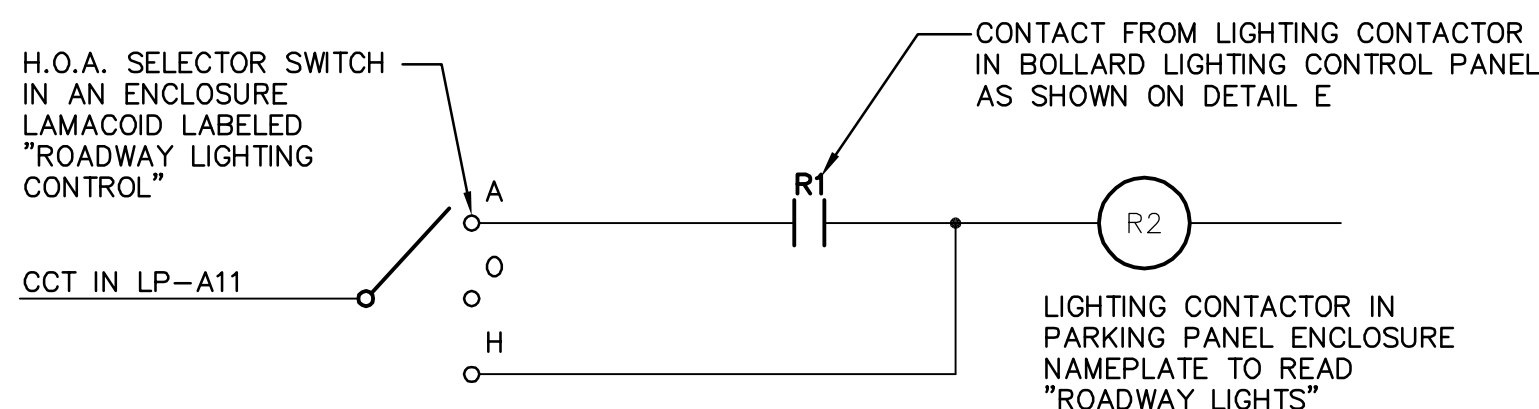

F ROADWAY LIGHTING CONTROL LCP-A11 DETAIL
WY-E0481 SCALE: NTS

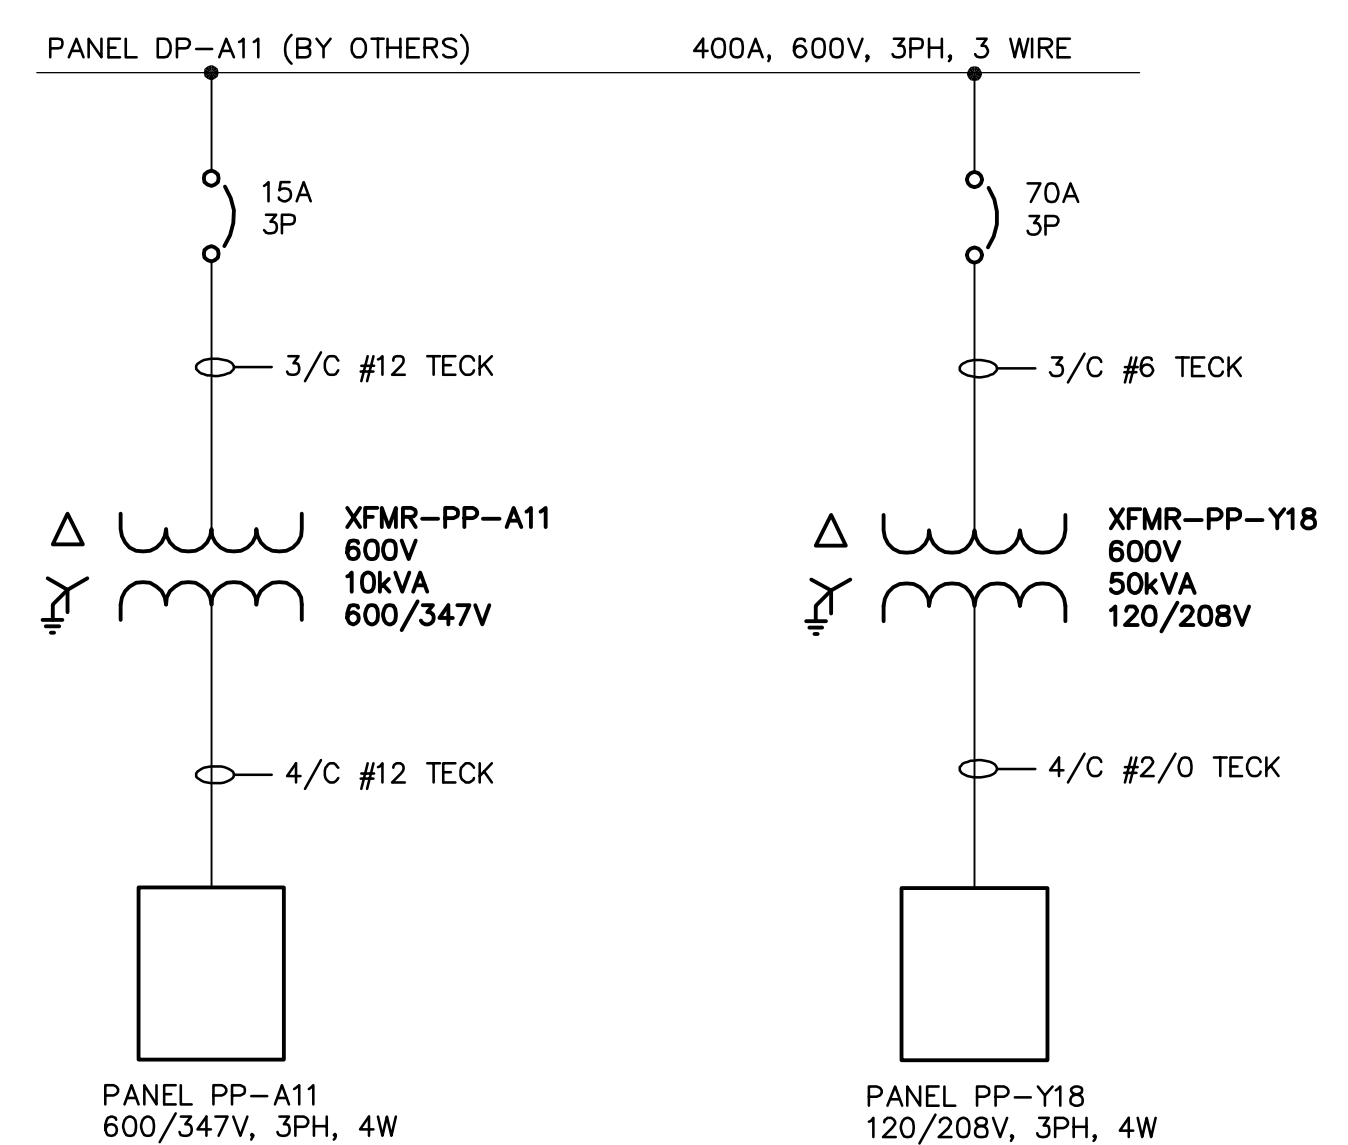

G SINGLE LINE DIAGRAM
WY-E0180 SCALE: NTS

 Certificate of Authorization Earth Tech Canada Inc. No. 730	B.M. ELEV.	 Frederickson Cooper ARCHITECTS	 A Tyco International Ltd. Company	ENGINEER'S SEAL ORIGINAL SIGNED BY P. STRYK 2007/11/09	 THE CITY OF WINNIPEG WATER AND WASTE DEPARTMENT ENGINEERING DIVISION	
	DESIGNED BY BLM CHECKED BY PS DRAWN BY ERC APPROVED BY AHL SCALE: NTS RELEASED FOR CONSTRUCTION BY: R. SOROKOWSKI	CONSULTANT DRAWING NO. WY-E0480	WATER TREATMENT PLANT CONSTRUCTION OF ROADS AND LANDSCAPING	CITY FILE NUMBER SHEET OF		
	00 ISSUED FOR TENDER 07/11/09 ERC NO. REVISIONS DATE BY	DATE 2006/11/15 DATE	ELECTRICAL DETAILS	CITY DRAWING NUMBER 1-0601Y-D-E0480-001-000		