



PLAN
SCALE 1:750

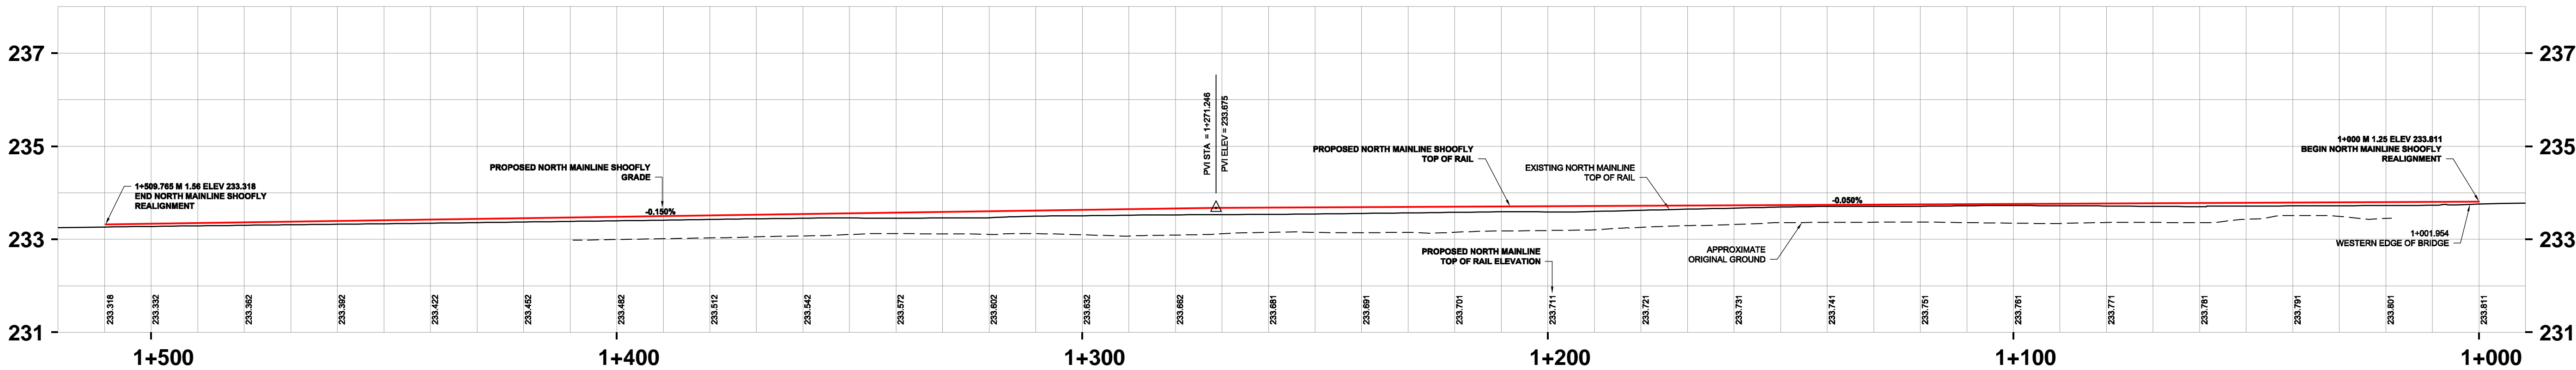

PROFILE
H=1:750
V=1:75
PROPOSED NORTH MAINLINE

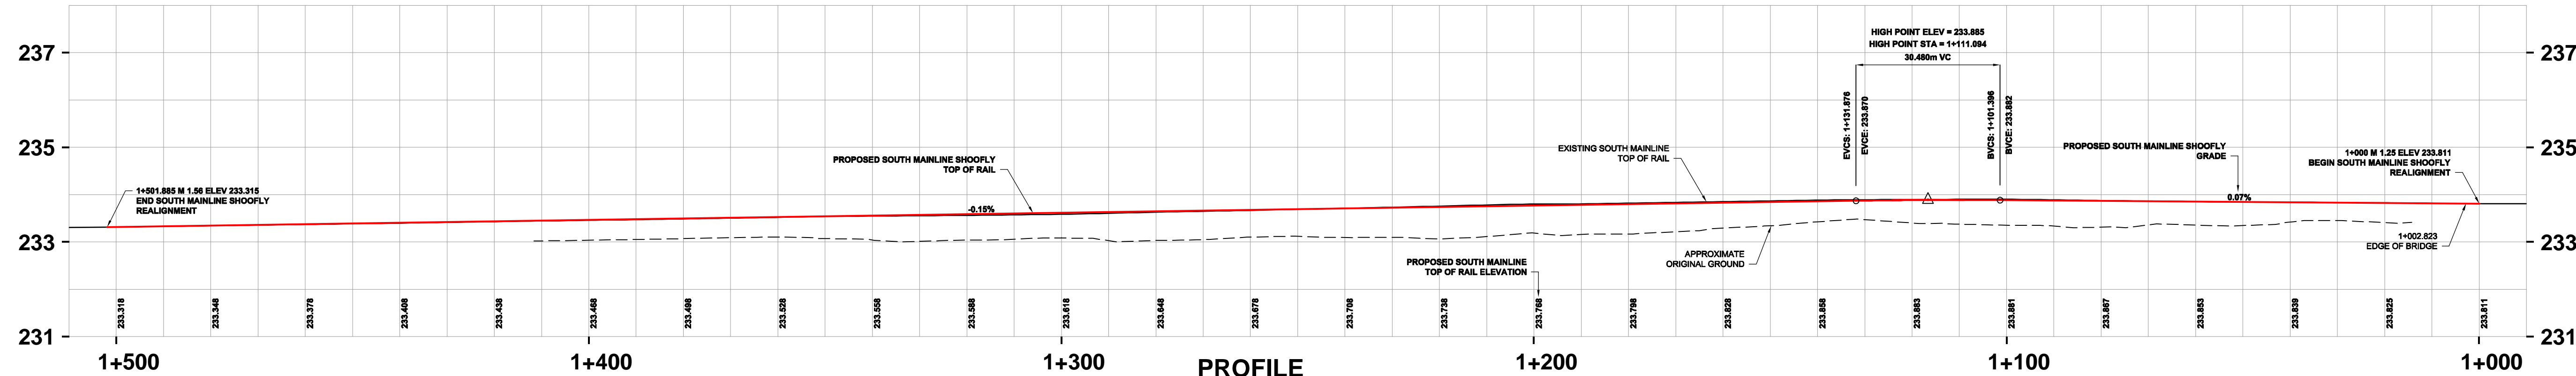

PROFILE
H=1:750
V=1:75
PROPOSED SOUTH MAINLINE

- GENERAL NOTES:
1. ALL DIMENSIONS ARE METRIC UNLESS NOTED OTHERWISE
 2. SURVEY CONTROL IS BASED ON GEODETIC BENCHMARK
 3. ALL UTILITIES TO BE LOCATED IN THE FIELD AND MODIFIED AS NECESSARY TO TC-E-10 AND TC-E-11 STANDARDS.
 4. ALL EXISTING FENCES AFFECTED BY CONSTRUCTION ARE TO BE REBUILT BY THE CONTRACTOR AS DIRECTED BY THE CONTRACT ADMINISTRATOR.
 5. ALL PROPERTY LINES ARE PROVIDED FOR INFORMATION PURPOSES ONLY.
 6. SEE 01-CT6001 FOR GEOMETRIC CONTROL TABLES.

WARNING - BURIED S&C CABLES
PRIOR TO CONSTRUCTION CN SIGNALS MUST BE NOTIFIED. AS WELL, USE EXTREME CAUTION WHEN WORKING NEAR CABLES, JUNCTION BOXES, CONDUITS, ETC.

LEGEND				LEGEND			
EXISTING	DESCRIPTION	PROPOSED	EXISTING	DESCRIPTION	PROPOSED	EXISTING	DESCRIPTION
	SWITCH STAND & POWER SWITCH			REMOVED/RELOCATED 85# RAIL			OVERHEAD POWER WITH POLE
	DERAIL			REMOVED/RELOCATED 115# RAIL			UNDERGROUND POWER LINE
	CROSSING PLANKS			REMOVED/RELOCATED 132# RAIL			UNDERGROUND FIBRE OPTIC LINE
	CENTRELINE MAIN			SURVEY CONTROL POINT			UNDERGROUND GAS LINE
	CENTRELINE YARD TRACK			CULVERT/CULVERT EXTENSION			OVERHEAD CNT LINE WITH POLE
	CENTRELINE - 85# RAIL			GRAVEL ROADWAY			UNDERGROUND S&C CABLE
	CENTRELINE - 115# RAIL			PAVED ROADWAY			
	CENTRELINE - 132# RAIL			CHAINLINK FENCE			

LOCATION APPROVED	
UNDERGROUND STRUCTURES	
SUPR. U/G STRUCTURES COMMITTEE	DATE
NOTE: LOCATION OF UNDERGROUND STRUCTURES AS SHOWN ARE BASED ON THE BEST INFORMATION AVAILABLE. BUT NO GUARANTEE IS GIVEN THAT ALL EXISTING UTILITIES ARE SHOWN OR THAT THE GIVEN LOCATIONS ARE EXACT. CONFIRMATION OF EXISTENCE AND EXACT LOCATION OF ALL SERVICES MUST BE OBTAINED FROM THE INDIVIDUAL UTILITIES BEFORE PROCEEDING WITH CONSTRUCTION.	
0	ISSUED FOR TENDER
NO.	REVISIONS
09/05/27	RCP
YYMMDD	BY

AECOM	
DESIGNED BY	RCP
CHECKED BY	KEG
DRAWN BY	BRP
APPROVED BY	
HOR. SCALE	1:750
VERT. SCALE	1:75
RELEASED FOR CONSTRUCTION	
DATE	09/05/27
DATE	

PROFESSIONAL'S SEAL	
CONSULTANT DRAWING NO.	
F504-444-00_01-CT1002_R0	

THE CITY OF WINNIPEG	
TRANSIT DEPARTMENT	
SOUTH WEST TRANSIT CORRIDOR	
CN FORT ROUGE YARD	
PLAN AND PROFILE	
FINAL CONFIGURATION AND MAINLINE SHOOFLY PROFILES	
CITY DRAWING NUMBER	P-3309-03
SHEET	3 OF 14
DRAWING No.	01-CT1002
REV	0