


LAST SAVE: 2010/05/25 - 11:23am
PATH: M:\12577\0114\4ENG\425R\DO - General DWG\1-0102G-S0007-001-00.DWG

A1 SIZE - 594mm x 841mm

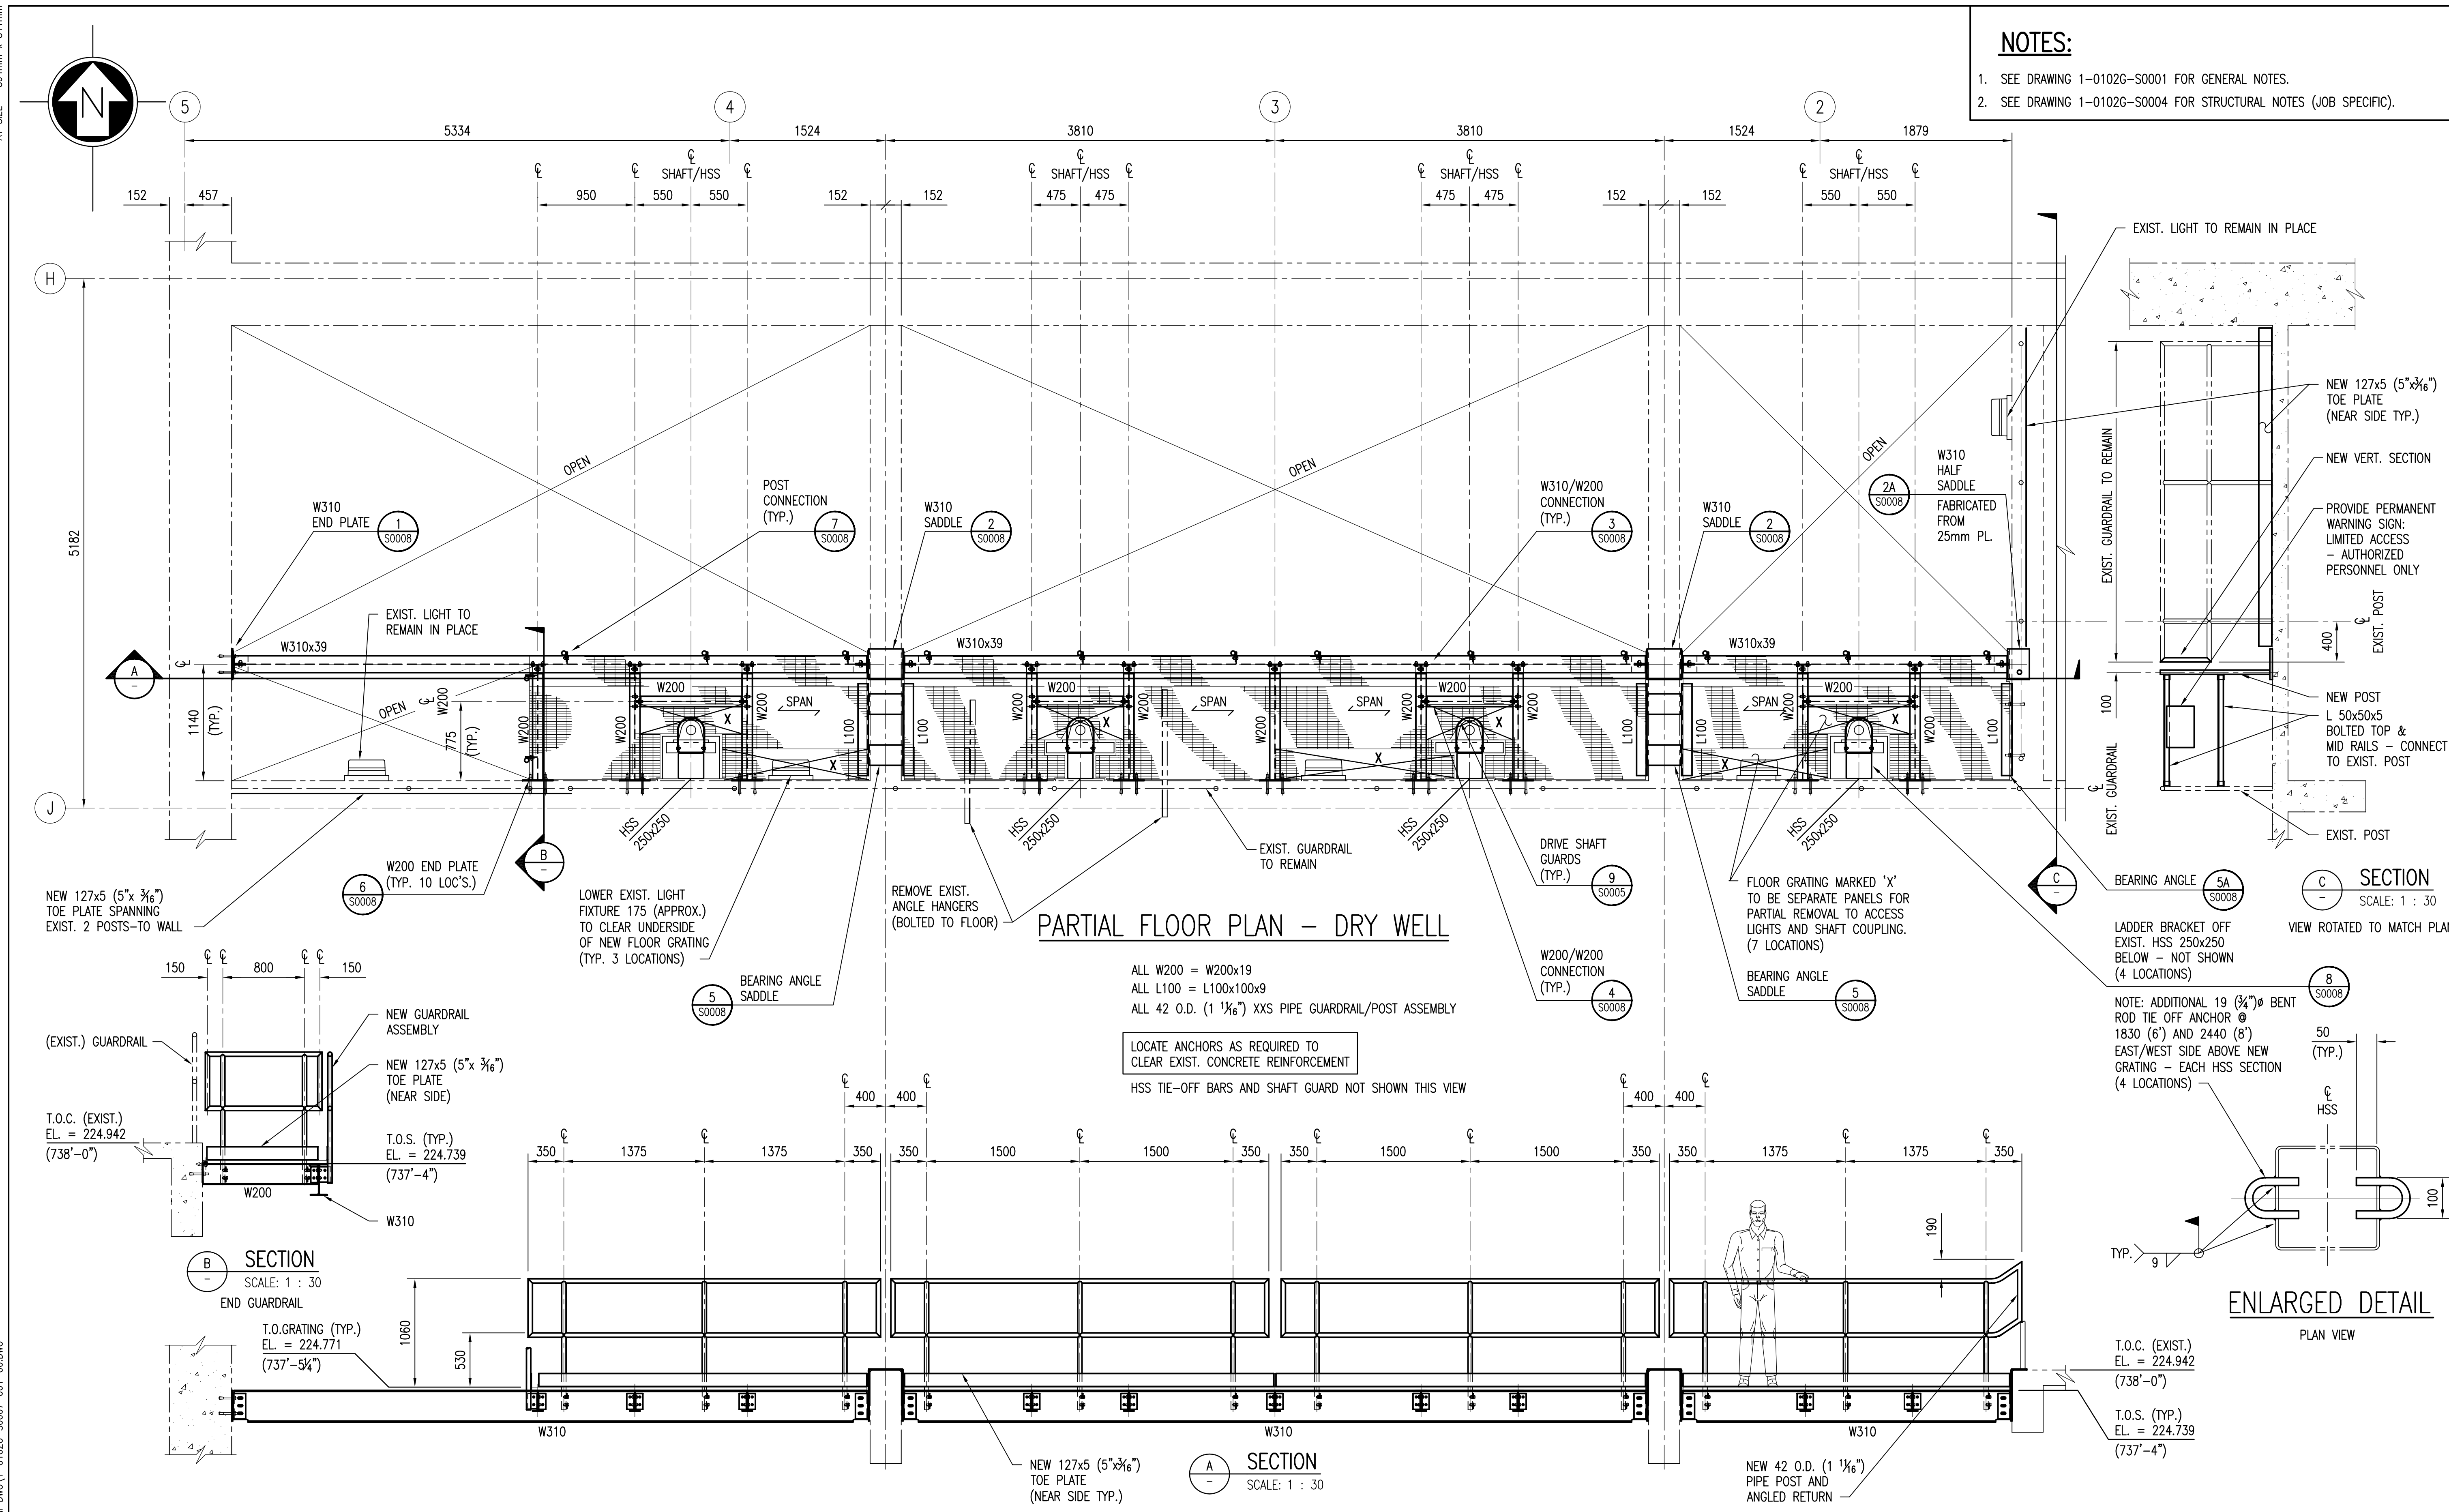

- NOTES:**
- SEE DRAWING 1-0102G-S0001 FOR GENERAL NOTES.
 - SEE DRAWING 1-0102G-S0004 FOR STRUCTURAL NOTES (JOB SPECIFIC).

SEP-22 PUMP & SCREEN BUILDING ARCH. BUILDING SECTIONS		SEP-21 PUMP & SCREEN BUILDING ARCH. FLOOR PLANS		1-0102G-S0008 DRY WELL RAW SEWAGE PUMPS DRIVE SHAFT AREA - PLAN & DETAILS	
DRAWING NUMBER		REFERENCE DRAWINGS			
1m 0.5m 0 0.5m 1m 1.5m 1 : 30		APEGN Certificate of Authorization SNC-Lavalin Inc. No. 4489		KEY PLAN 1:2500	
SNC-LAVALIN 148 Nature Park Way Winnipeg, MB, Canada R3P 0X7 204-788-8080		THE CITY OF WINNIPEG WATER AND WASTE DEPARTMENT SOUTH END WATER POLLUTION CONTROL CENTRE SAFETY UPGRADES PLAN & SECTIONS DRY WELL RAW SEWAGE PUMPS G101-RSP TO G104-RSP DRIVE SHAFT COUPLING ACCESS PLATFORMS		ORIGINAL DRAWING SEALED BY: R. C. BEAN SNC-LAVALIN 2010/05/21 REV. 0	
CITY DRAWING NUMBER 1-0102G-S0007		SHEET 001		REV. 0	
SIZE A1					