


LAST SAVE: 2010/05/25 - 11:26am
PATH: M:\12577\0114\4ENG\425R\DD - General DWG\1-0102P-S0002-001-00.DWG

A1 SIZE - 594mm x 841mm

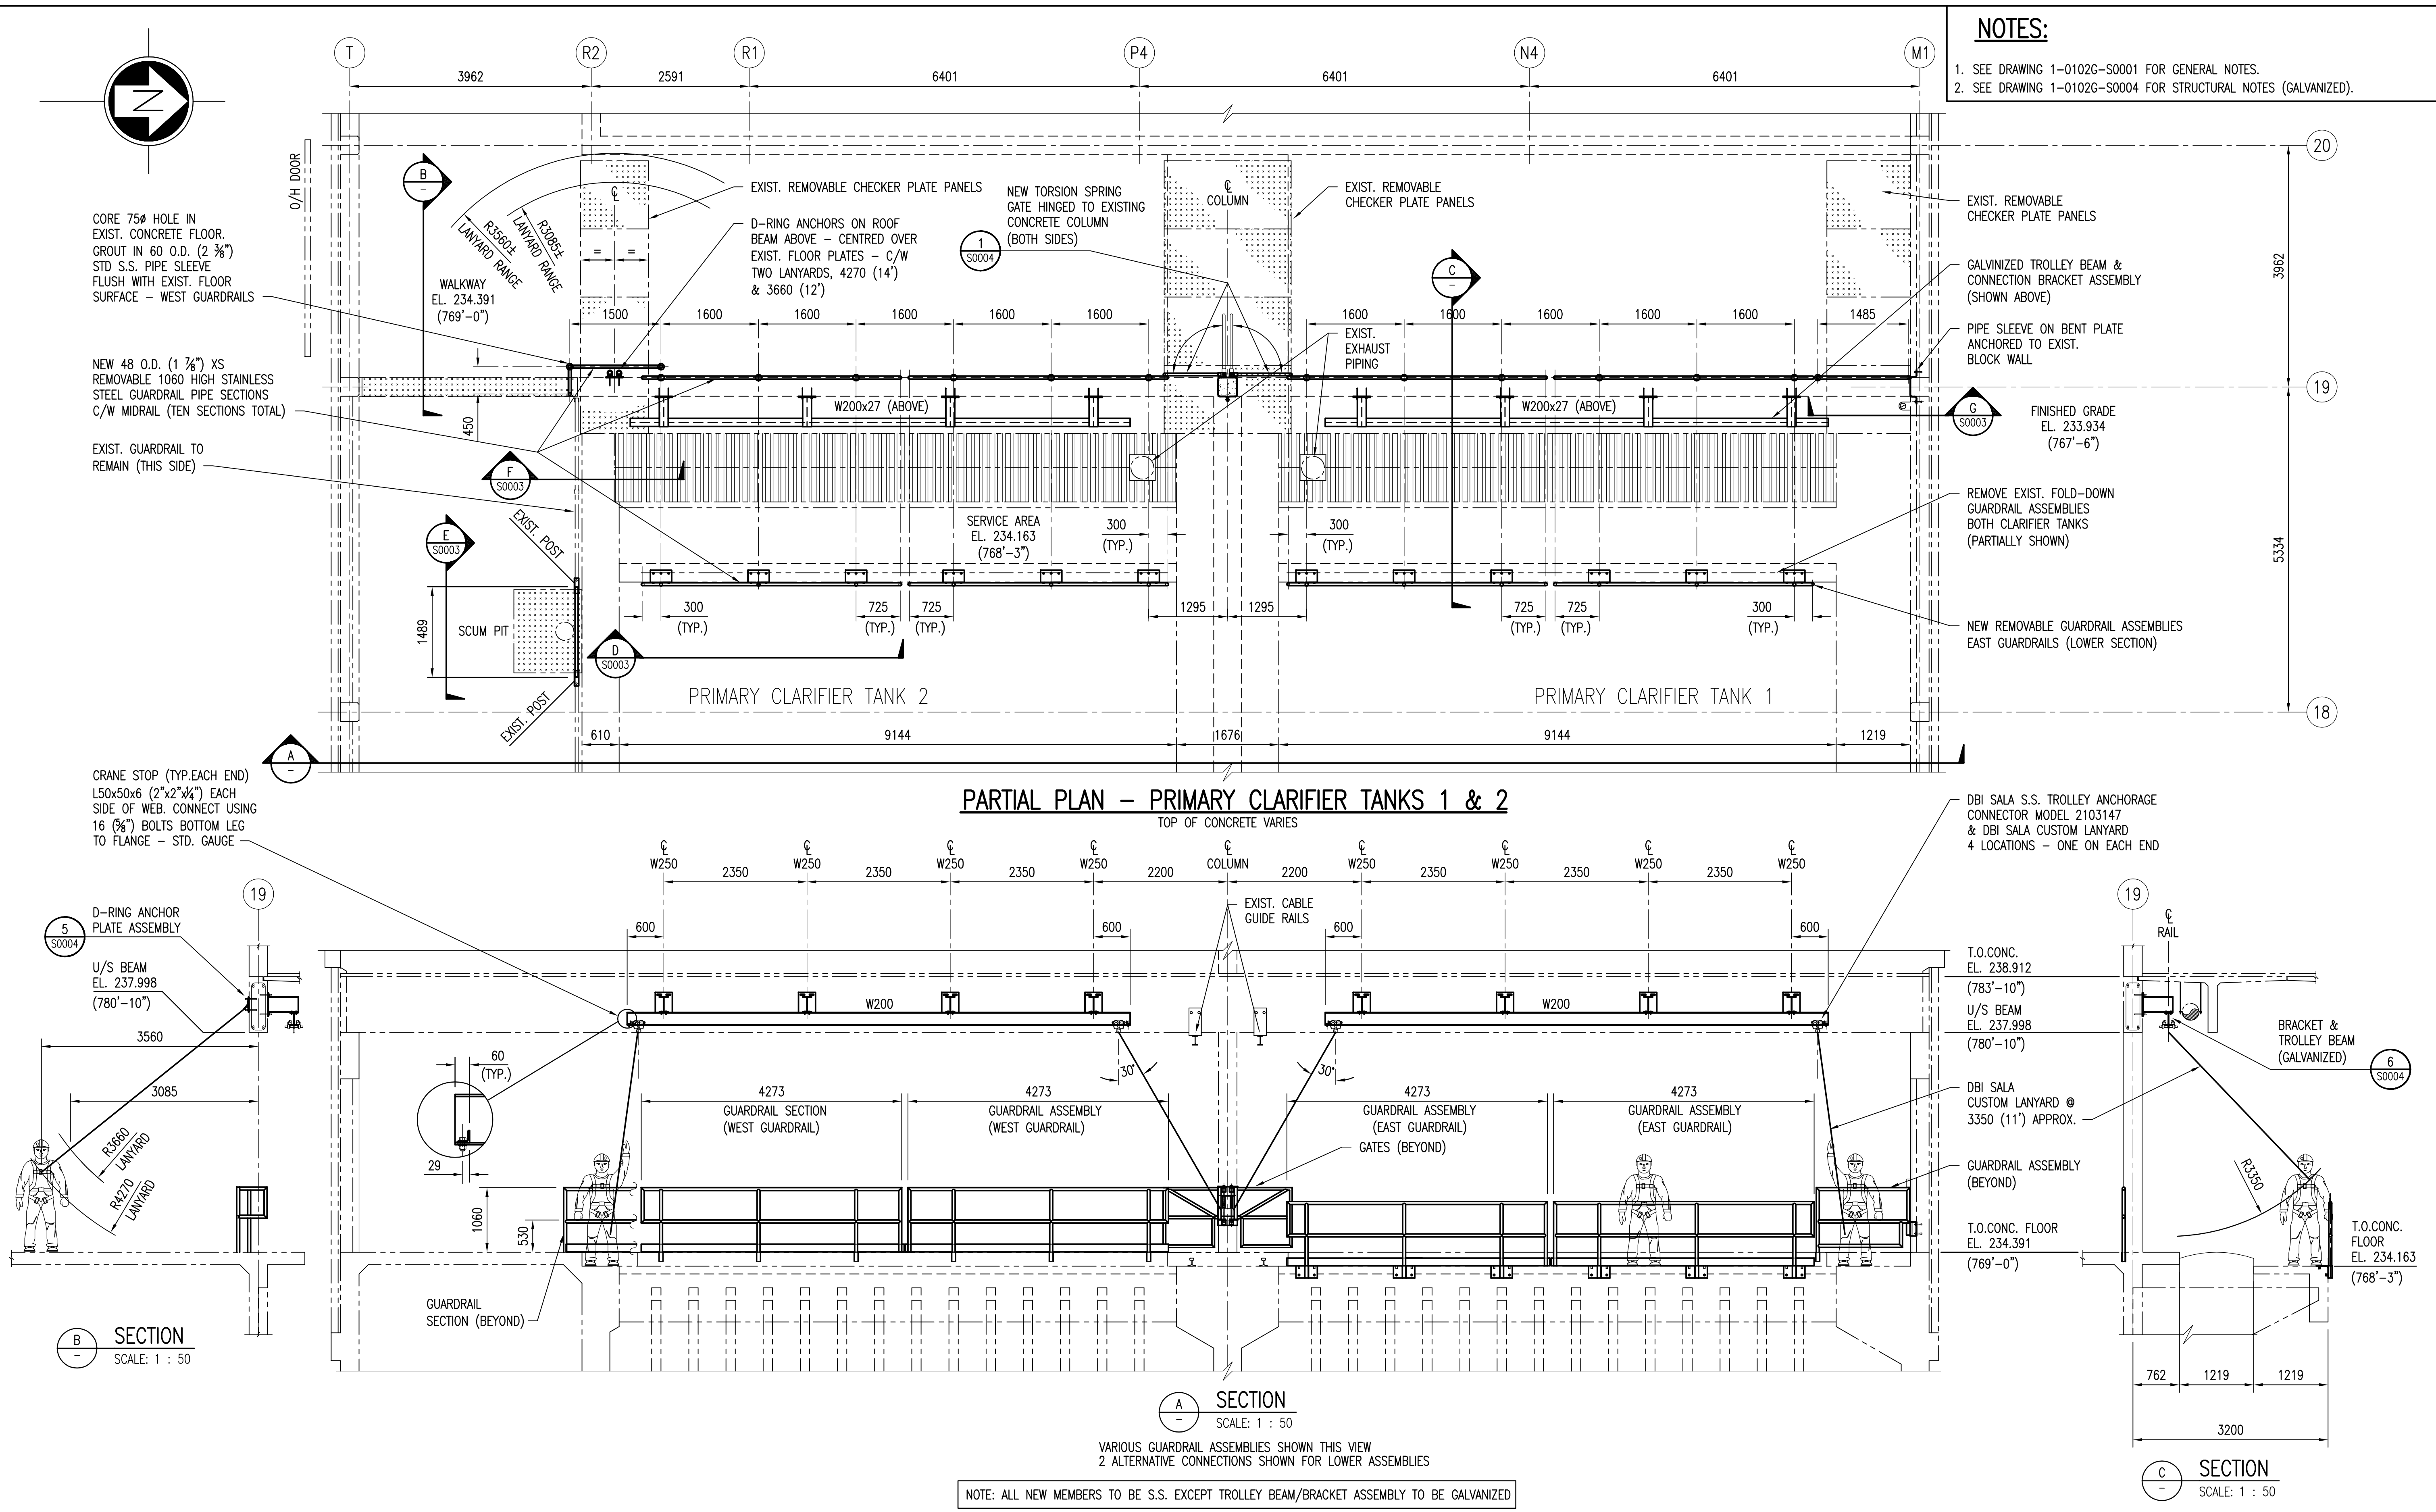

DRAWING NUMBER	REFERENCE DRAWINGS
SEP-59	PRIMARY CLARIFIER & SLUDGE PUMPING - SECTIONS
SEP-58	PRIMARY CLARIFIER & SLUDGE PUMPING - ROOF PLANS & SECTIONS
SEP-57	PRIMARY CLARIFIER & SLUDGE PUMPING, FLR. PLAN EL. 769' & 763'
1-0102P-S0004	PLAN & DETAILS - PRIMARY CLARIFIER 1 & 2 GUARDRAILS
1-0102P-S0003	SECTIONS & GEN. NOTES - PRIMARY CLARIFIER 1 & 2 GUARDRAILS

1 0 1 2 3m
1 : 50

APECM
Certificate of Authorization

SNC-Lavalin Inc.
No. 4489

THIS DRAWING

KEY PLAN
1:2500

NO.	REVISIONS	DATE	DESIGN	CHECK
0	RELEASED FOR TENDER	2010/05/21	B.F.D.	

SNC-LAVALIN INC.
148 Nature Park Way
Winnipeg, MB, Canada R3P 0X7
204-786-8080

DESIGNED BY: D. S. SIDHU
CHECKED BY: R. C. BEAN
DRAWN BY: B. DICKSON
APPROVED BY: C. J. REIMER
SCALE: 1:50
RELEASED FOR CONSTRUCTION BY: J. VILLEUX
DATE: 2009/12/21
DATE: 2010/05/25

CONSULTANT NO.: 112577-0114-42DD-0041

ENGINEER'S SEAL

ORIGINAL DRAWING
SEALED BY:
R. C. BEAN
SNC-LAVALIN
2010/05/21
REV. 0

THE CITY OF WINNIPEG
WATER AND WASTE DEPARTMENT

SOUTH END WATER POLLUTION CONTROL CENTRE
SAFETY UPGRADES
PLAN & SECTIONS
PRIMARY CLARIFIER 1 & 2 GUARDRAILS

CITY DRAWING NUMBER
1-0102P-S0002

SHEET
001

REV.
0

SIZE
A1

1-0102P-S0002-001-00.DWG