

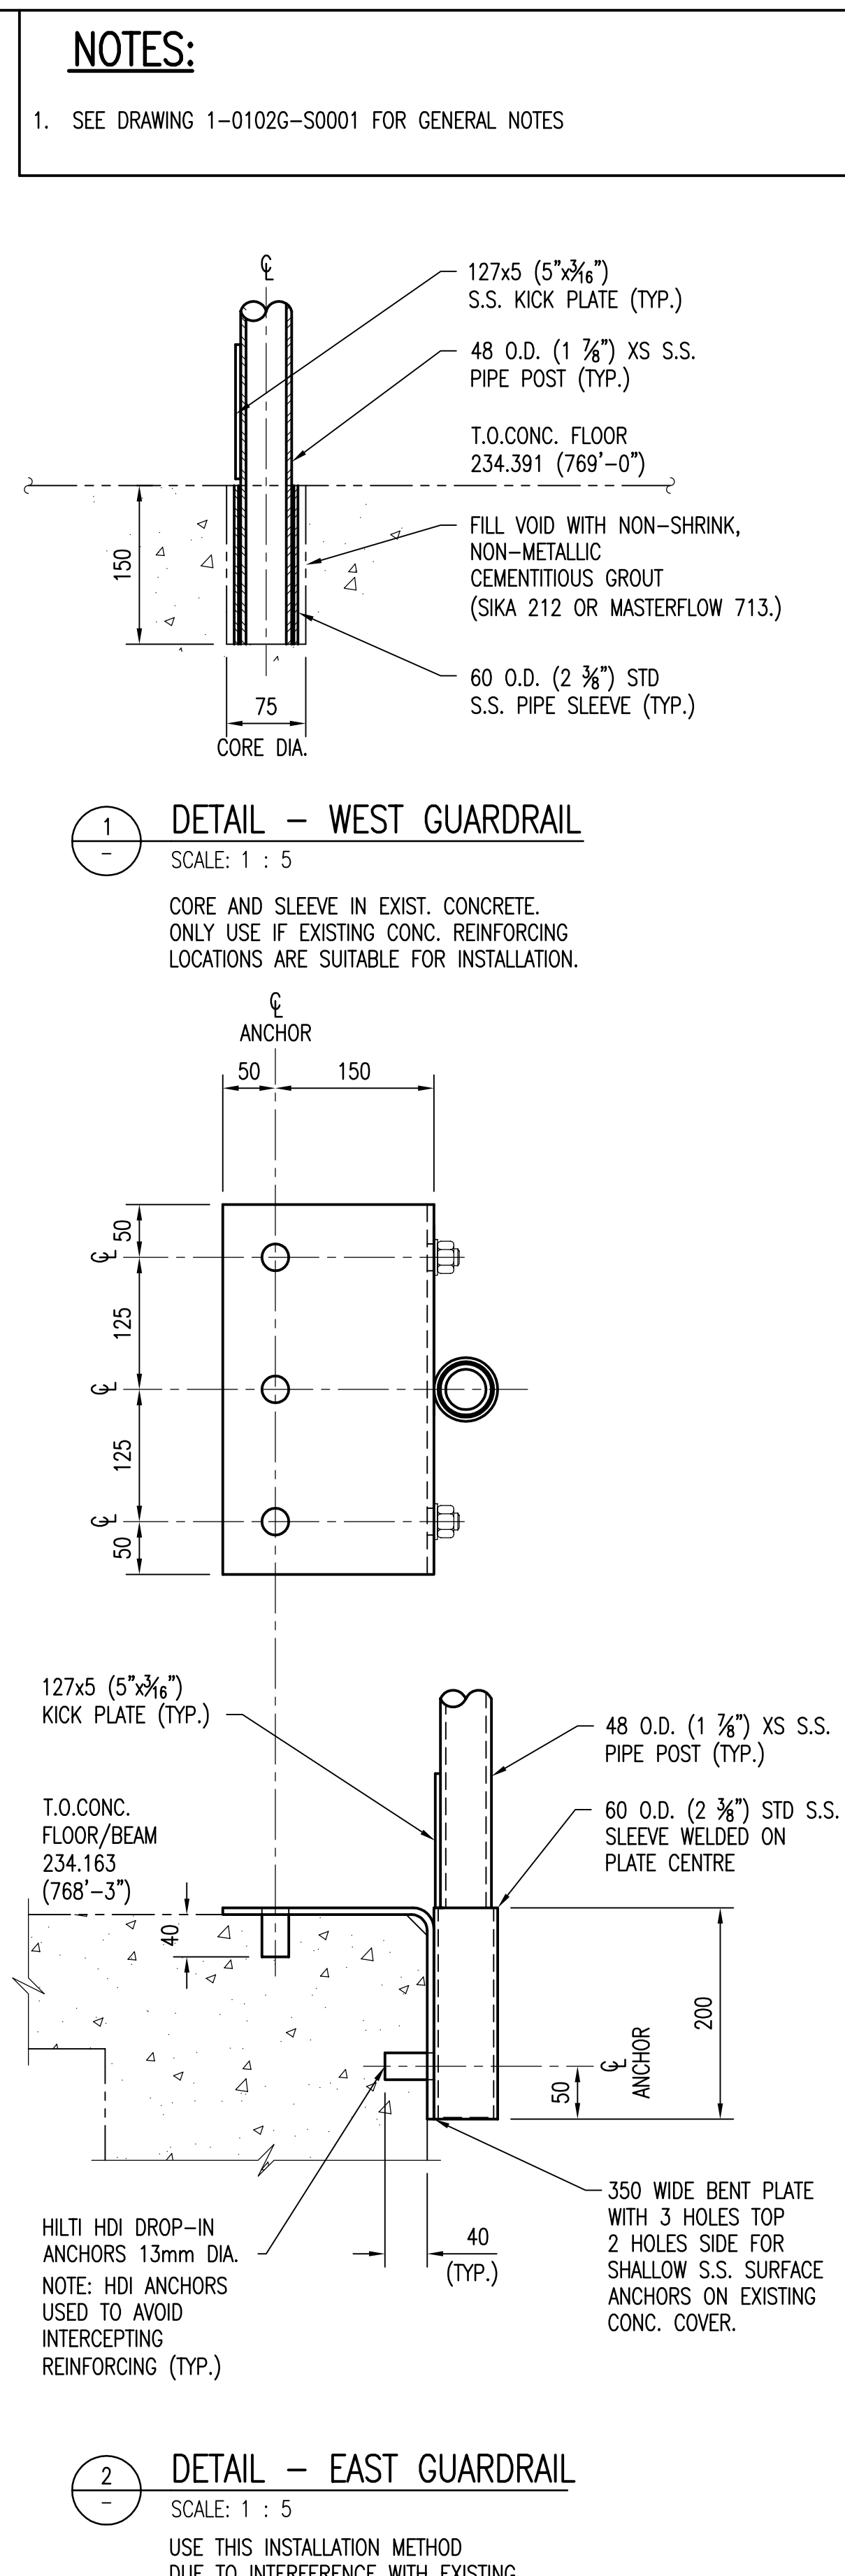
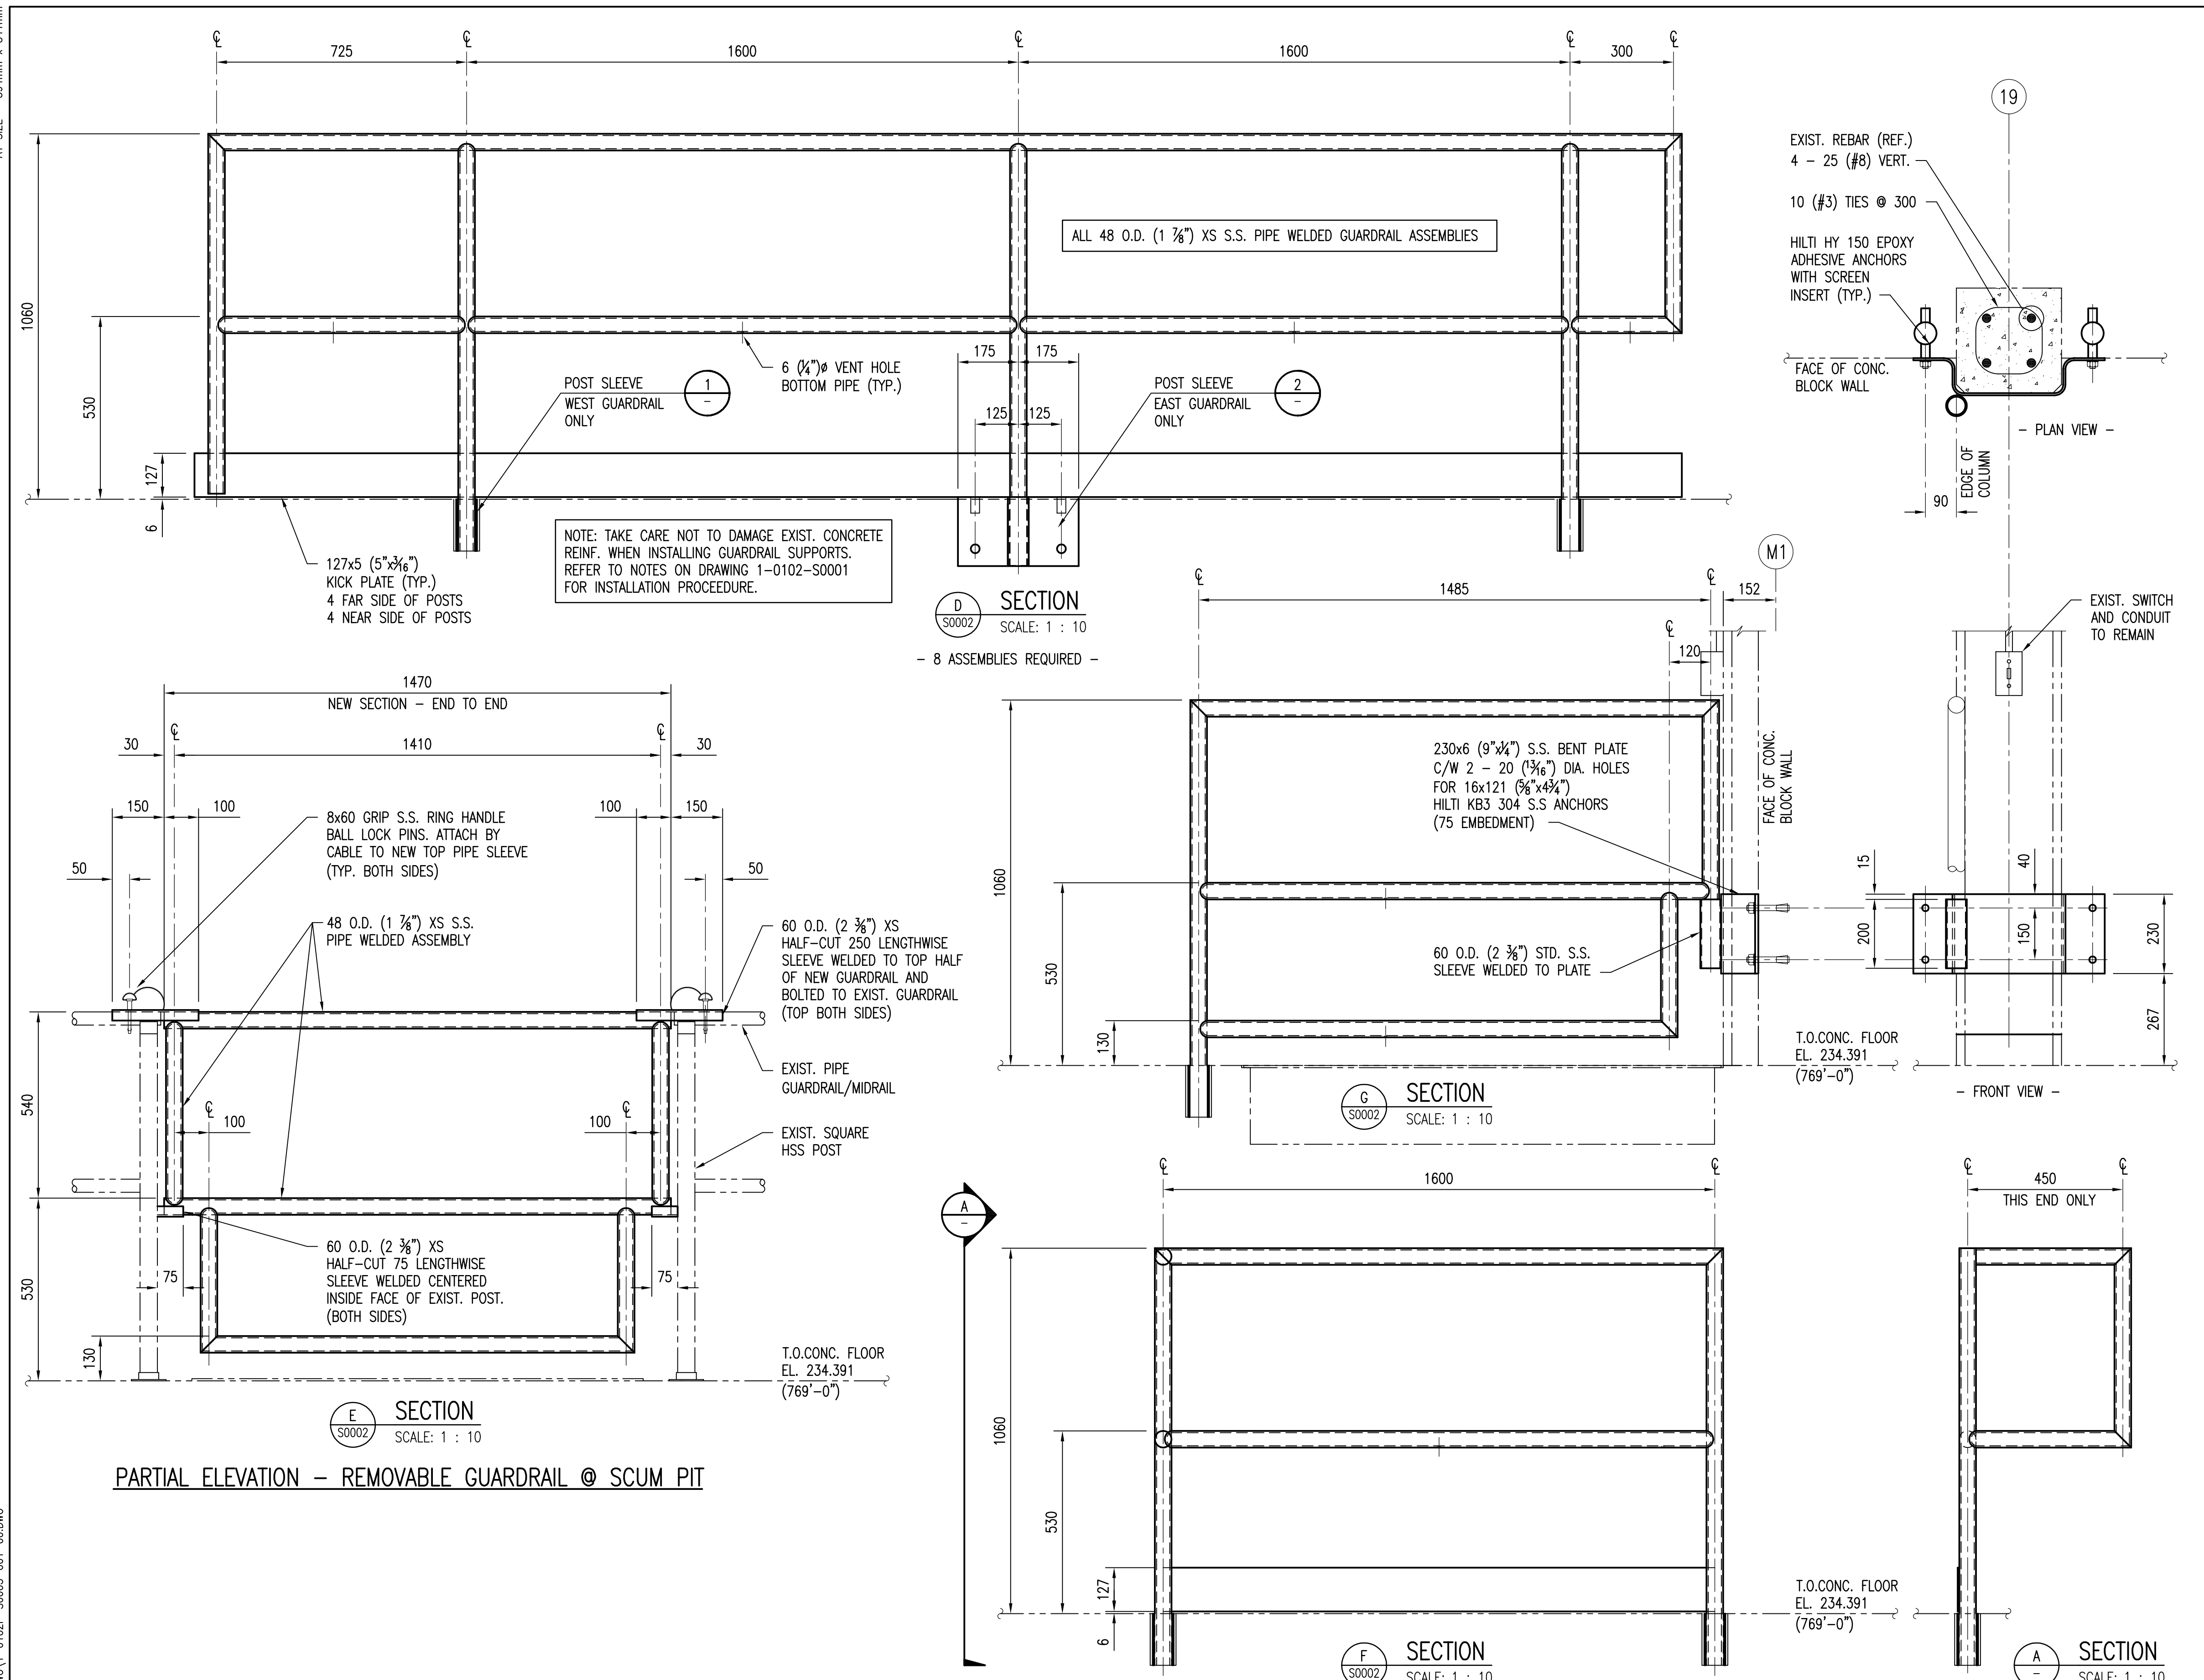


LAST SAVE: 2010/05/25 - 11:26am
PATH: M:\112577\0114\4ENG\425R\DO - General DWG\1-0102P-S0003-001-00.DWG

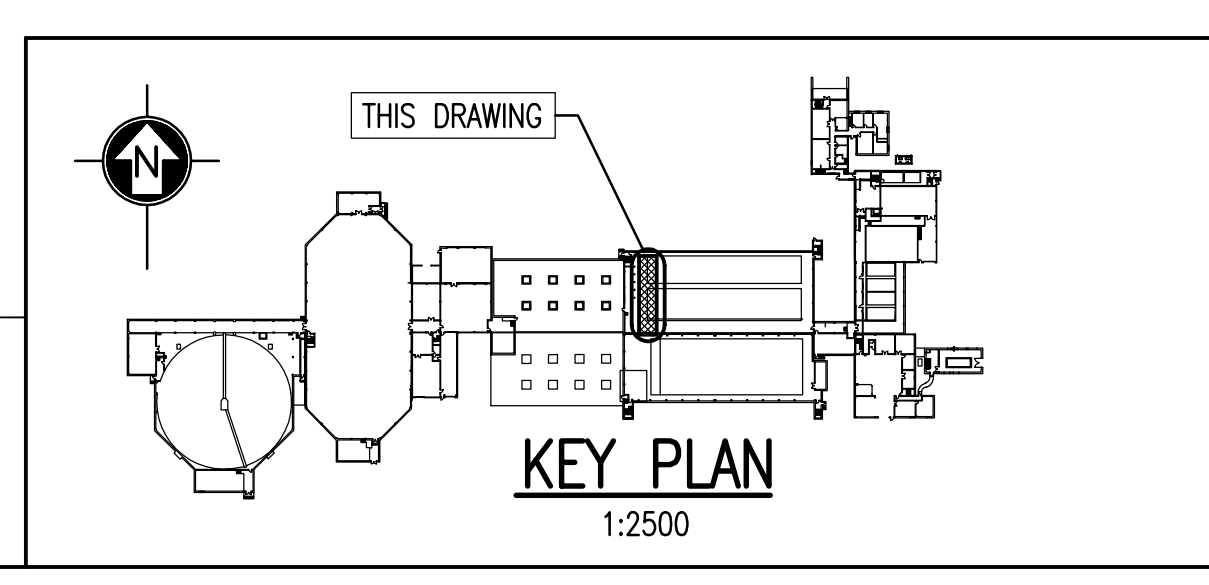

SEP-59	PRIMARY CLARIFIER & SLUDGE PUMPING - SECTIONS
SEP-58	PRIMARY CLARIFIER & SLUDGE PUMPING - ROOF PLANS & SECTIONS
SEP-57	PRIMARY CLARIFIER & SLUDGE PUMPING, FLR. PLAN EL. 769' & 763'
1-0102P-S0004	PLAN & DETAILS - PRIMARY CLARIFIER 1 & 2 GUARDRAILS
1-0102P-S0002	PLAN & SECTIONS - PRIMARY CLARIFIER 1 & 2 GUARDRAILS
DRAWING NUMBER	REFERENCE DRAWINGS

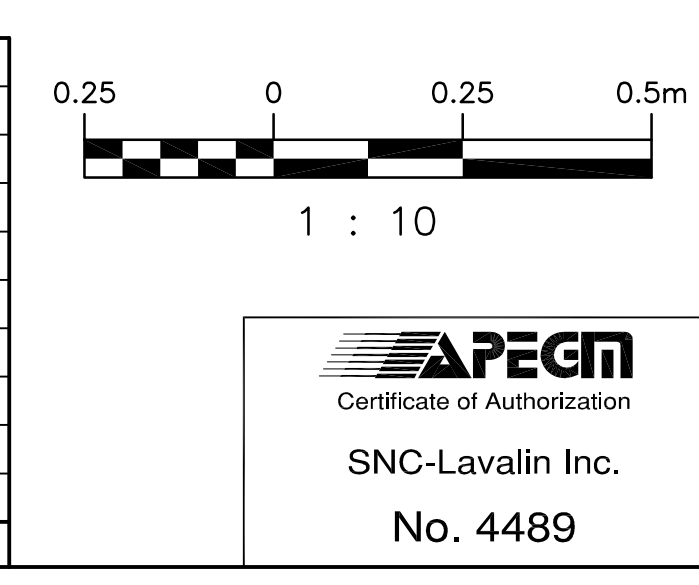

DESIGNED BY:	D. S. SIDHU	CHECKED BY:	R. C. BEAN
DRAWN BY:	B. DICKSON	APPROVED BY:	C. J. REIMER
SCALE:	1:5, 1:10	RELEASED FOR CONSTRUCTION BY:	J. VEILLEUX
DATE:	2009/12/21	DATE:	2010/05/25
CONSULTANT NO.:	112577-0114-42DD-0042		
NO.	REVISIONS	DATE	DESIGN CHECK
0	RELEASED FOR TENDER	2010/05/21	B.F.D.

ENGINEER'S SEAL	ORIGINAL DRAWING SEALED BY: R. C. BEAN SNC-LAVALIN 2010/05/21 REV. 0	THE CITY OF WINNIPEG WATER AND WASTE DEPARTMENT SOUTH END WATER POLLUTION CONTROL CENTRE SAFETY UPGRADES SECTIONS & DETAILS PRIMARY CLARIFIER 1 & 2 GUARDRAILS
CITY DRAWING NUMBER	1-0102P-S0003	SHEET 001
REV.	0	SIZE A1