
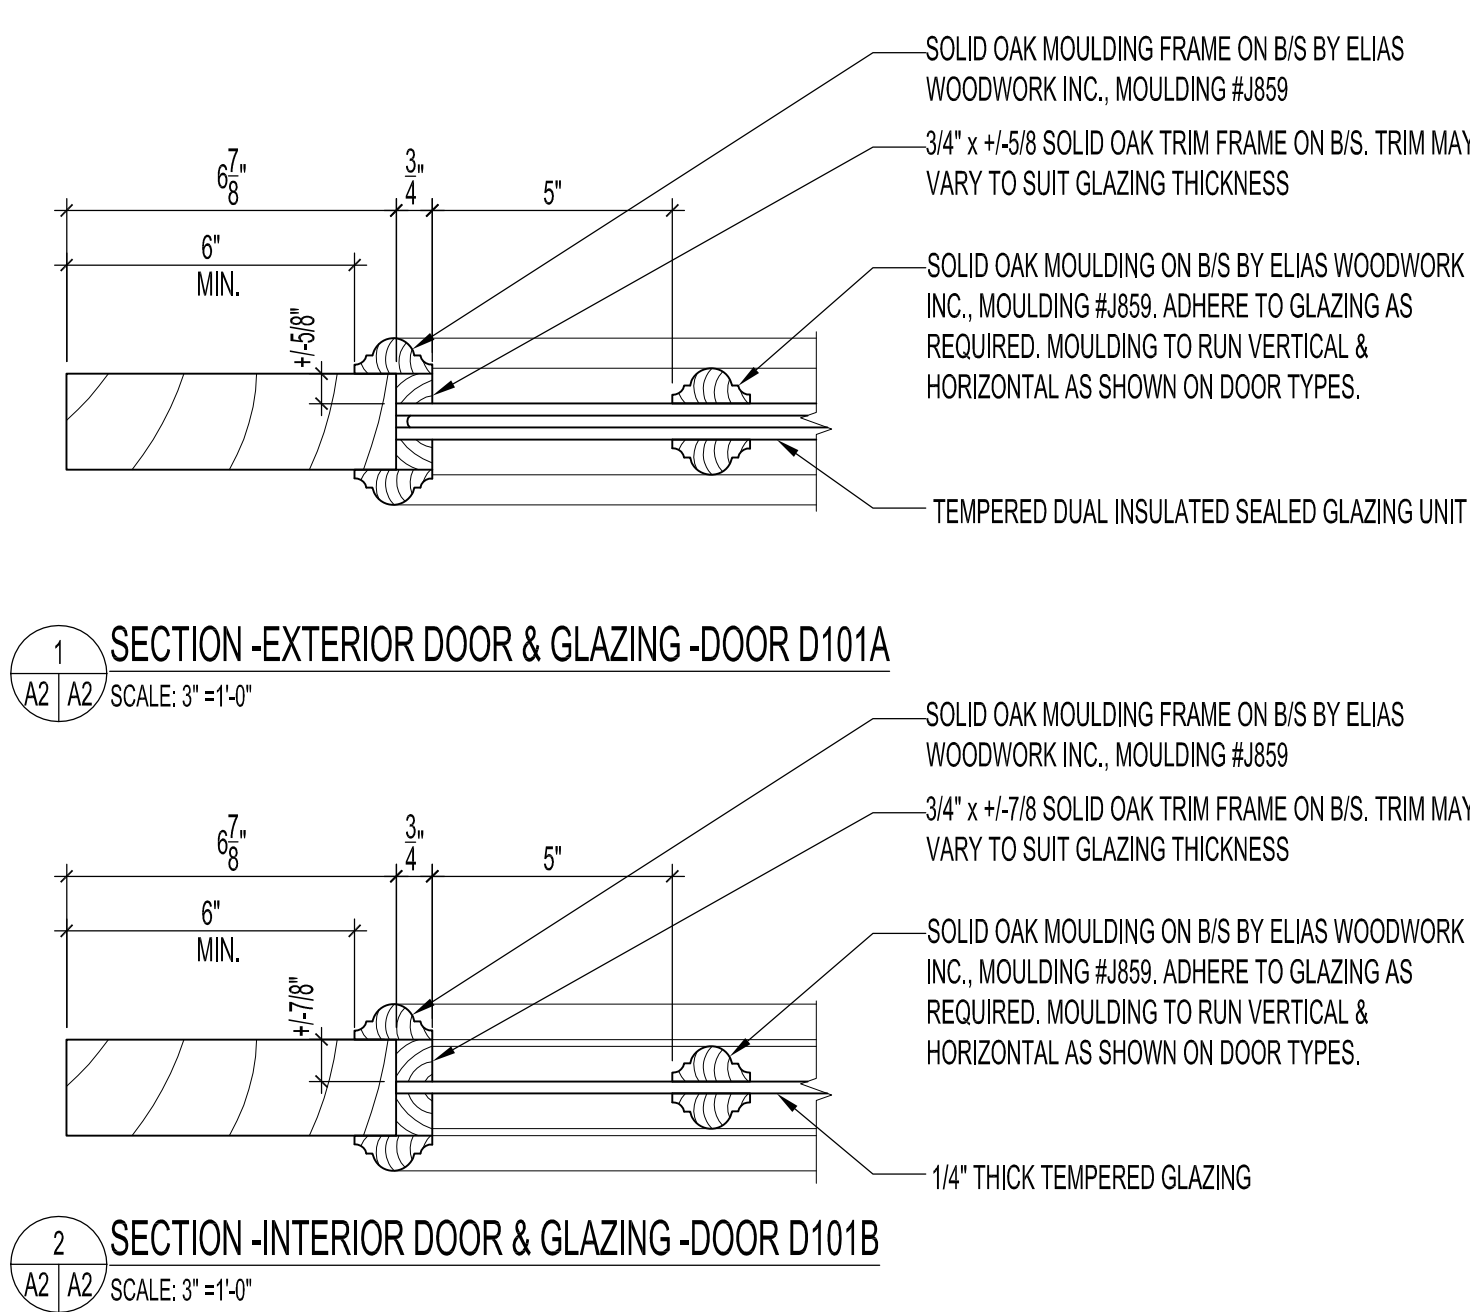


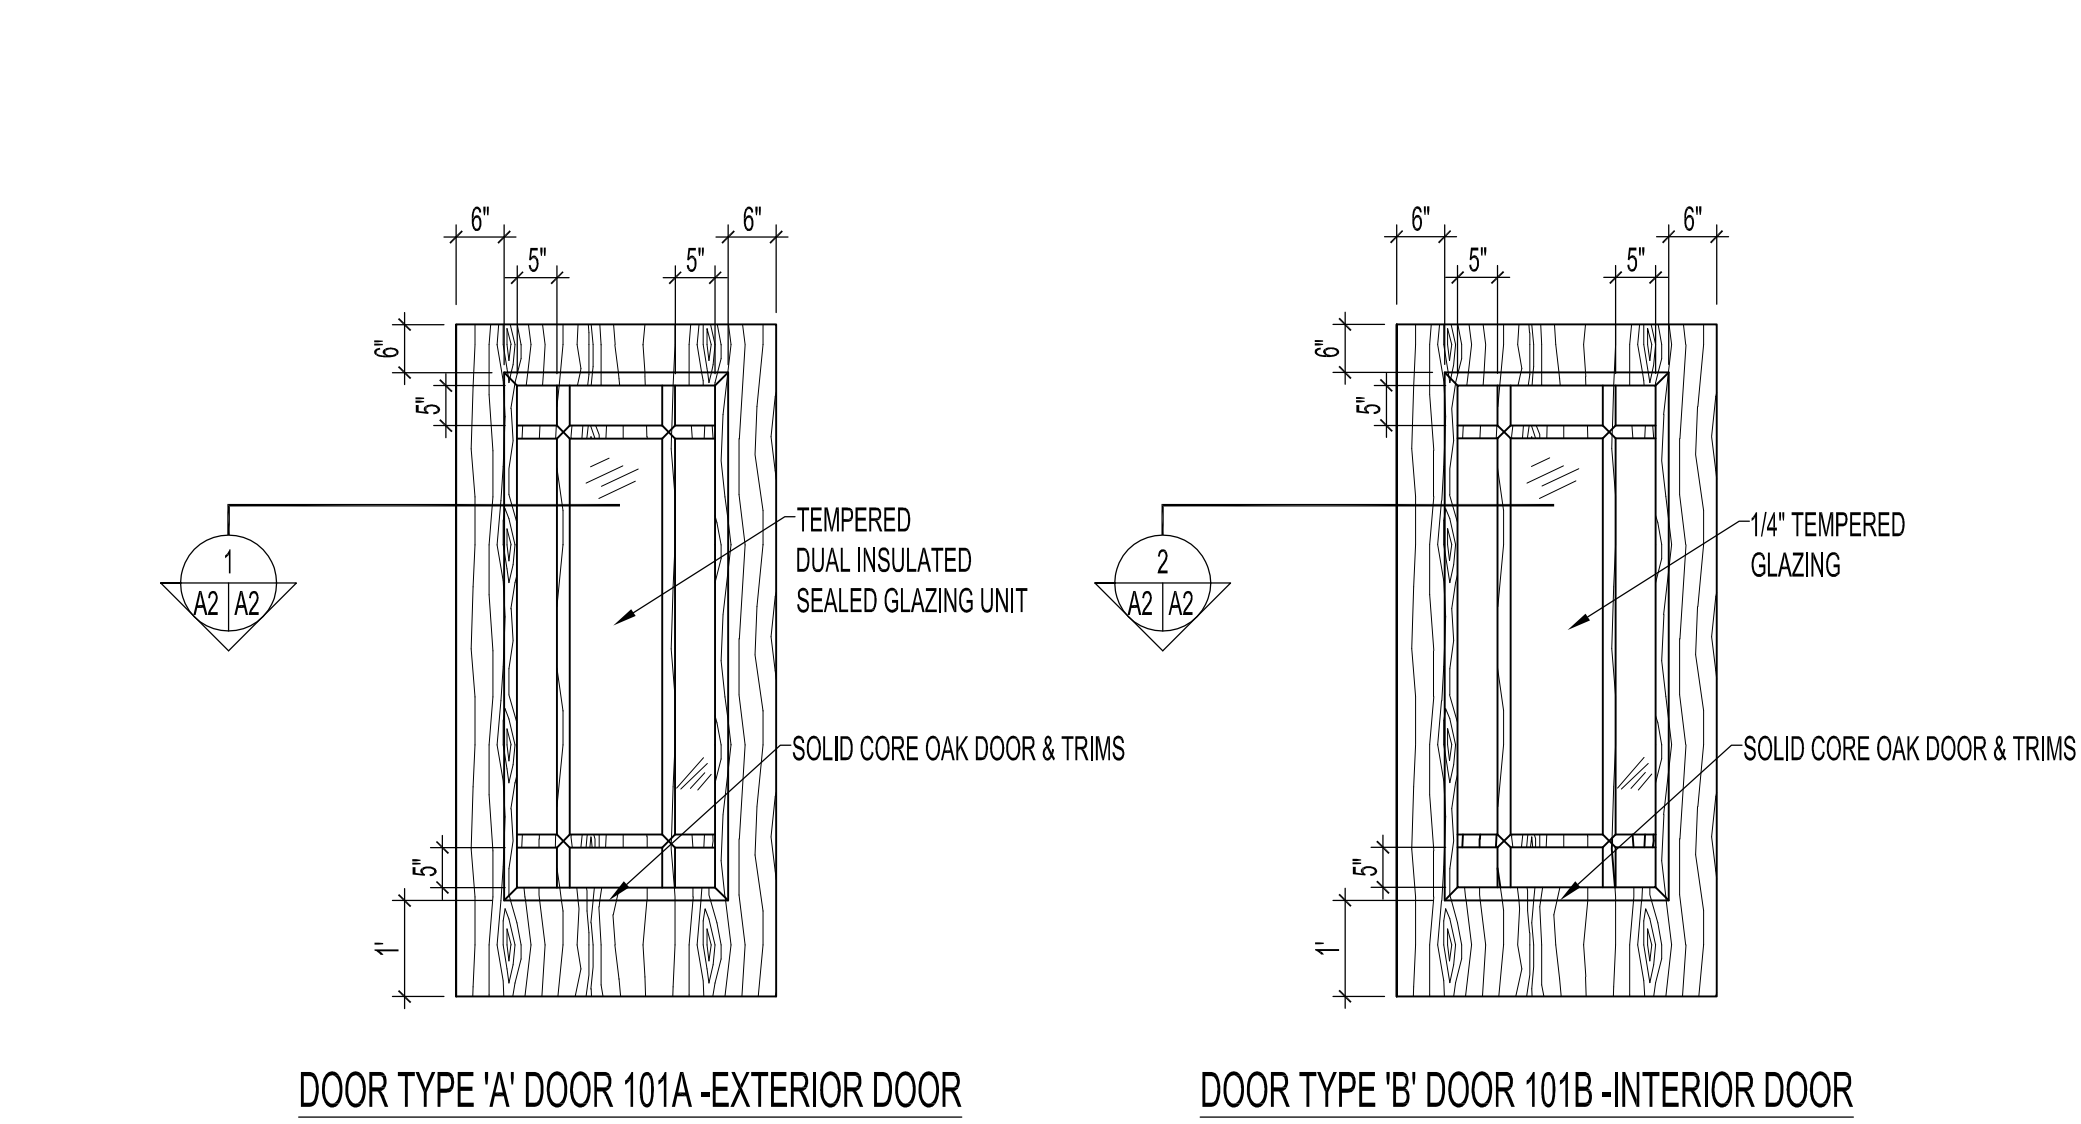

DOOR SCHEDULE									
DOOR NO.	DOOR TYPE	DOOR			FRAME			RATING	HARDWARE GROUP & CODES
		WIDTH	HEIGHT	THICK.	MATL.	FINISH	TYPE		
D101A	A	3'-4" x +1-7'-0"	2 1/4"		S.WD.	ST.	A	S.WD.	ST.
D101B	B	3'-4" x +1-7'-0"	1 3/4"		S.WD.	ST.	B	S.WD.	ST.

ABBREVIATIONS: S.WD. - OAK WOOD WITH SOLID CORE WOOD, ST. - STAIN, 2 COATS WALNUT & 4 COATS OF CLEAR POLYURETHANE SATIN FINISH W/ ULTRA VIOLET (U.V.) PROTECTION.


NOTES :
ALSO SEE NOTES ON DRAWING A1 & SPECIFICATIONS

HARDWARE CODES:

- 1A DOOR WEATHERSTRIPPING SET - A.K. DRAFT SEAL LTD, DS130D
- 2A DOOR BOTTOM SWEEP - A.K. DRAFT SEAL LTD, DS138D
- 3A THRESHOLD - A.K. DRAFT SEAL LTD, DS500D
- 4A RIM CYLINDER - BEST, 1E72, 613.
- 5A MORTISE CYLINDER - BEST, 1E74, 613.
- 6A HINGES - STANLEY 2PR, 4 1/2 x 4 #CB179 108 FINISH
- 7A KICKPLATES - IVES - 8400, 10" x 36" 613 FINISH (BOTH SIDES OF DOOR)
- 8A AUTOMATIC POWER DOOR OPERATOR (LOW-ENERGY DOOR OPERATOR - PUSH SIDE MOUNT), LCN 4642, 695.
- 8B AUTOMATIC POWER DOOR OPERATOR (LOW-ENERGY DOOR OPERATOR - PULL SIDE MOUNT), LCN 4631, 695.
- 9A PULL & PUSH PLATE - IVES, 8200, 4" X 16", 613.
- 9B PULL & PUSH PLATE - STANDARD METAL ARCHITECTURAL HARDWARE (SMH), DP562, 613, BACKPLATE CUT OUT FOR CYLINDER.
- 10A 6" Ø YELLOW & BLACK "CAUTION AUTOMATIC DOOR" STICKERS, DOUBLE-SIDED VINYL ADHESIVE
- 11A PANIC HARDWARE - VON DUPRIN, SD-LX-QEL987NL-OP, 710.
- 12A ELECTRIC STRIKE TO SUIT DOOR & ELECTRICAL SEQUENCE OF OPERATION, SEE ELECTRICAL DRAWING.





DOOR HARDWARE FINISHES

ALL DOOR HARDWARE TO HAVE 613, 10B (U.S.A.) FINISH
SATIN BRONZE ANODIZED -OIL RUBBED BRONZE

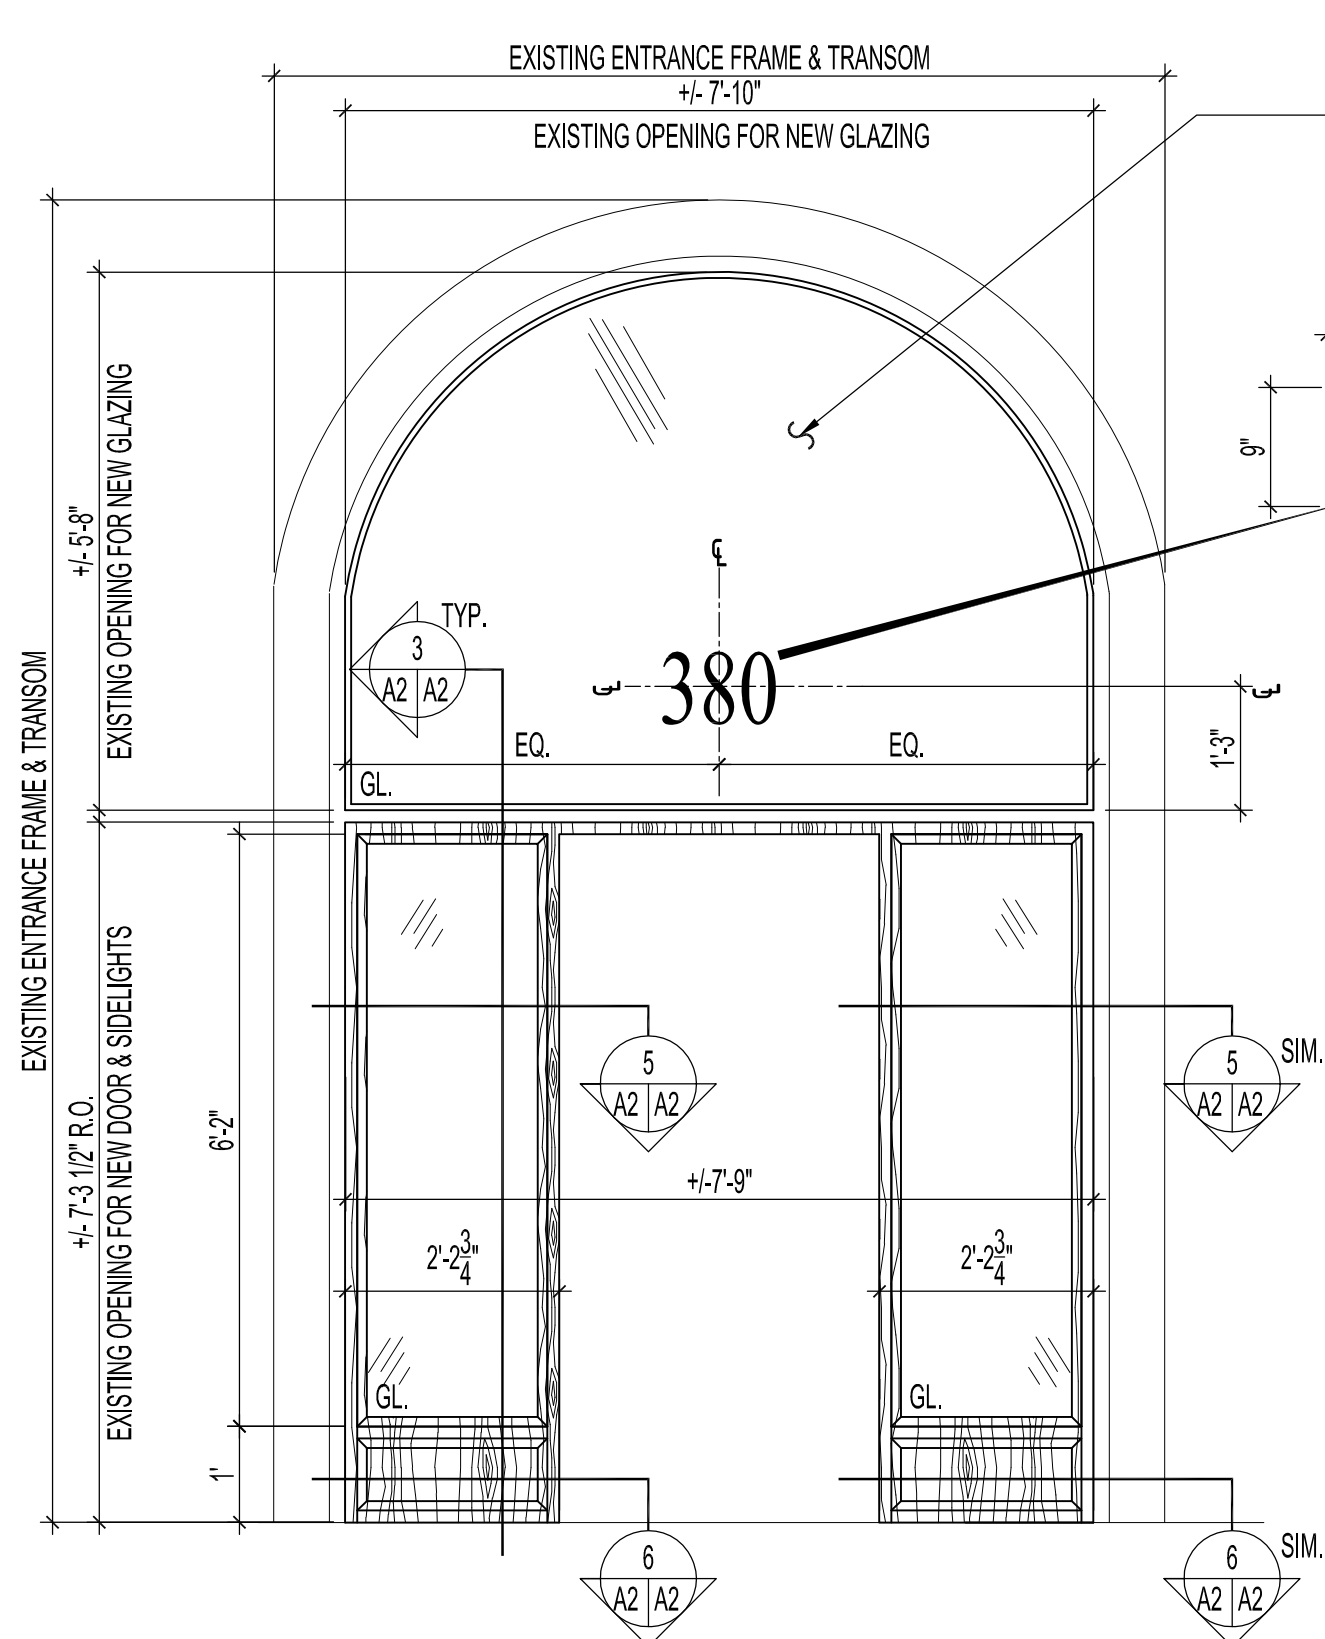

GLAZING DEMOLITION: REMOVE EXISTING GLAZING TRIM & SALVAGE OR REPLACE AS REQUIRED. REMOVE & DISCARD EXISTING CURVED GLAZING PANELS.
GLAZING REPLACEMENT: SUPPLY & INSTALL NEW DUAL INSULATED SEALED TEMPERED GLAZING TRANSOM TO EXISTING OPENING. RE-USE EXISTING GLAZING STOPS OR SUPPLY AND INSTALL MATCHING OR SIMILAR PAINT GRADE STOPS FOR NEW PANEL.

380
SUPPLY & INSTALL NEW WHITE VINYL ADHESIVE NUMBERS, TIMES NEW ROMAN FONT, INSTALLED ON INTERIOR OF ENTRANCE DOOR TRANSOM.

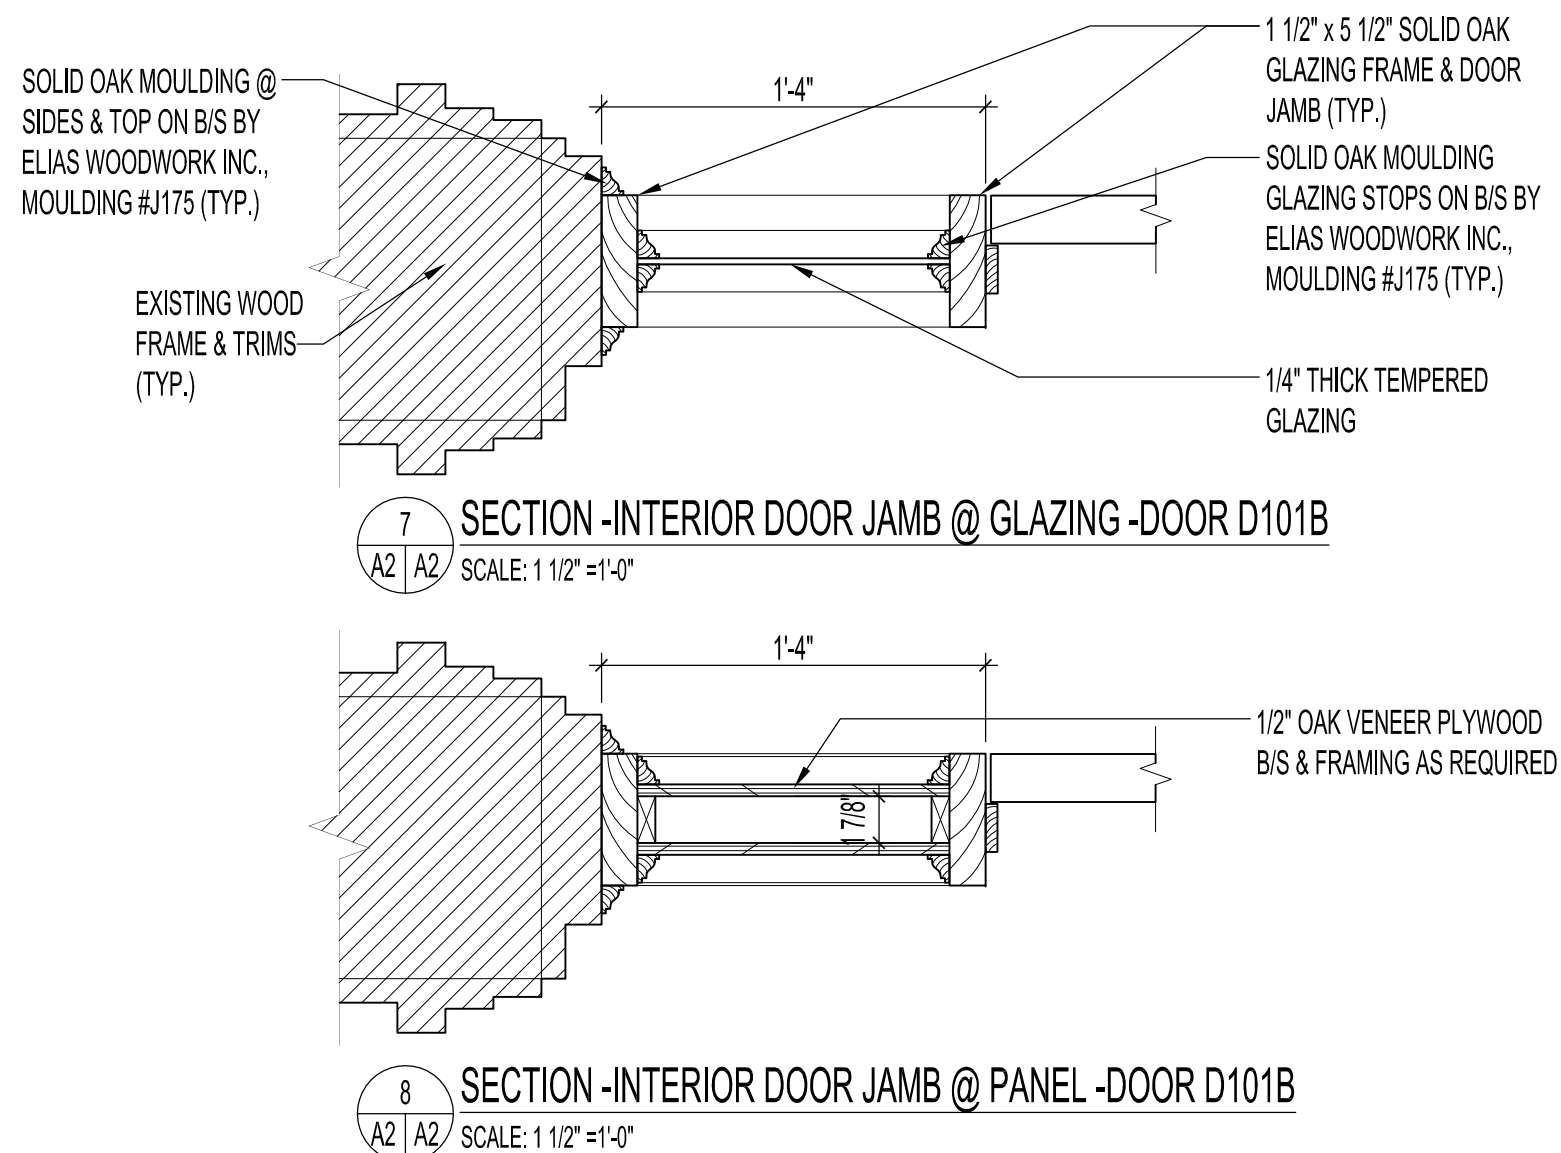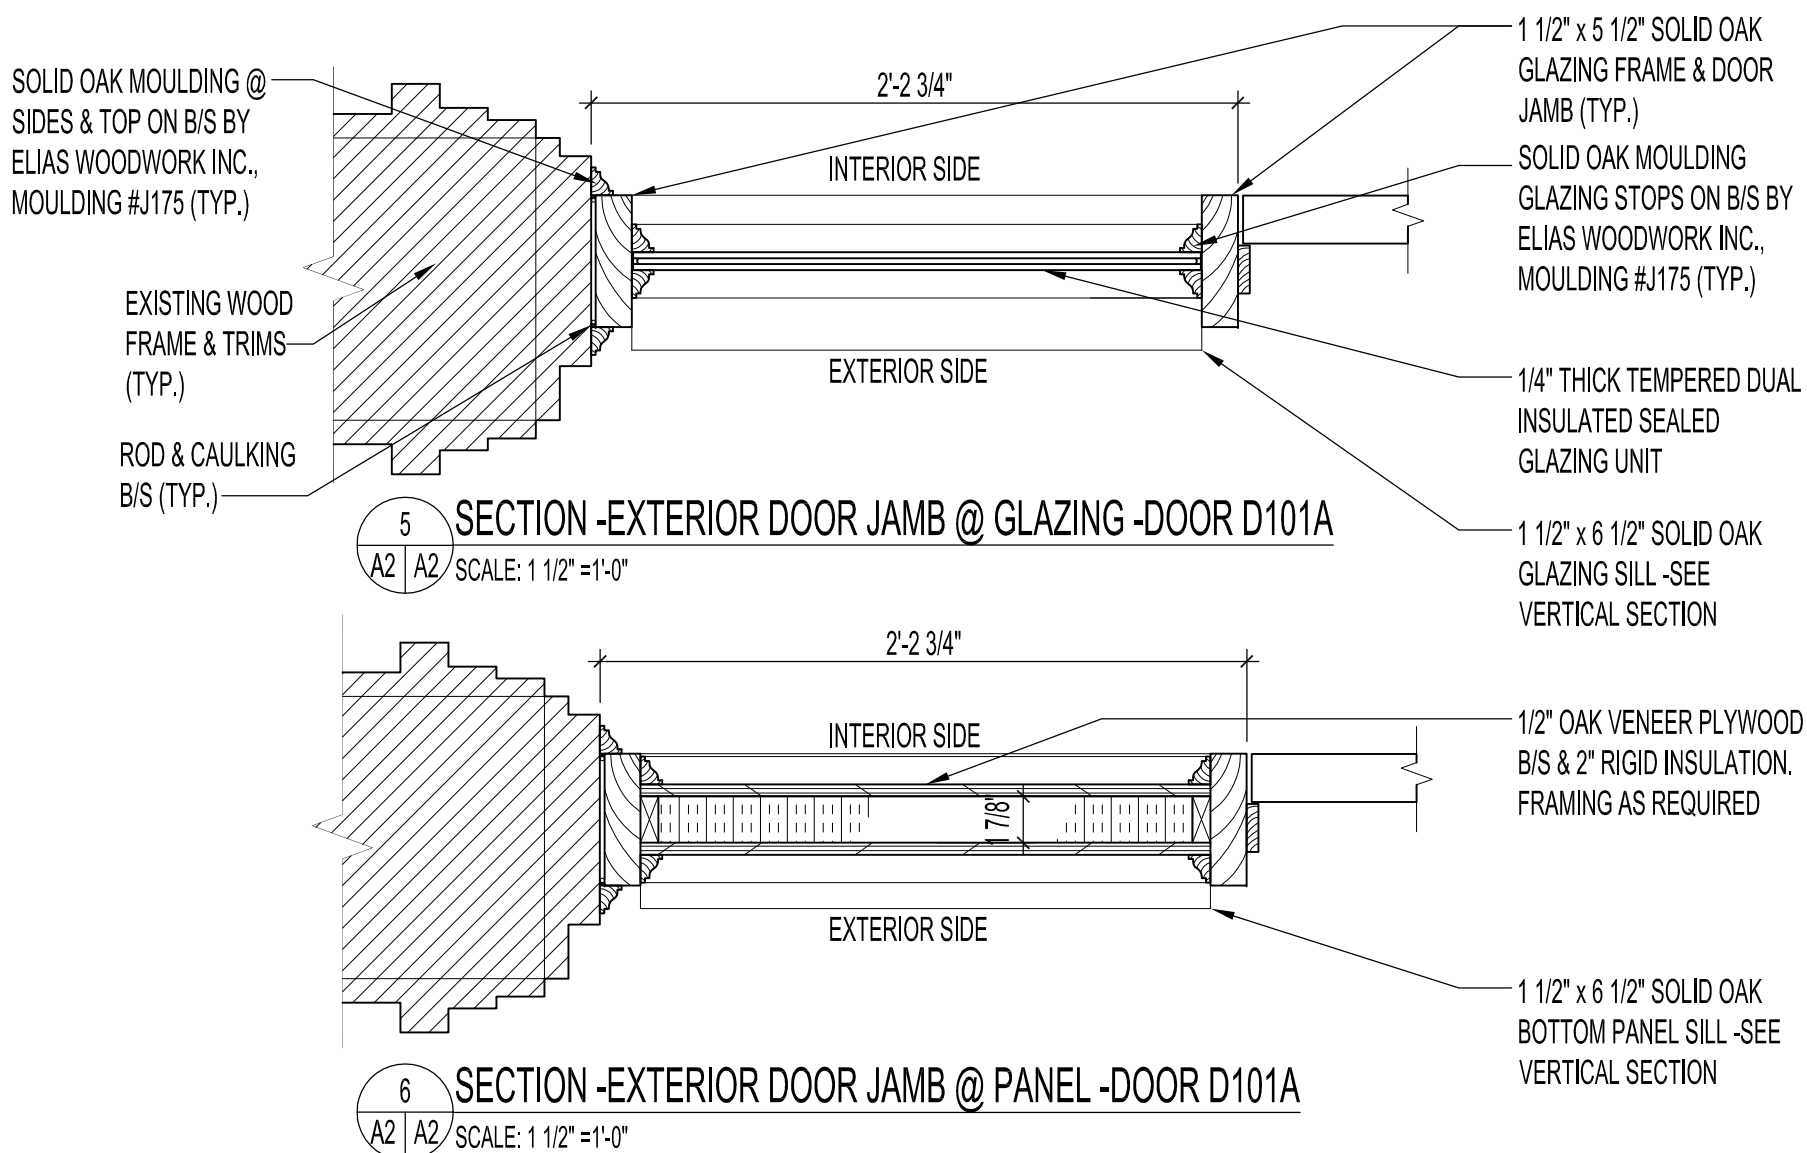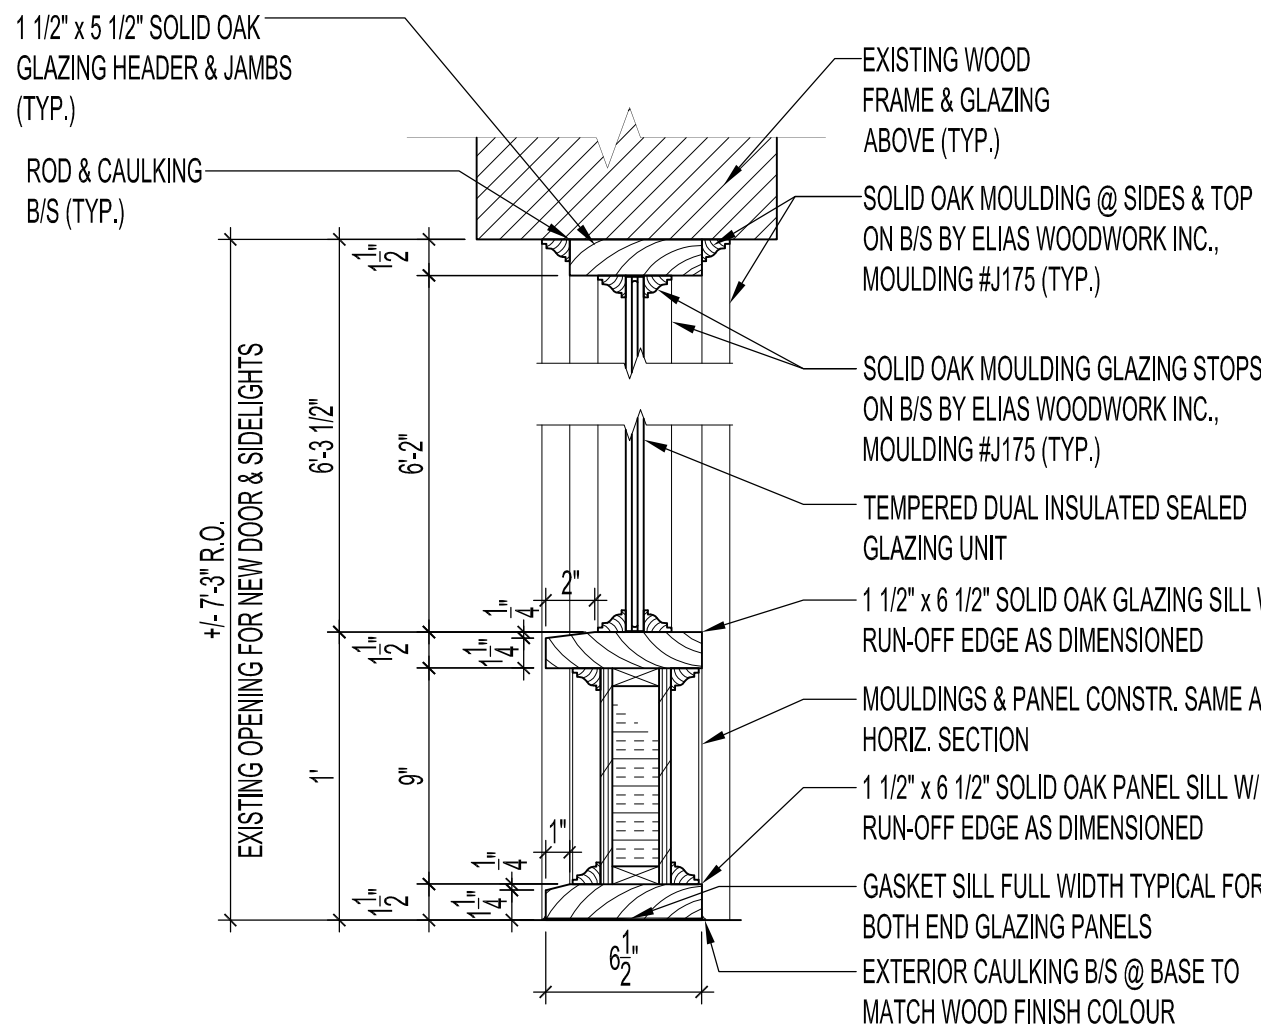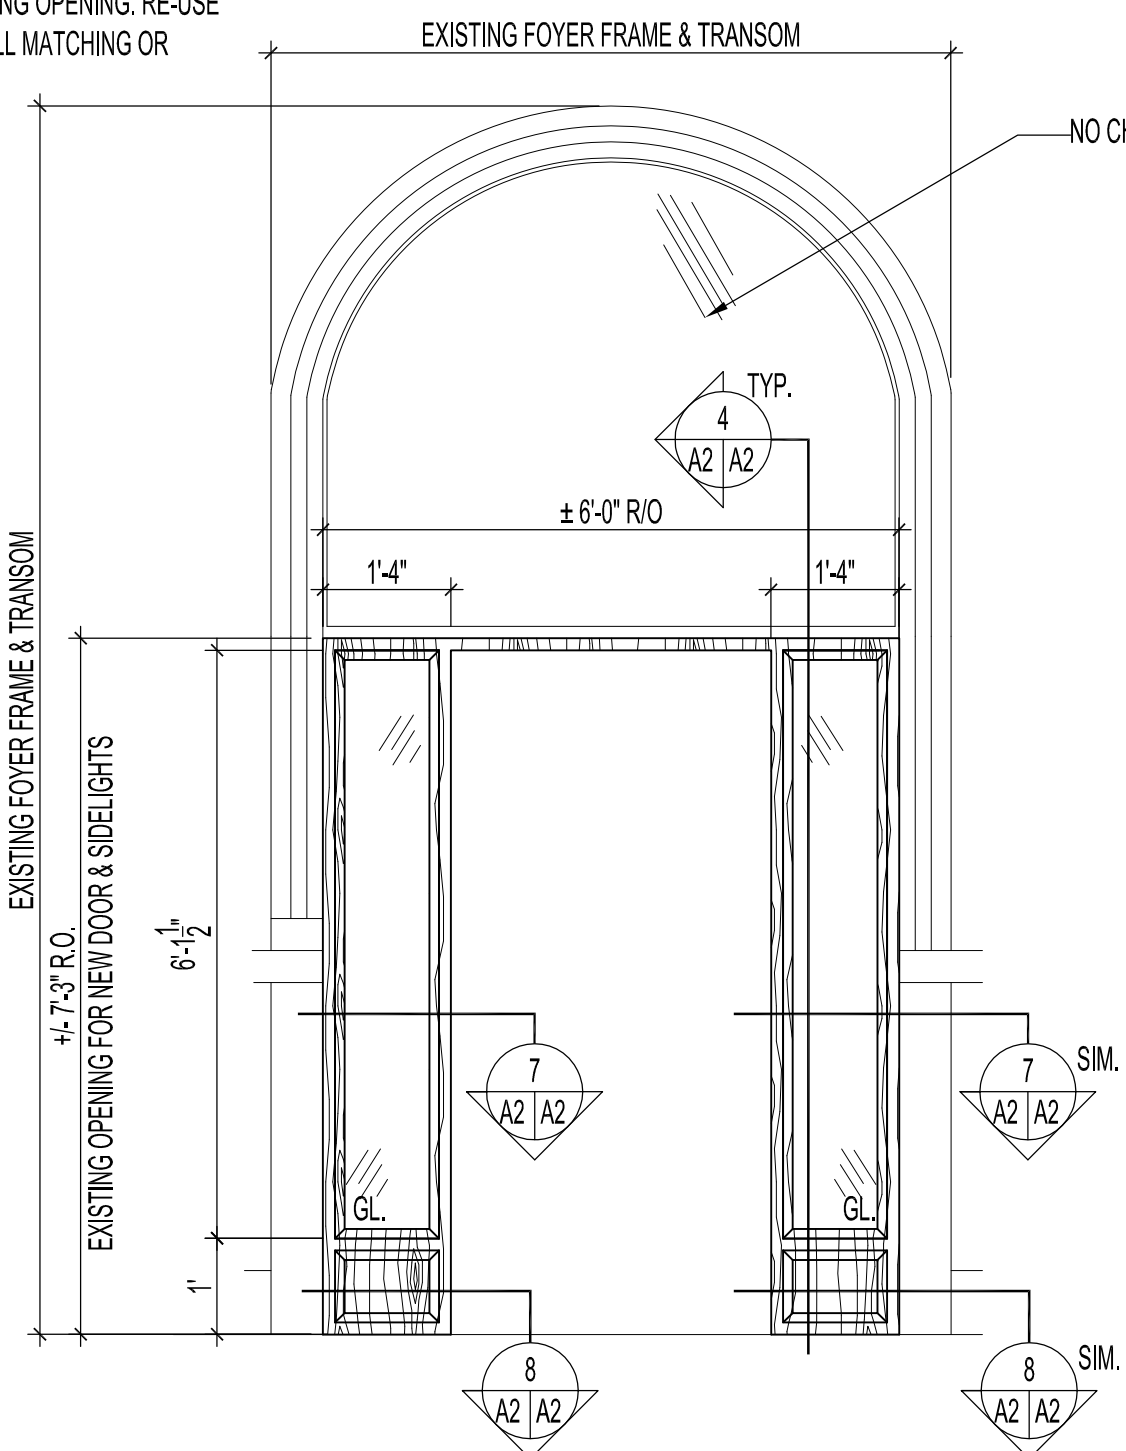

SECTION -EXTERIOR GLAZING & PANEL -DOOR D101A
SCALE: 1 1/2" =1'-0"

SECTION -INTERIOR GLAZING & PANEL -DOOR D101B
SCALE: 1 1/2" =1'-0"

NO.	REVISION/DESCRIPTION	BY	DATE
SEALS			

DRAWN BY	CHECKED BY	APPROVED
DATE	USER APPROVAL	

CITY OF WINNIPEG
PLANNING, PROPERTY AND
DEVELOPMENT DEPARTMENT
MUNICIPAL ACCOMMODATIONS DIVISION
300 - 65 GARRY ST. R3C 4K4

PROJECT
ARCHIVES BUILDING
INTERIOR RENOVATIONS
& BARRIER FREE LIFT INSTALLATION
380 WILLIAM AVENUE

SHEET TITLE
DOOR & FRAME TYPES,
DOOR SCHEDULE & DETAILS

SCALE	PROJECT NO.	SHEET NO.
AS SHOWN	2008-079-03	A2