 




Structural floor plan of the second floor, showing a grid of columns (1-6) and beams (A-Z). The plan includes dimensions for beams and columns, reinforcement details (e.g., B502, B504, B501), and notes on concrete walls and stairs. A note indicates "SEE PLAN AT ELEV. 770'-0" FOR DETAILS OF THIS AREA". The plan also shows a "PUMP & SCREEN" area on the left side.

PUMP & SCREEN

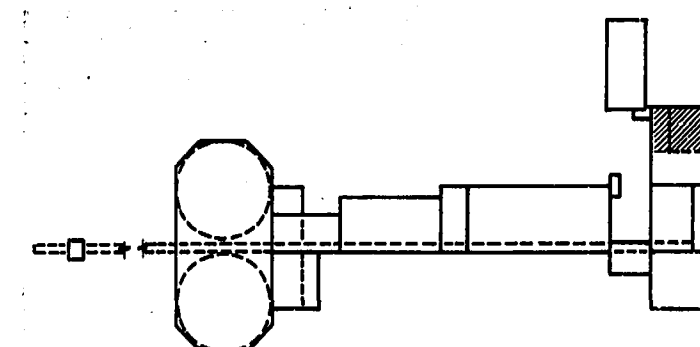

NOTE:
— THESE BMS. SUPPLIED BY
ELEVATOR SUPPLIER, SEE ELEV.
SUPPLIER SHOP DWGS. FOR
REQ'D POCKETS & INSERTS ETC.
BEFORE POURING WALLS & TOP SLAB.

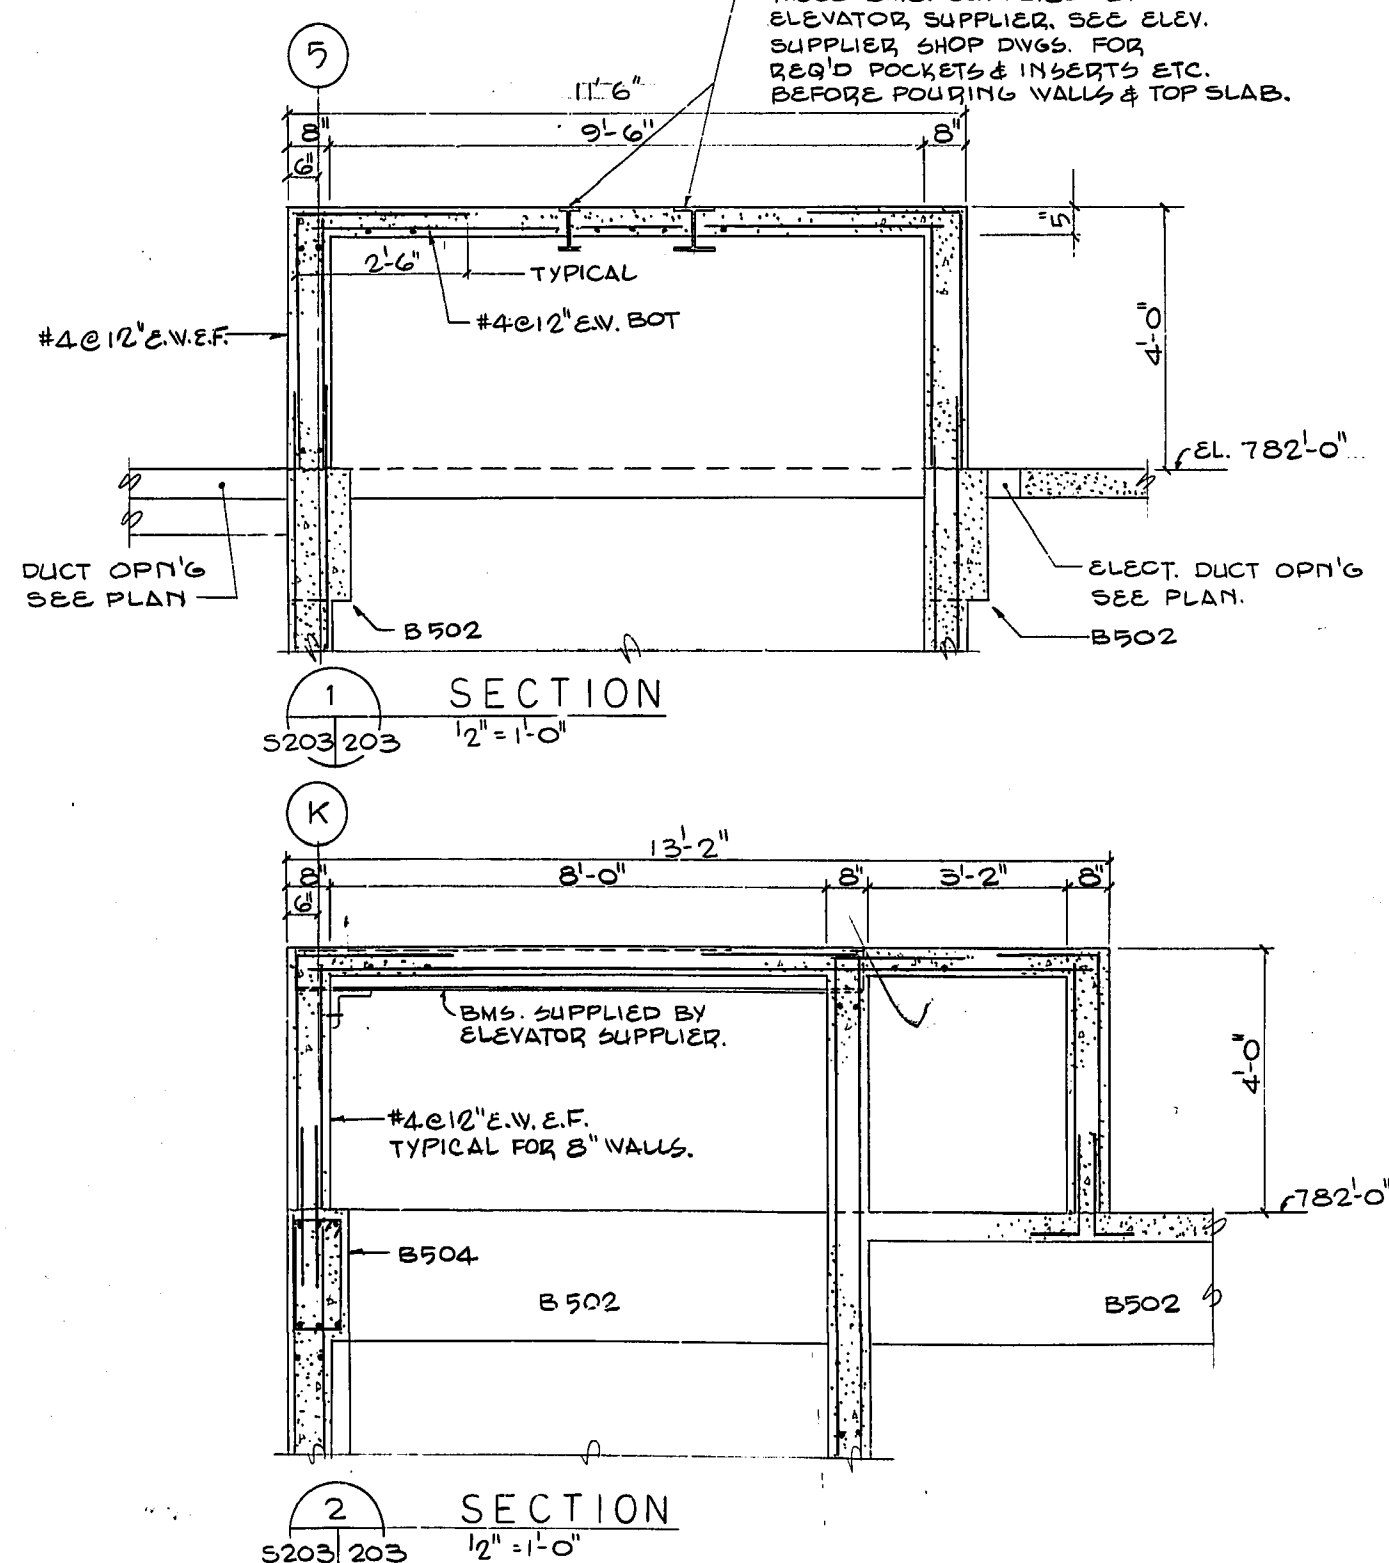

KEY PLAN
1" = 150'



THE METROPOLITAN CORPORATION OF GREATER WINNIPEG	
WATERWORKS & WASTE DISPOSAL DIVISION	
A. PENMAN — DIRECTOR	
	
W. L. WARDROP & ASSOCIATES LTD.	
ENGINEERING CONSULTANTS	
WINNIPEG	THUNDER BAY
REGINA	TORONTO
SOUTH END WATER POLLUTION CONTROL CENTRE	
PUMP & SCREEN BLDG — STRUCTURAL	
PLAN ELEV. 782'-0" & SECTIONS	
SCALE:	ENGINEER OF DESIGN
AS SHOWN	<i>W. L. Wardrop</i>
DATE:	ENGINEER OF OPERATIONS
OCTOBER 1971	<i>James</i>
APPROVED (W.L.W.)	SEAL (METRO)
<i>W. L. Wardrop</i>	<i>W. L. Wardrop</i>
W. L. W. FILE NO.	DRAWING NO.
70012-01-S203	S. E. P. - 37

AS - BUILT		
DATE	FB. NO.	PAGE
20-7-74		