
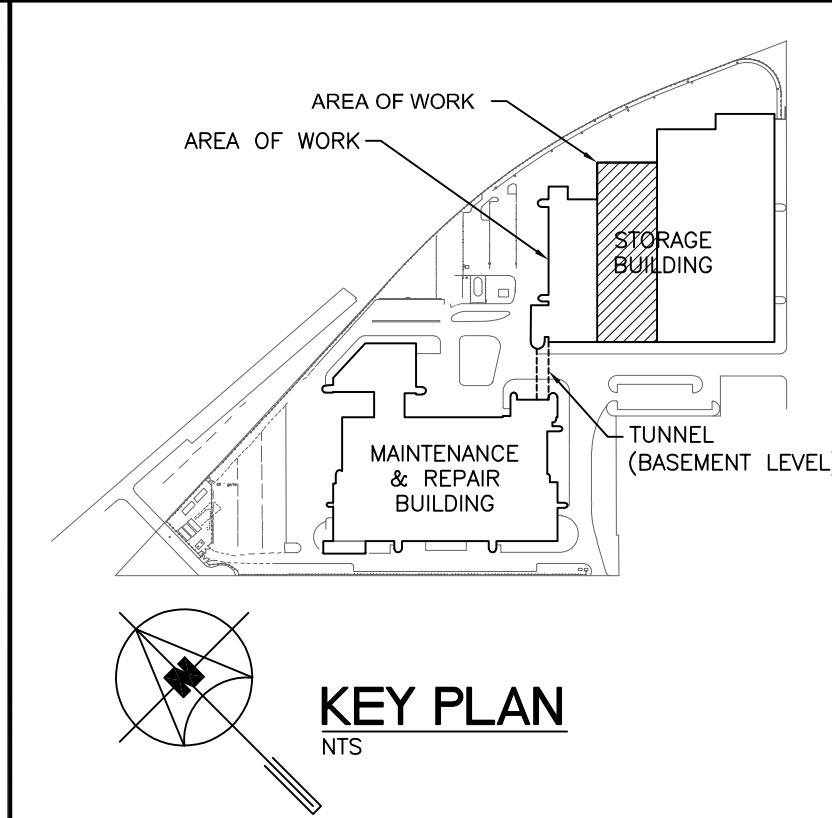


16143\_MFL\_FPF\_1.DWG - NOVEMBER 10, 2016 - 4:00PM CST - GBAUL

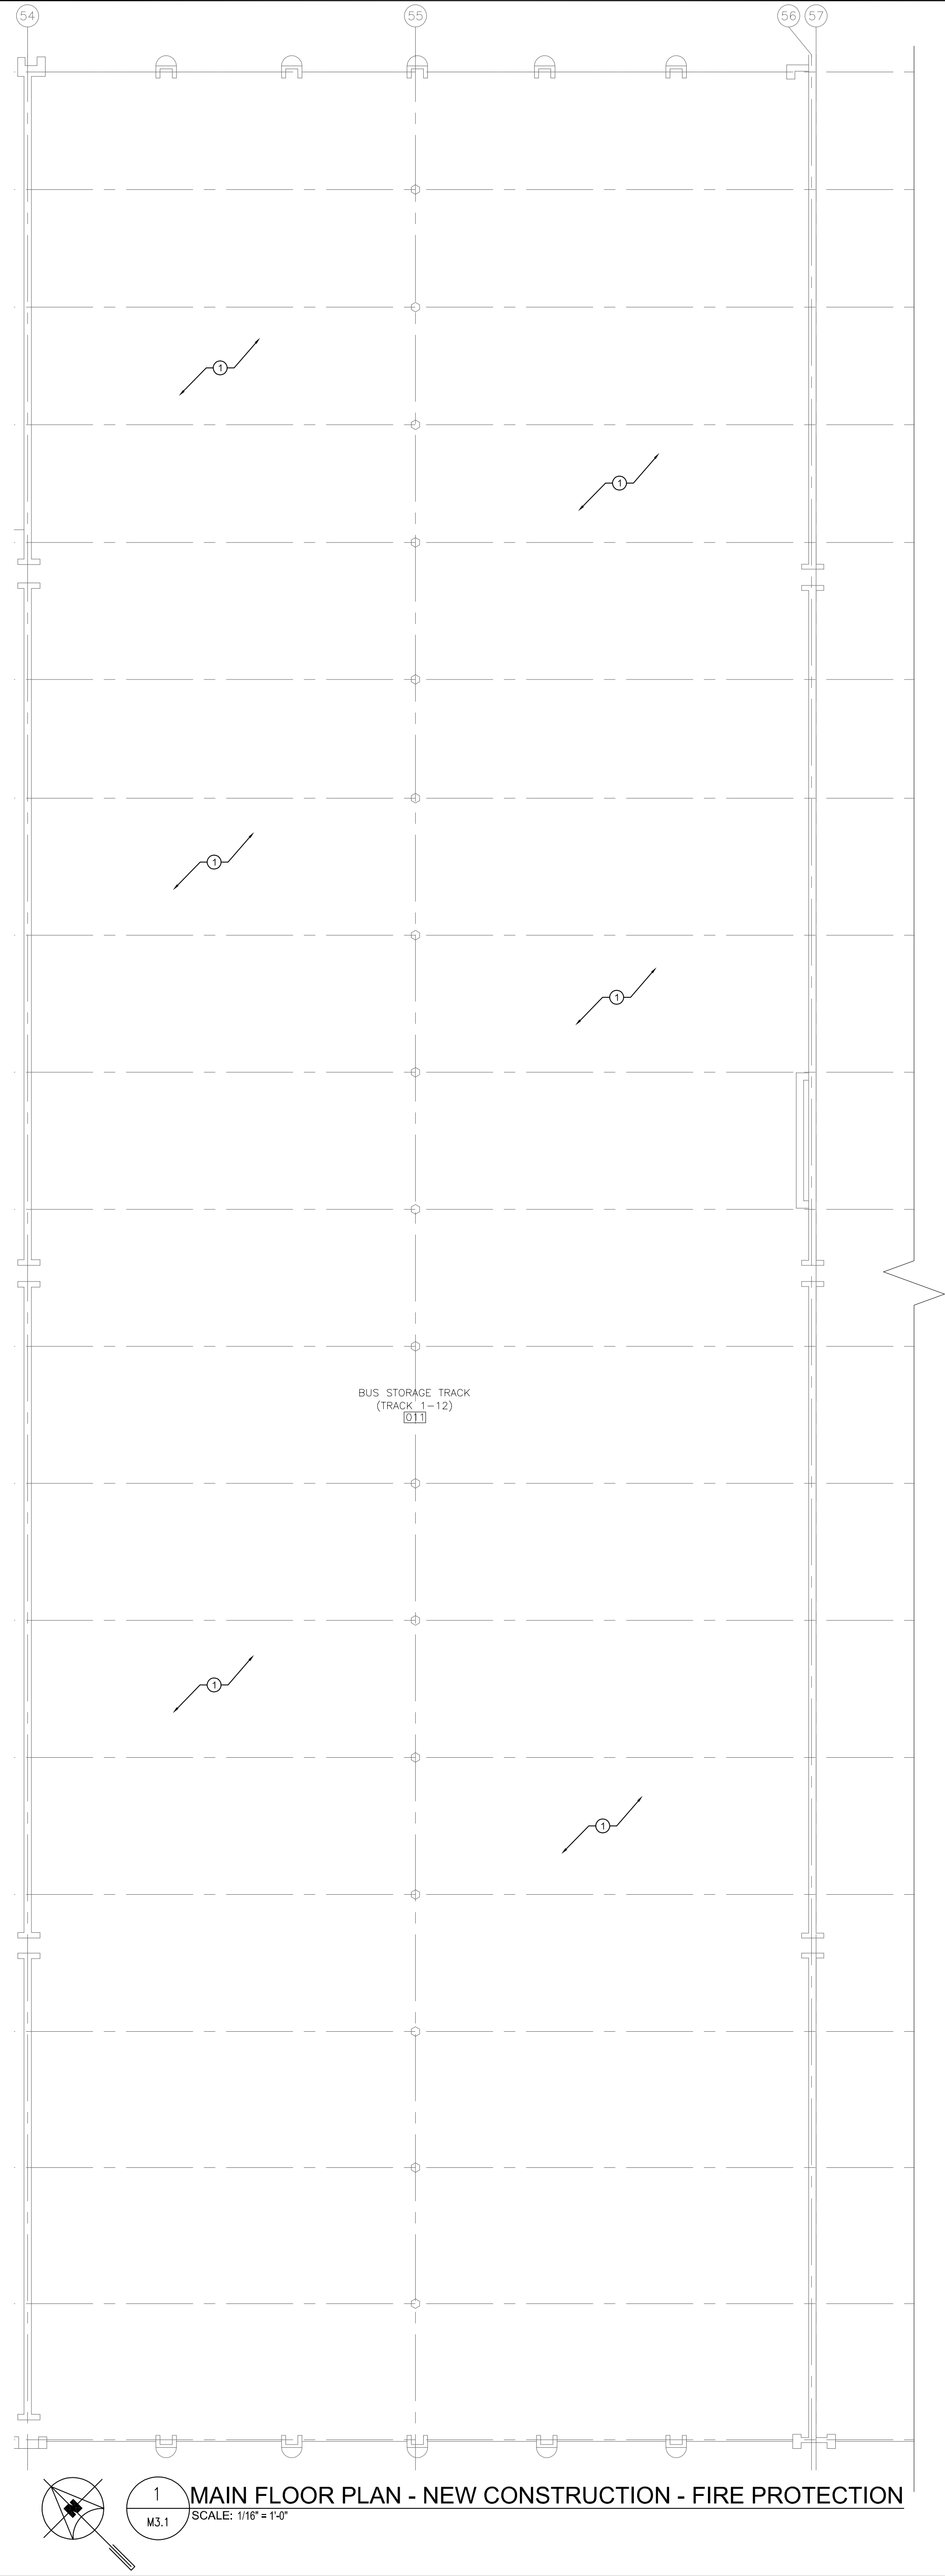


#### GENERAL NOTES

- THIS BUILDING MAY CONTAIN ASBESTOS. REFER TO FRONT END SPECIFICATION FOR INFORMATION.
- THE SPRINKLER SYSTEM SHALL BE DESIGNED AND INSTALLED IN ACCORDANCE WITH NFPA 13, MANITOBA BUILDING CODE, MANITOBA FIRE CODE, LOCAL BUILDING BY-LAWS, THE AUTHORITY HAVING JURISDICTION, AND THE SPECIFICATION.

#### KEY NOTES

- SPRINKLER SYSTEM AT HIGH LEVEL NOT SHOWN. PROVIDE NEW SPRINKLER HEADS UNDER NEW DUCTWORK AS REQUIRED.

5			
4			
3			
2			
1			
0	ISSUED FOR CONSTRUCTION	JH	10/11/16
NO.	Description	BY	DD/MM/YY

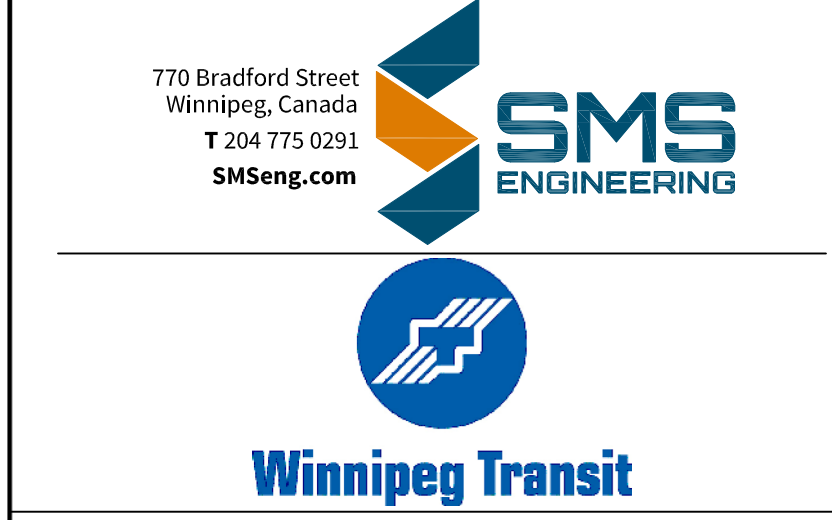

Project Title  
**CITY OF WINNIPEG FORT ROUGE  
TRANSIT BASE - STORAGE TRACK  
1-12 VENTILATION UPGRADE**

WINNIPEG MANITOBA

Drawing Title  
**MAIN FLOOR PLAN - NEW  
CONSTRUCTION - FIRE  
PROTECTION**

Drawn By IE	Checked By XZ	Approved By JH
Scale AS SHOWN	Date SEPTEMBER 2016	Project No. 16-149-01
Revision Number 0	Drawing Number M3.1	Sheet Order 5 OF 9