



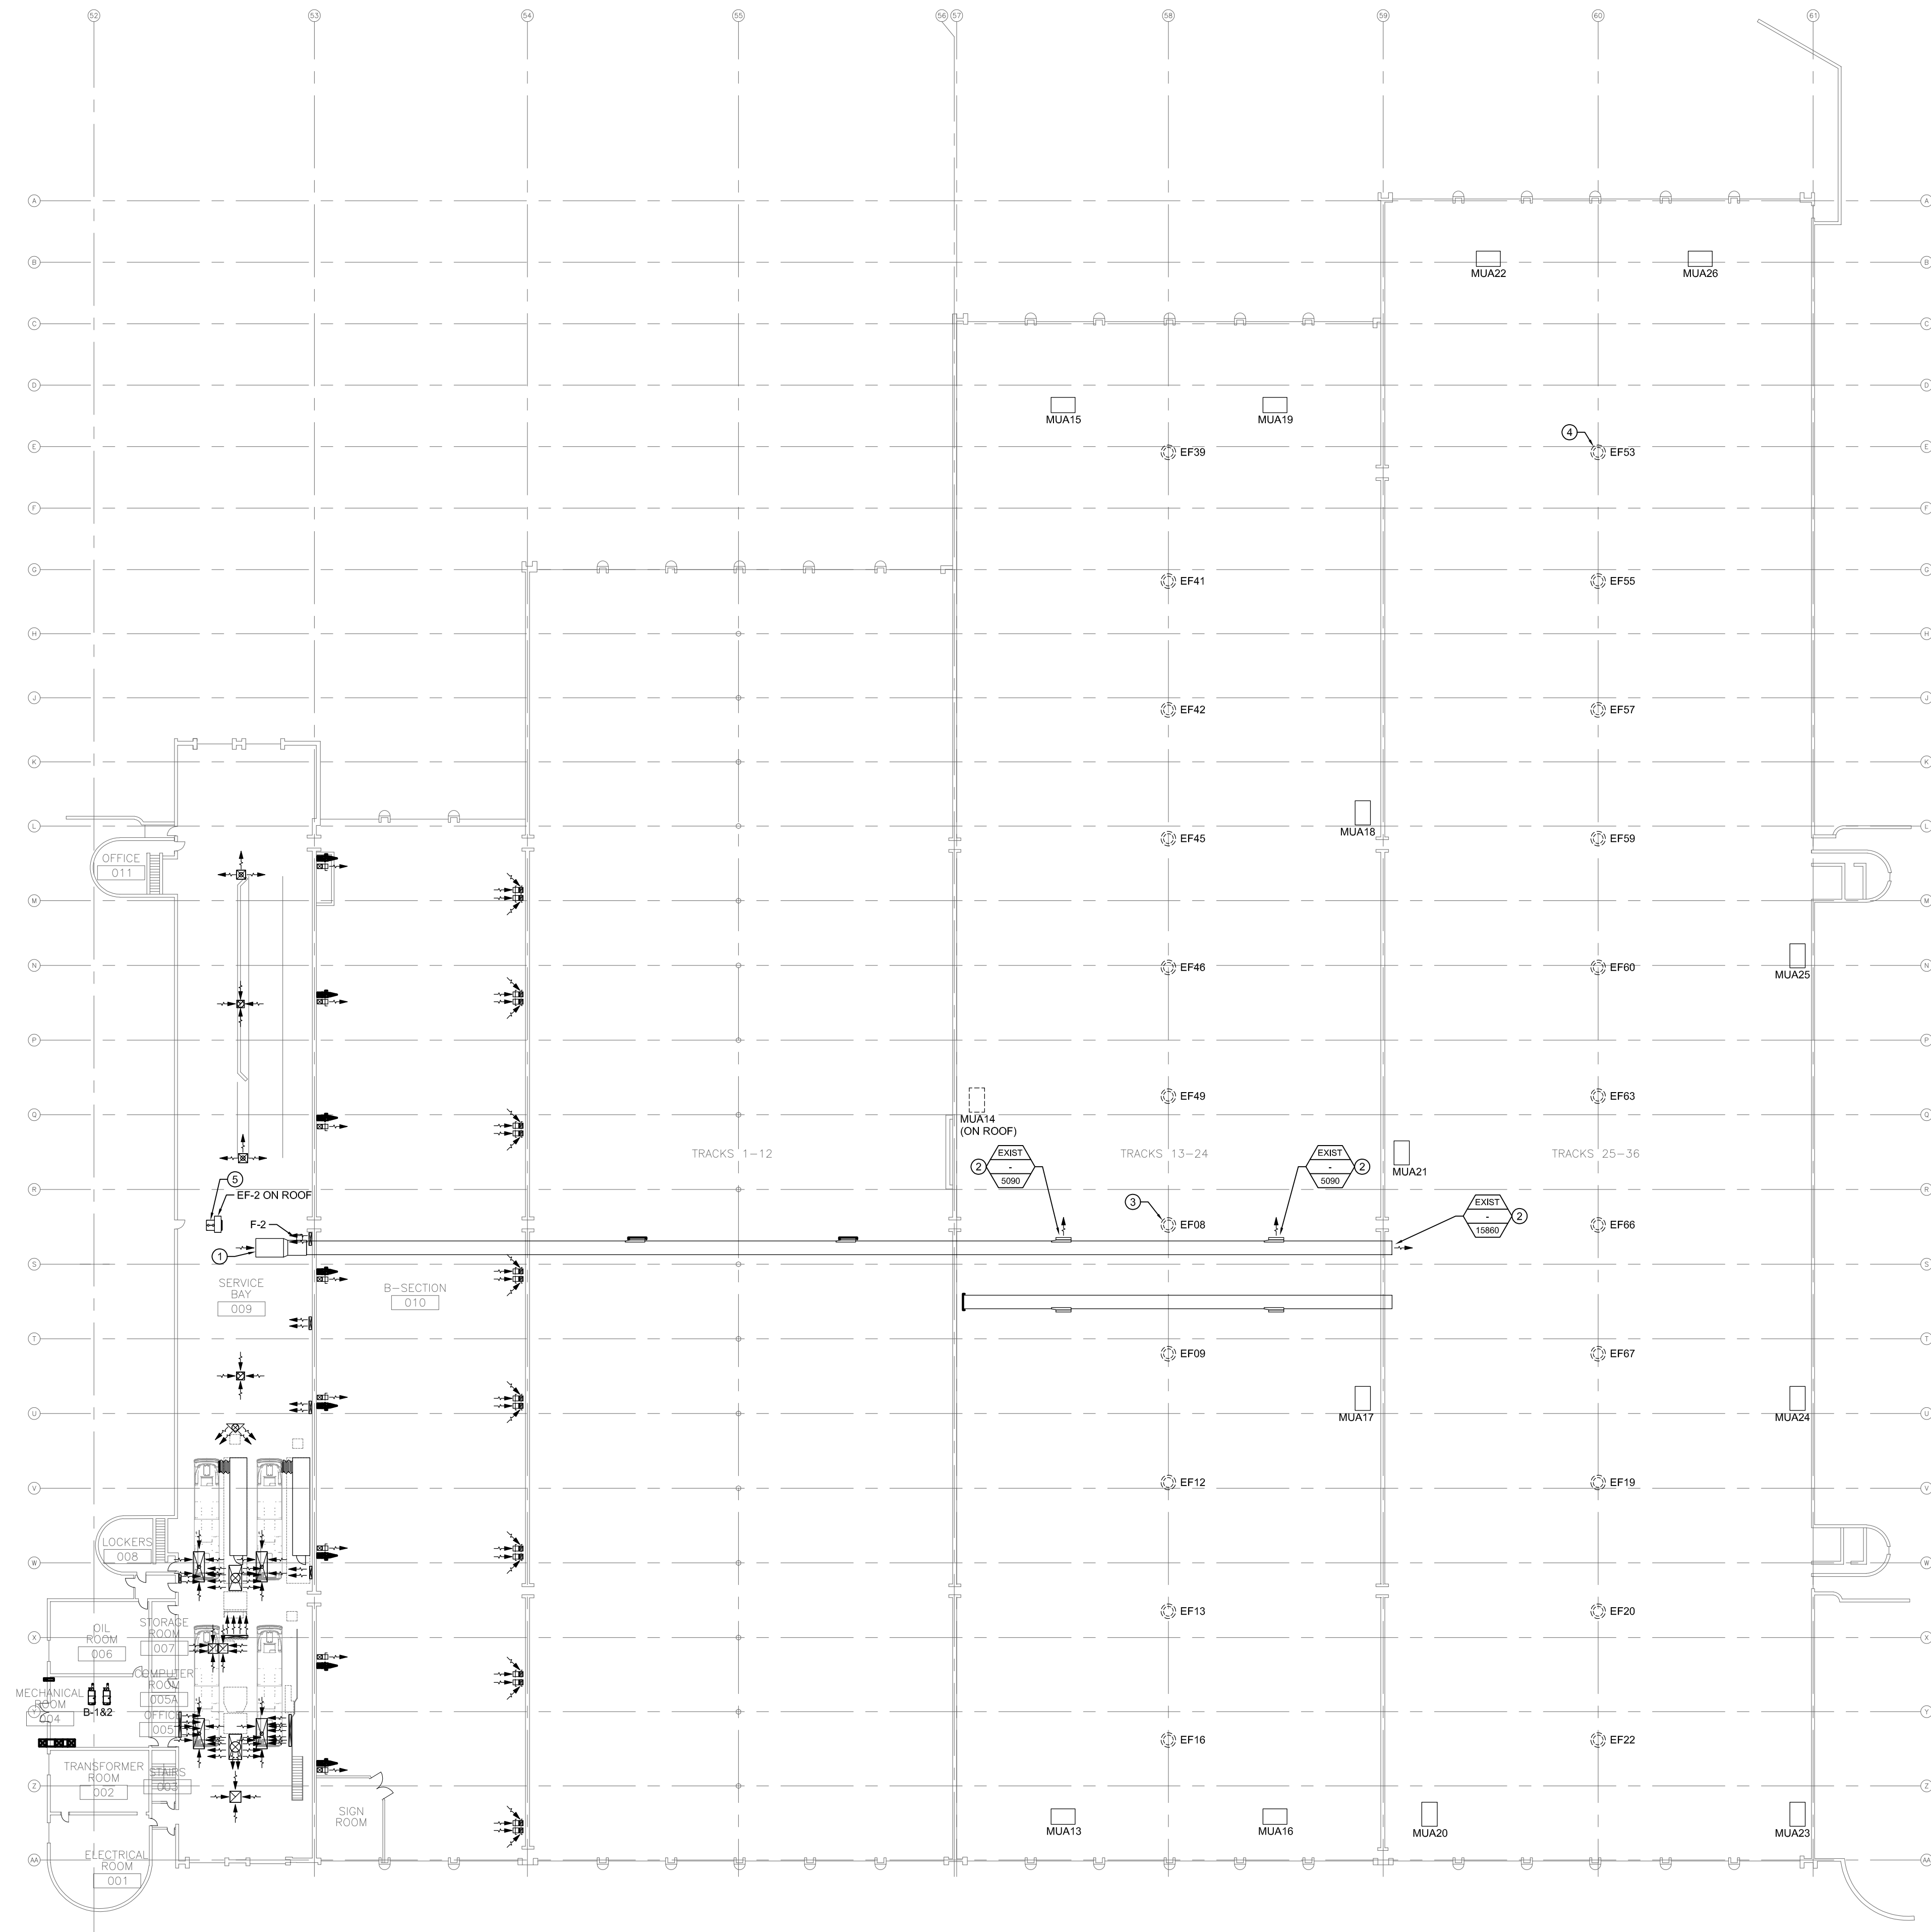

1 MAIN FLOOR PLAN - STORAGE TRACKS REBALANCING - VENTILATION
SCALE: 1/32" = 1'-0"

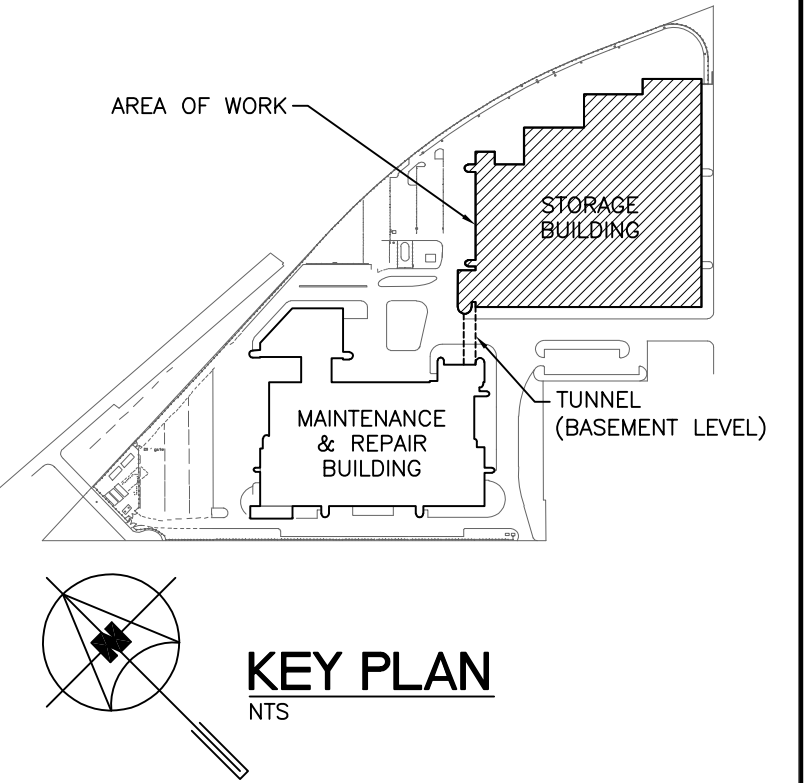

GENERAL NOTES

- ALL ABANDONED EQUIPMENT AND SERVICES WITHIN AREA OF WORK SHALL BE REMOVED.
- THIS BUILDING MAY CONTAIN ASBESTOS. REFER TO FRONT END SPECIFICATIONS FOR FURTHER INFORMATION.

KEY NOTES

- BALANCE THE EXISTING TRANSFER FAN, F-2 TO 26,049 CFM.
- BALANCE THE EXISTING TRANSFER AIR OUTLETS TO THE FLOWS INDICATED.
- BALANCE THE EXISTING EXHAUST FAN, EF-08 TO 4,749 CFM.
- BALANCE THE EXISTING EXHAUST FAN, EF-53 TO 4,799 CFM.
- REFER TO SPECIFICATION FOR SEQUENCE MODIFICATION TO EF-2.

5			
4			
3			
2			
1			
0	ISSUED FOR CONSTRUCTION	JH	10/11/16
NO.	Description	BY	DD/MM/YY



Project Title
CITY OF WINNIPEG FORT ROUGE
TRANSIT BASE - STORAGE TRACK
1-12 VENTILATION UPGRADE

WINNIPEG MANITOBA

Drawing Title
MAIN FLOOR PLAN - STORAGE
TRACKS REBALANCING -
VENTILATION

Drawn By GB	Checked By XZ	Approved By JH
Scale AS SHOWN	Date SEPTEMBER 2016	Project No. 16-149-01
Revision Number 0	Drawing Number M4.2	Sheet Order 7 OF 9