

A1 SIZE 594mm x 841mm
PLOT: 4/25/2016 8:24:45 PM
FILE NAME: W160015-Cover Sheet 2B.dwg, Saved By: kberard



THE CITY OF WINNIPEG

PUBLIC WORKS DEPARTMENT


ENGINEERING DIVISION

2016 LOCAL STREETS PACKAGE

SONY PLACE, TROTTIER BAY AND

VARIOUS OTHER LOCATIONS

BID OPPORTUNITY No. 181-2016

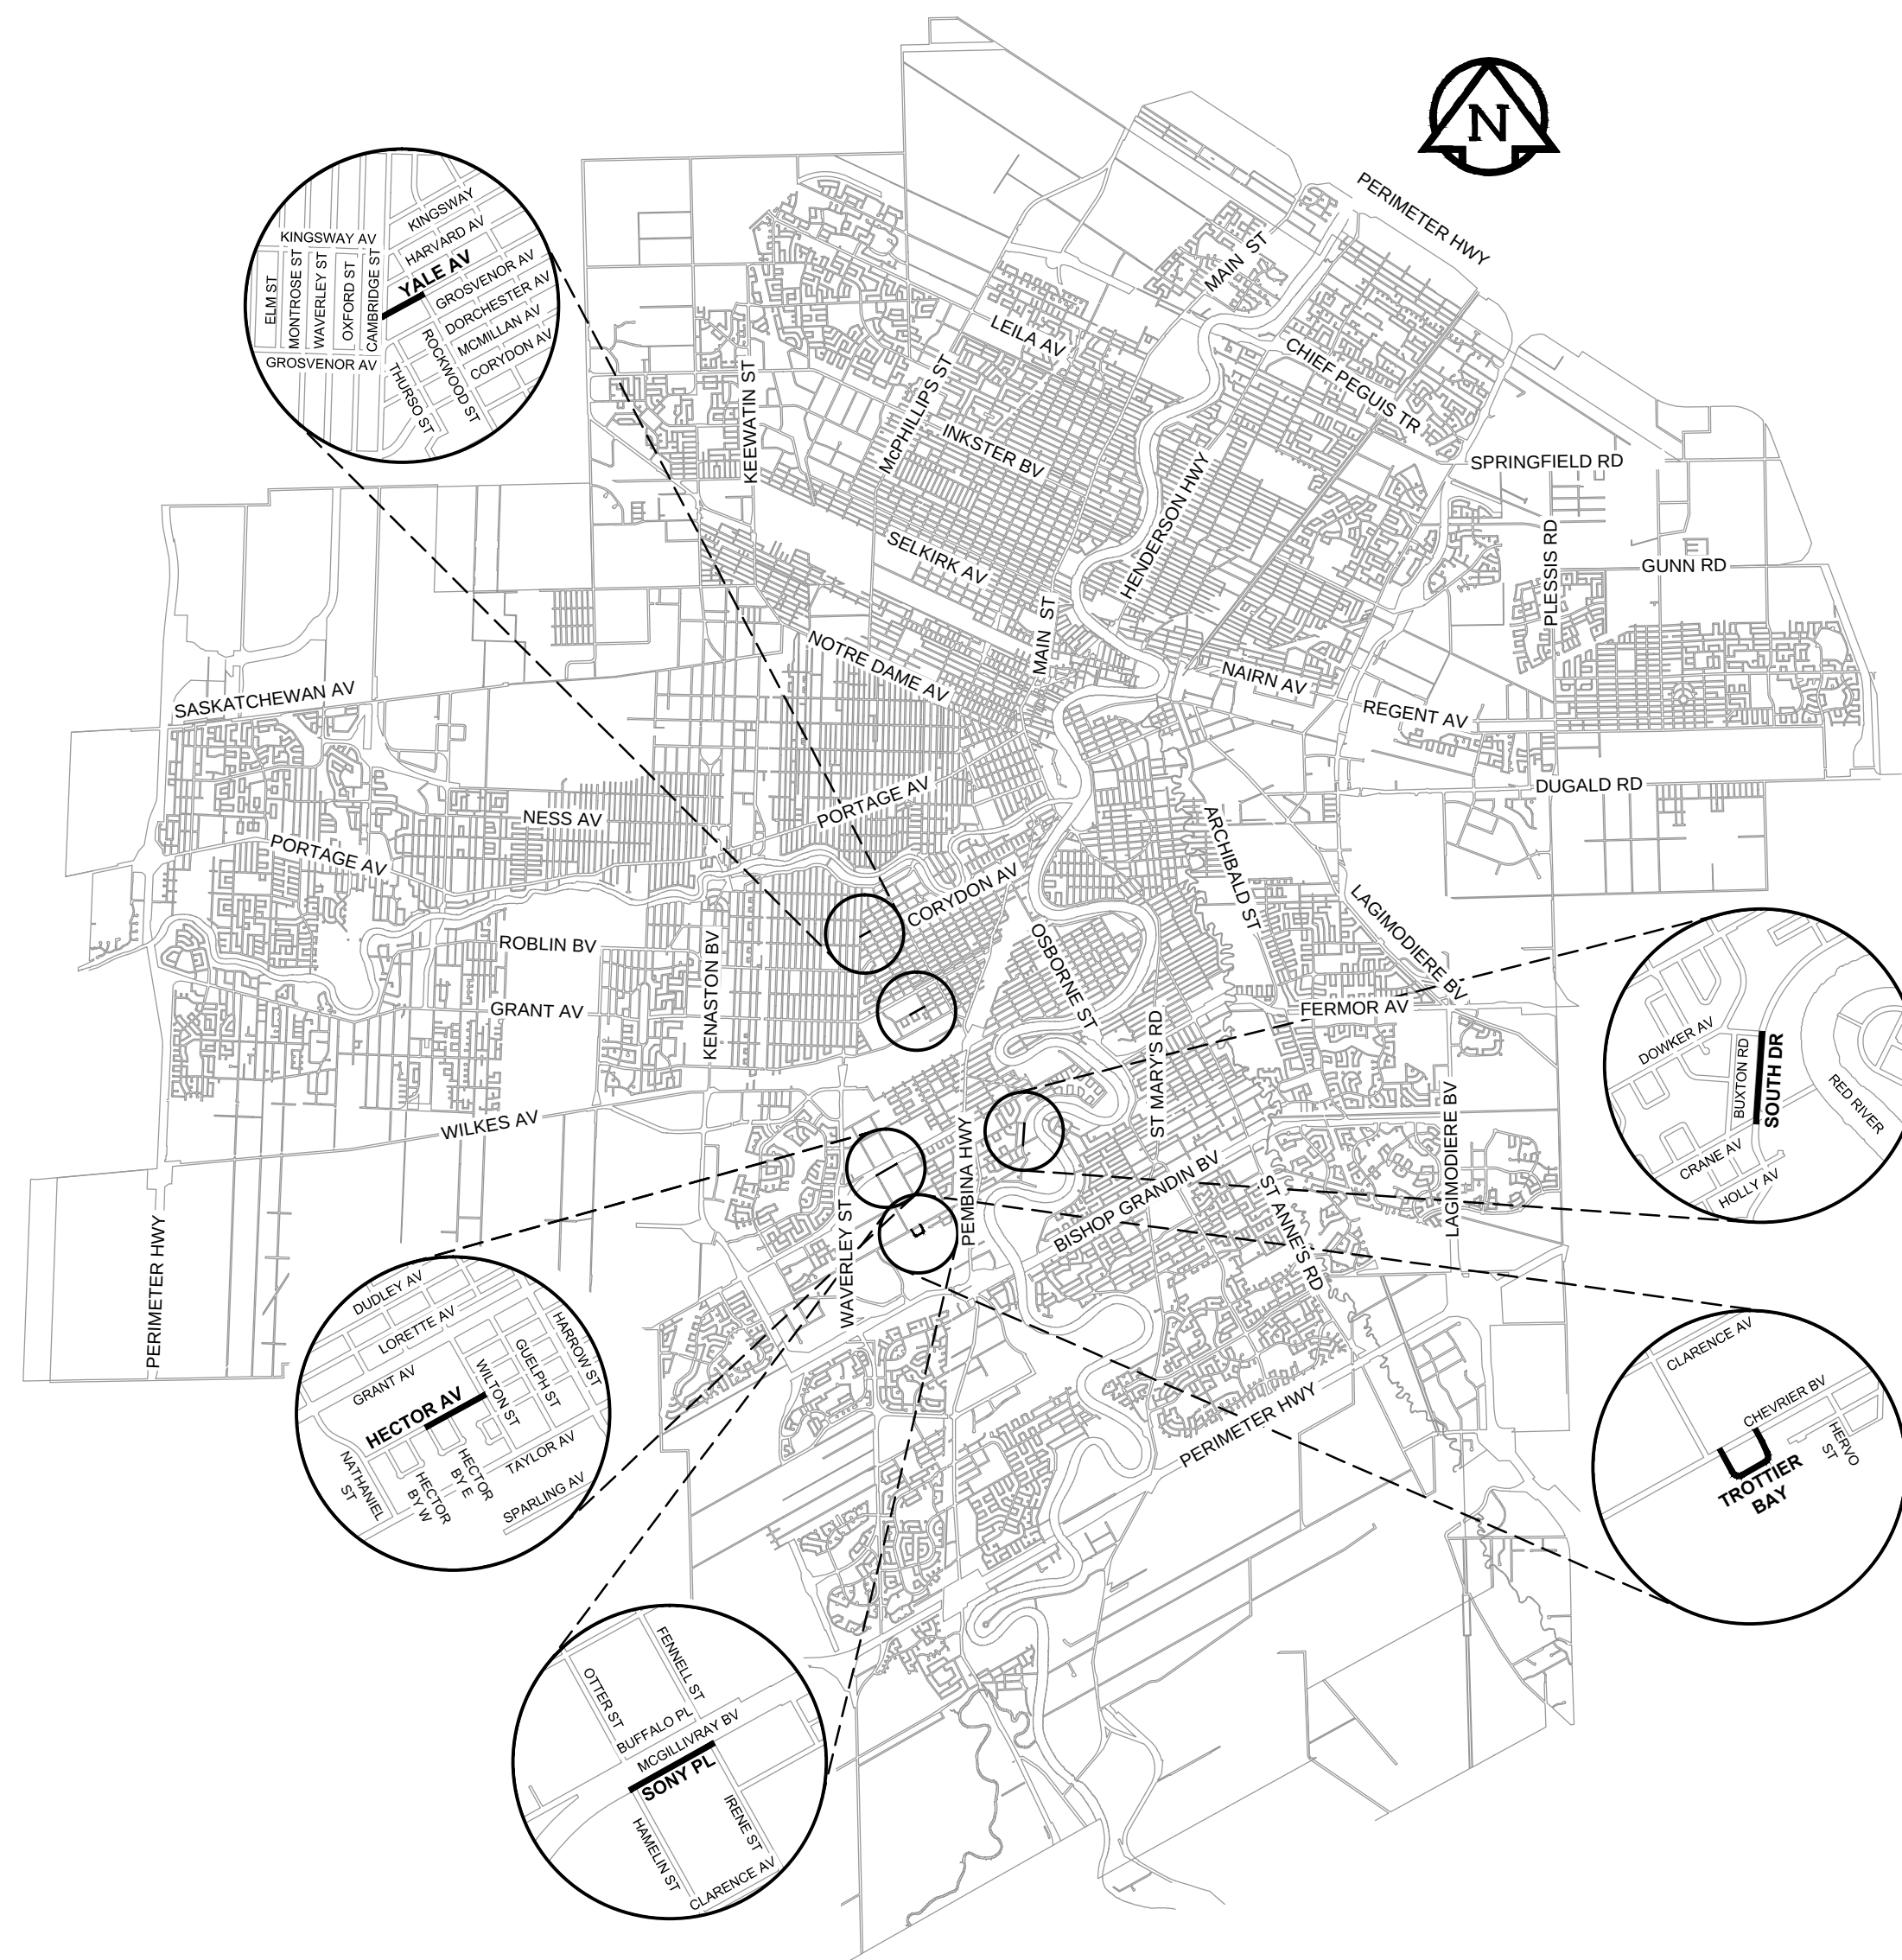

LOCATION PLAN

SCALE: 1:100,000
0 2500 5000m

DRAWING LIST

DRAWING
NUMBER DESCRIPTION

0 COVER SHEET AND LOCATION PLAN

YALE AVENUE - CAMBRIDGE ST TO ROCKWOOD ST CONCRETE RECONSTRUCTION

HORIZONTAL AND VERTICAL ALIGNMENT
1 CAMBRIDGE ST TO STA 0+190
2 STA 0+190 TO ROCKWOOD ST

HECTOR AVENUE - HECTOR BAY E (W LEG) TO WILTON ST CONCRETE RECONSTRUCTION

HORIZONTAL AND VERTICAL ALIGNMENT
3 HECTOR BAY E (W LEG) TO STA 0+450
4 STA 0+450 TO STA 0+550
5 STA 0+550 TO WILTON ST

SONY PLACE - HAMELIN ST TO IRENE ST CONCRETE RECONSTRUCTION

HORIZONTAL AND VERTICAL ALIGNMENT
6 HAMELIN ST TO STA 0+220
7 STA 0+220 TO STA 0+350
8 STA 0+350 TO IRENE ST

TROTTIER BAY - CHEVRIER BV TO CHEVRIER BV CONCRETE RECONSTRUCTION

HORIZONTAL AND VERTICAL ALIGNMENT
9 CHEVRIER BV TO STA 0+220
10 STA 0+220 TO STA 0+360
11 STA 0+360 TO CHEVRIER BV

SOUTH DRIVE - CRANE AV TO DOWKER AV CONCRETE RECONSTRUCTION

HORIZONTAL AND VERTICAL ALIGNMENT
12 CRANE AV TO STA 0+210
13 STA 0+210 TO STA 0+340
14 STA 0+340 TO DOWKER AV

STREET LIGHTING PROJECT

1-04707-DE-50000-0282 0001 YALE AVENUE - CAMBRIDGE ST TO ROCKWOOD ST
(CONTRACTOR TO REPLACE EXISTING UNDERGROUND STREET LIGHTING PLANT)
1-04707-DE-50000-0284 0001 HECTOR AVENUE - HECTOR BAY E (W LEG) TO WILTON ST
(CONTRACTOR TO REPLACE EXISTING UNDERGROUND STREET LIGHTING PLANT)
1-04707-DE-50000-0285 0001 SONY PLACE - HAMELIN ST TO IRENE ST
(CONTRACTOR TO REPLACE EXISTING UNDERGROUND STREET LIGHTING PLANT)



COVER SHEET
AND LOCATION PLAN

CITY DRAWING No. N/A REV B

CONSULTANT NO.
W160015-Cover Sheet 2B.dwg

RELEASED FOR CONSTRUCTION BY:

STREETS PROJECT ENGINEER

DATE

