

May 24, 2016 - 5:00pm  
H:\0300\03031\03\_00 Drawings\ELC\03031-03\_E1.0.dwg -106.E1.0

ELECTRICAL SYMBOL LEGEND

LIGHTING

- A ○ GROUND MOUNTED LUMINAIRE, TYPE 'A' AS SPECIFIED
- A ○ WALL MOUNTED LUMINAIRE, TYPE 'A' AS SPECIFIED
- H ○ POLE MOUNTED LUMINAIRE, TYPE 'H' AS SPECIFIED
- ⓔ PHOTO ELECTRIC CONTROL

GENERAL POWER

- Ⓢ 15A, U-GROUND DUPLEX RECEPTACLE
- Ⓢ (5-20R) T-SLOT U-GROUND DUPLEX RECEPTACLE

MISCELLANEOUS

- ⓔ INDICATES EXISTING DEVICE TO REMAIN
- ⓔ<sup>MV</sup> INDICATES EXISTING DEVICE TO BE MOVED
- ⓔ<sup>R</sup> INDICATES EXISTING DEVICE IN RELOCATED POSITION
- ⓔ<sup>D</sup> INDICATES EXISTING DEVICE TO BE DEMOLISHED

----- INDICATES CONDUIT

- ⓔ (TYP) ELECTRICAL DRAWING NOTES

NOTE:


NOT ALL SYMBOLS SHOWN ON THIS LEGEND ARE NECESSARILY USED ON THIS PROJECT.

ELECTRICAL DRAWING LIST


- E1.0 ELECTRICAL SYMBOL LEGEND & DRAWING LIST
- E1.1 JOHN HIRSCH - ELECTRICAL LAYOUT
- E1.2 LILY ST. - MARKET AVE. TO RUPERT AVE. - ELECTRICAL LAYOUT
- E1.3 LILY ST. - PACIFIC AVE. TO GALT AVE. ELECTRICAL LAYOUT
- E1.4 ELECTRICAL SPECIFICATION

ABBREVIATIONS


- A - AMPERES
- AFG - ABOVE FINISHED GRADE
- C - CONDUCTOR
- CNDT - CONDUIT
- D - DELETE
- DB - DIRECT BURIED
- E - EXISTING
- KVA - KILO VOLT-AMPERES
- kW - KILOWATTS
- LTG - LIGHTING
- MTD - MOUNTED
- MTG - MOUNTING
- MV - EXISTING TO BE MOVED
- NIC - NOT IN CONTRACT
- V - VOLT
- WP - WEATHERPROOF

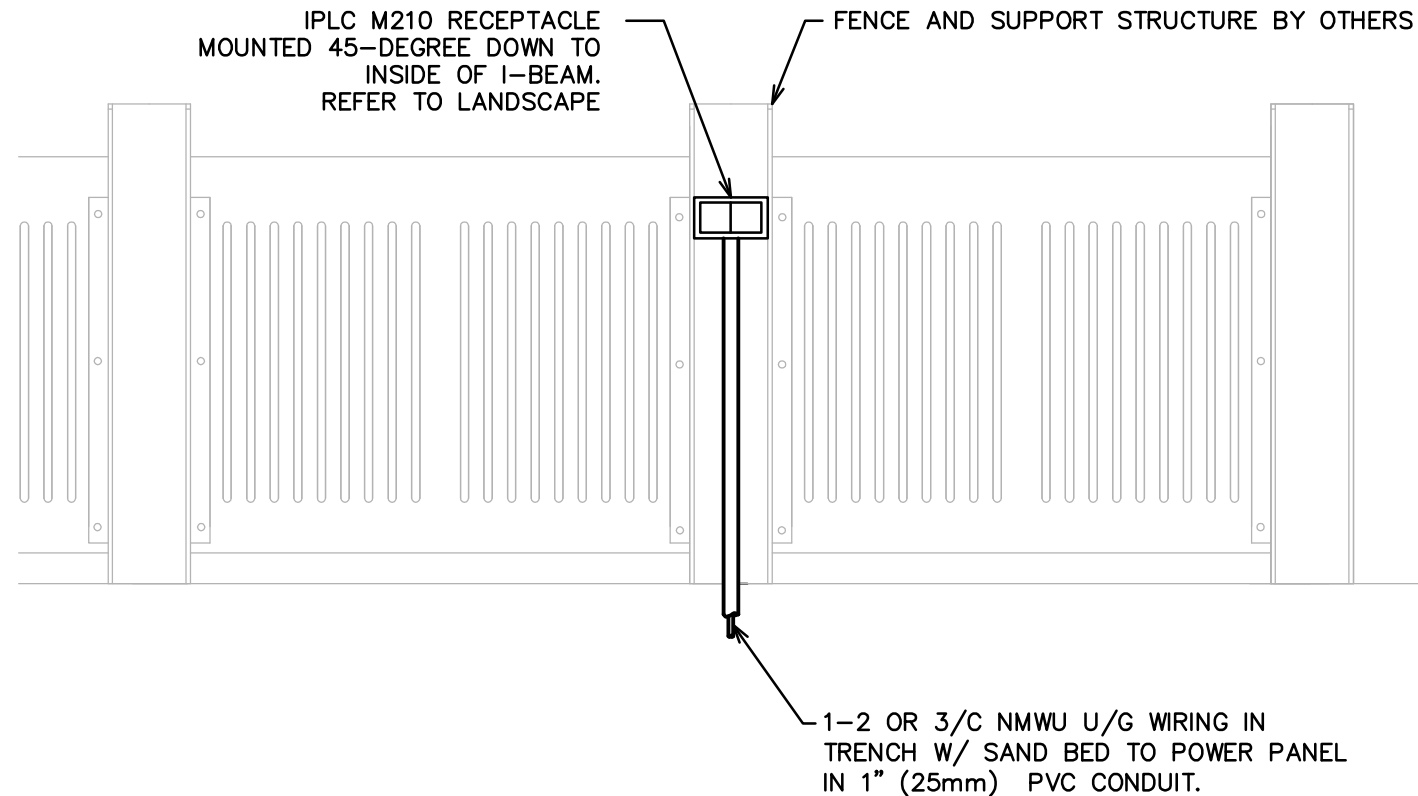

1 PARKING FENCE - RECEPTACLE INSTALLATION  
E1.0 SCALE: N.T.S

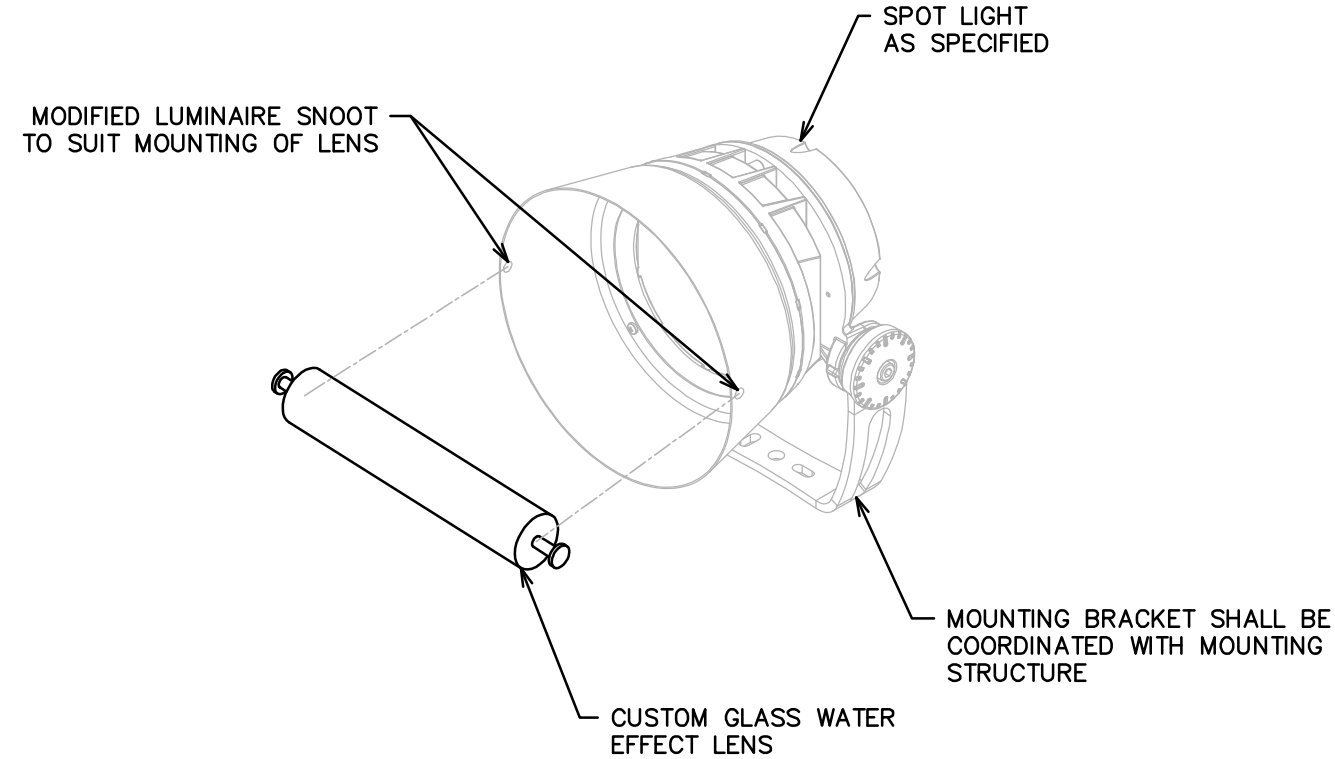

2 CUSTOM LUMINAIRE INSTALLATION  
E1.0 SCALE: N.T.S

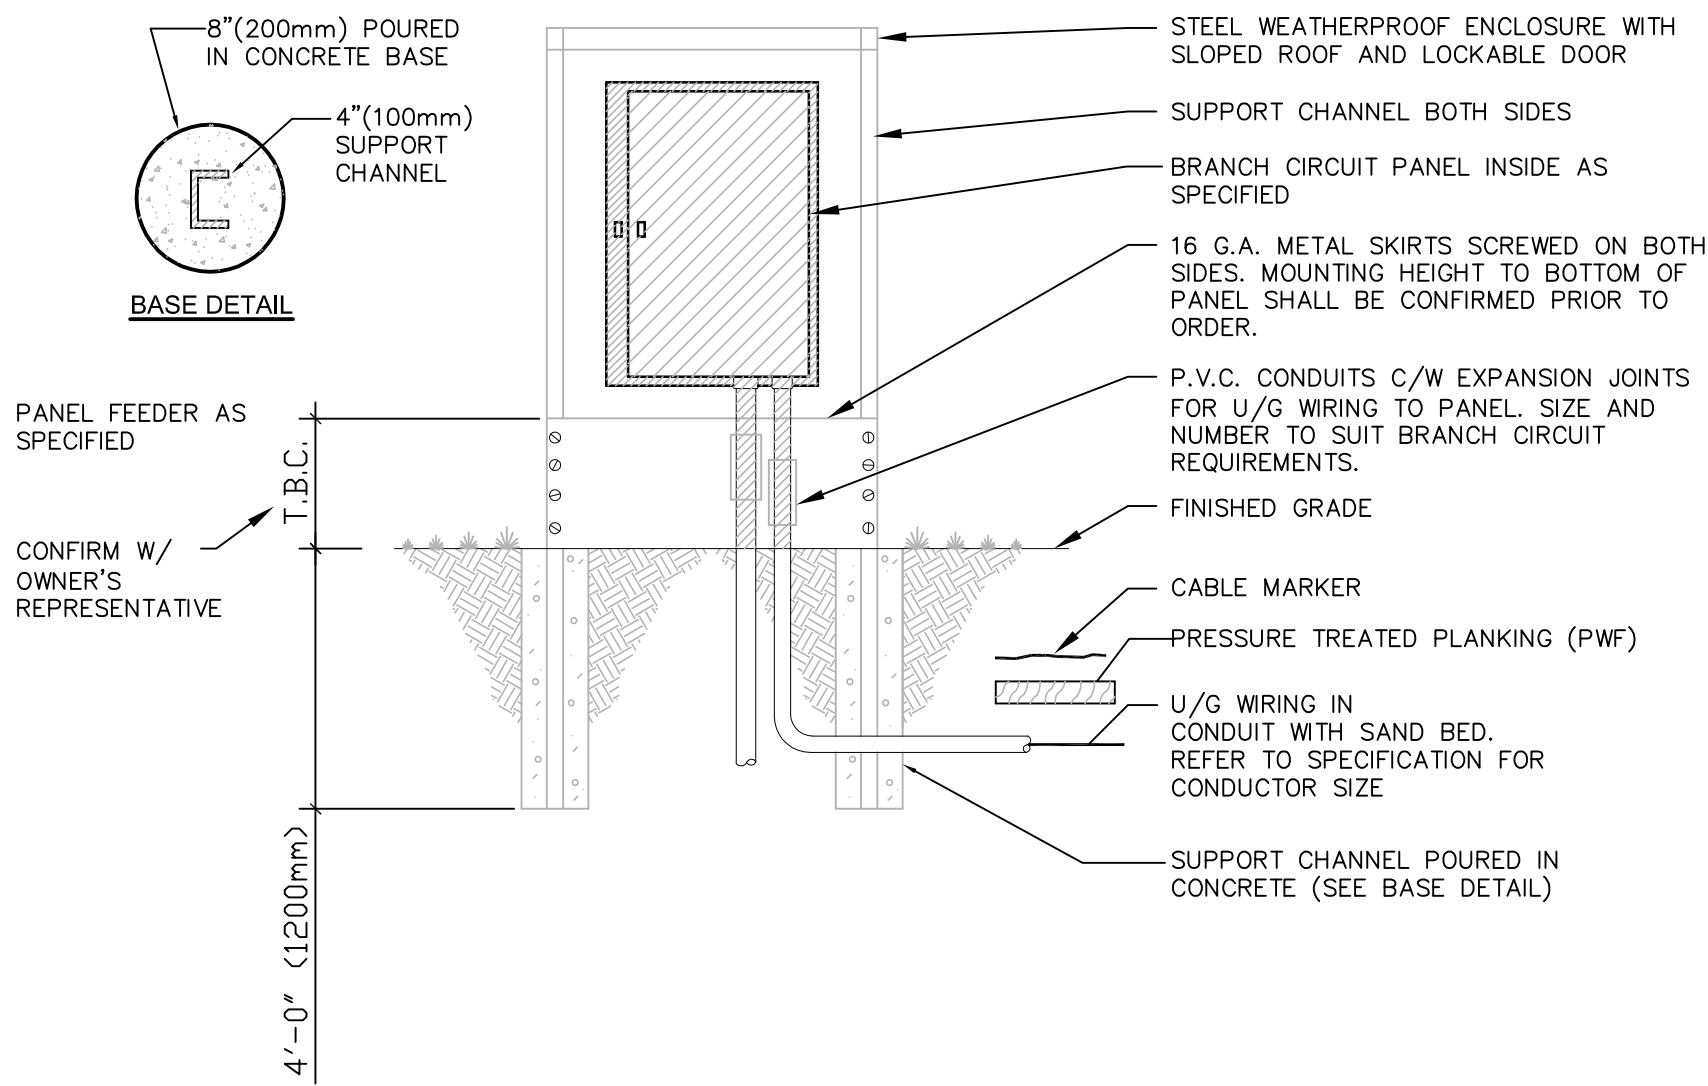

3 WEATHERPROOF PANELBOARD  
E1.0 SCALE: N.T.S

NOTE:  
These design documents are prepared solely for the use by the party with whom the design professional has entered into a contract and there are no representations of any kind made by the design professional to any party with whom the design professional has not entered into a contract.

	G.B.M. ELEV.				ENGINEER'S SEAL 	
	DESIGNED BY MJB		CHECKED BY EG	CONSULTANT ACAD DWG. NO. E1.0		
	DRAWN BY MJB		APPROVED BY EG			
	SCALE N.T.S.					
	NO. REVISIONS		DATE		BY	
3 ISSUED FOR TENDER		05/25/16	MJB			
3 ISSUED FOR CITY OF WINNIPEG REVIEW		05/10/16	MJB			
2 ISSUED TO U/G STRUCTURES FOR REVIEW		04/08/16	MJB			
1 ISSUED FOR CITY OF WINNIPEG REVIEW		03/18/16	MJB			

CITY DRAWING NUMBER	SHEET 35 OF 39
BID NO.	345-2016