




File Name: P:\Projects\2015\15-0107-012\Mech\15-0107-012\_Dwg\Mech\15-0107-012\_P1.1.dwg - Tab: P1.1 Plotted By: DDerocche 05/09/2016 (Mon 1:25pm)

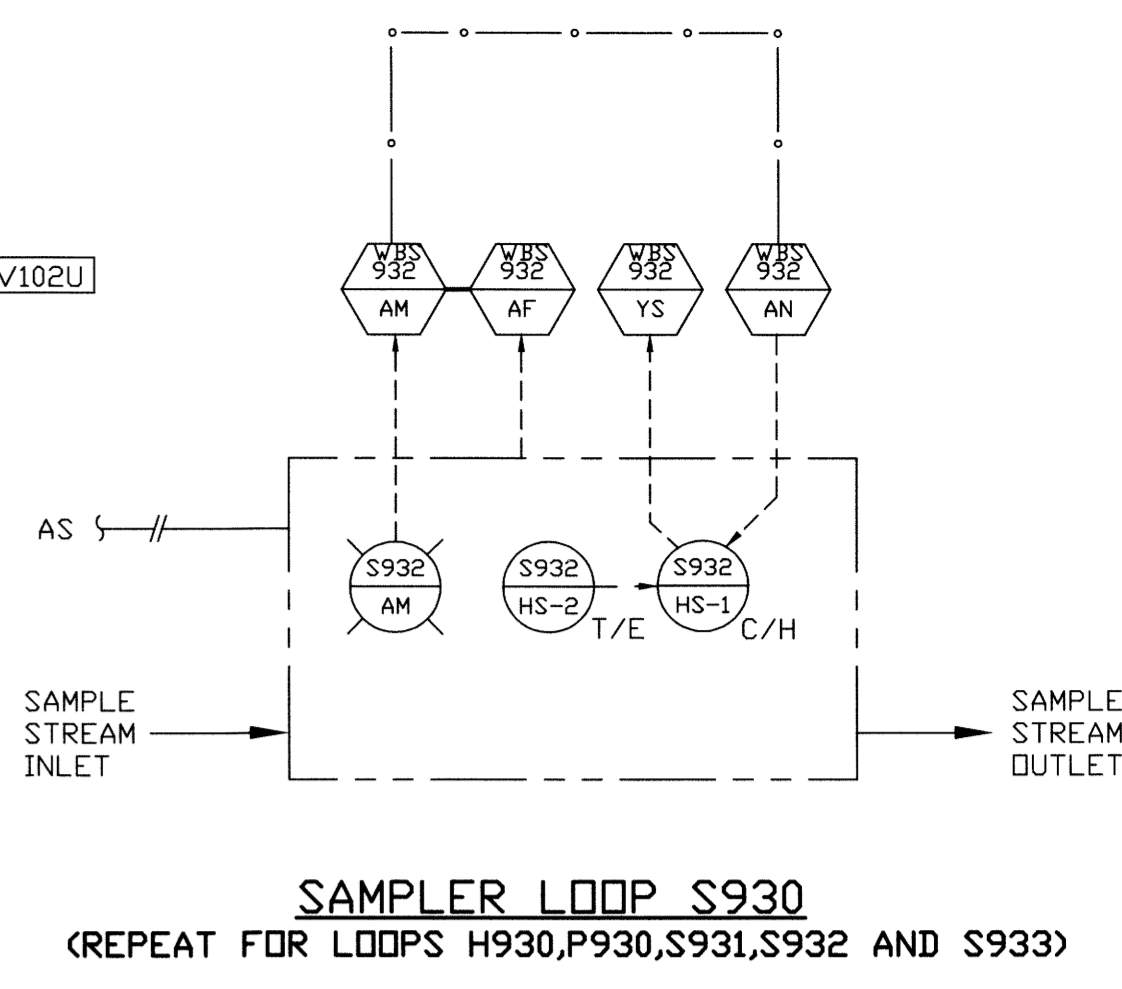

THIS DRAWING IS BASED ON EXISTING SYSTEM P&ID, DRAWING NO. WEP-93 REV. 2

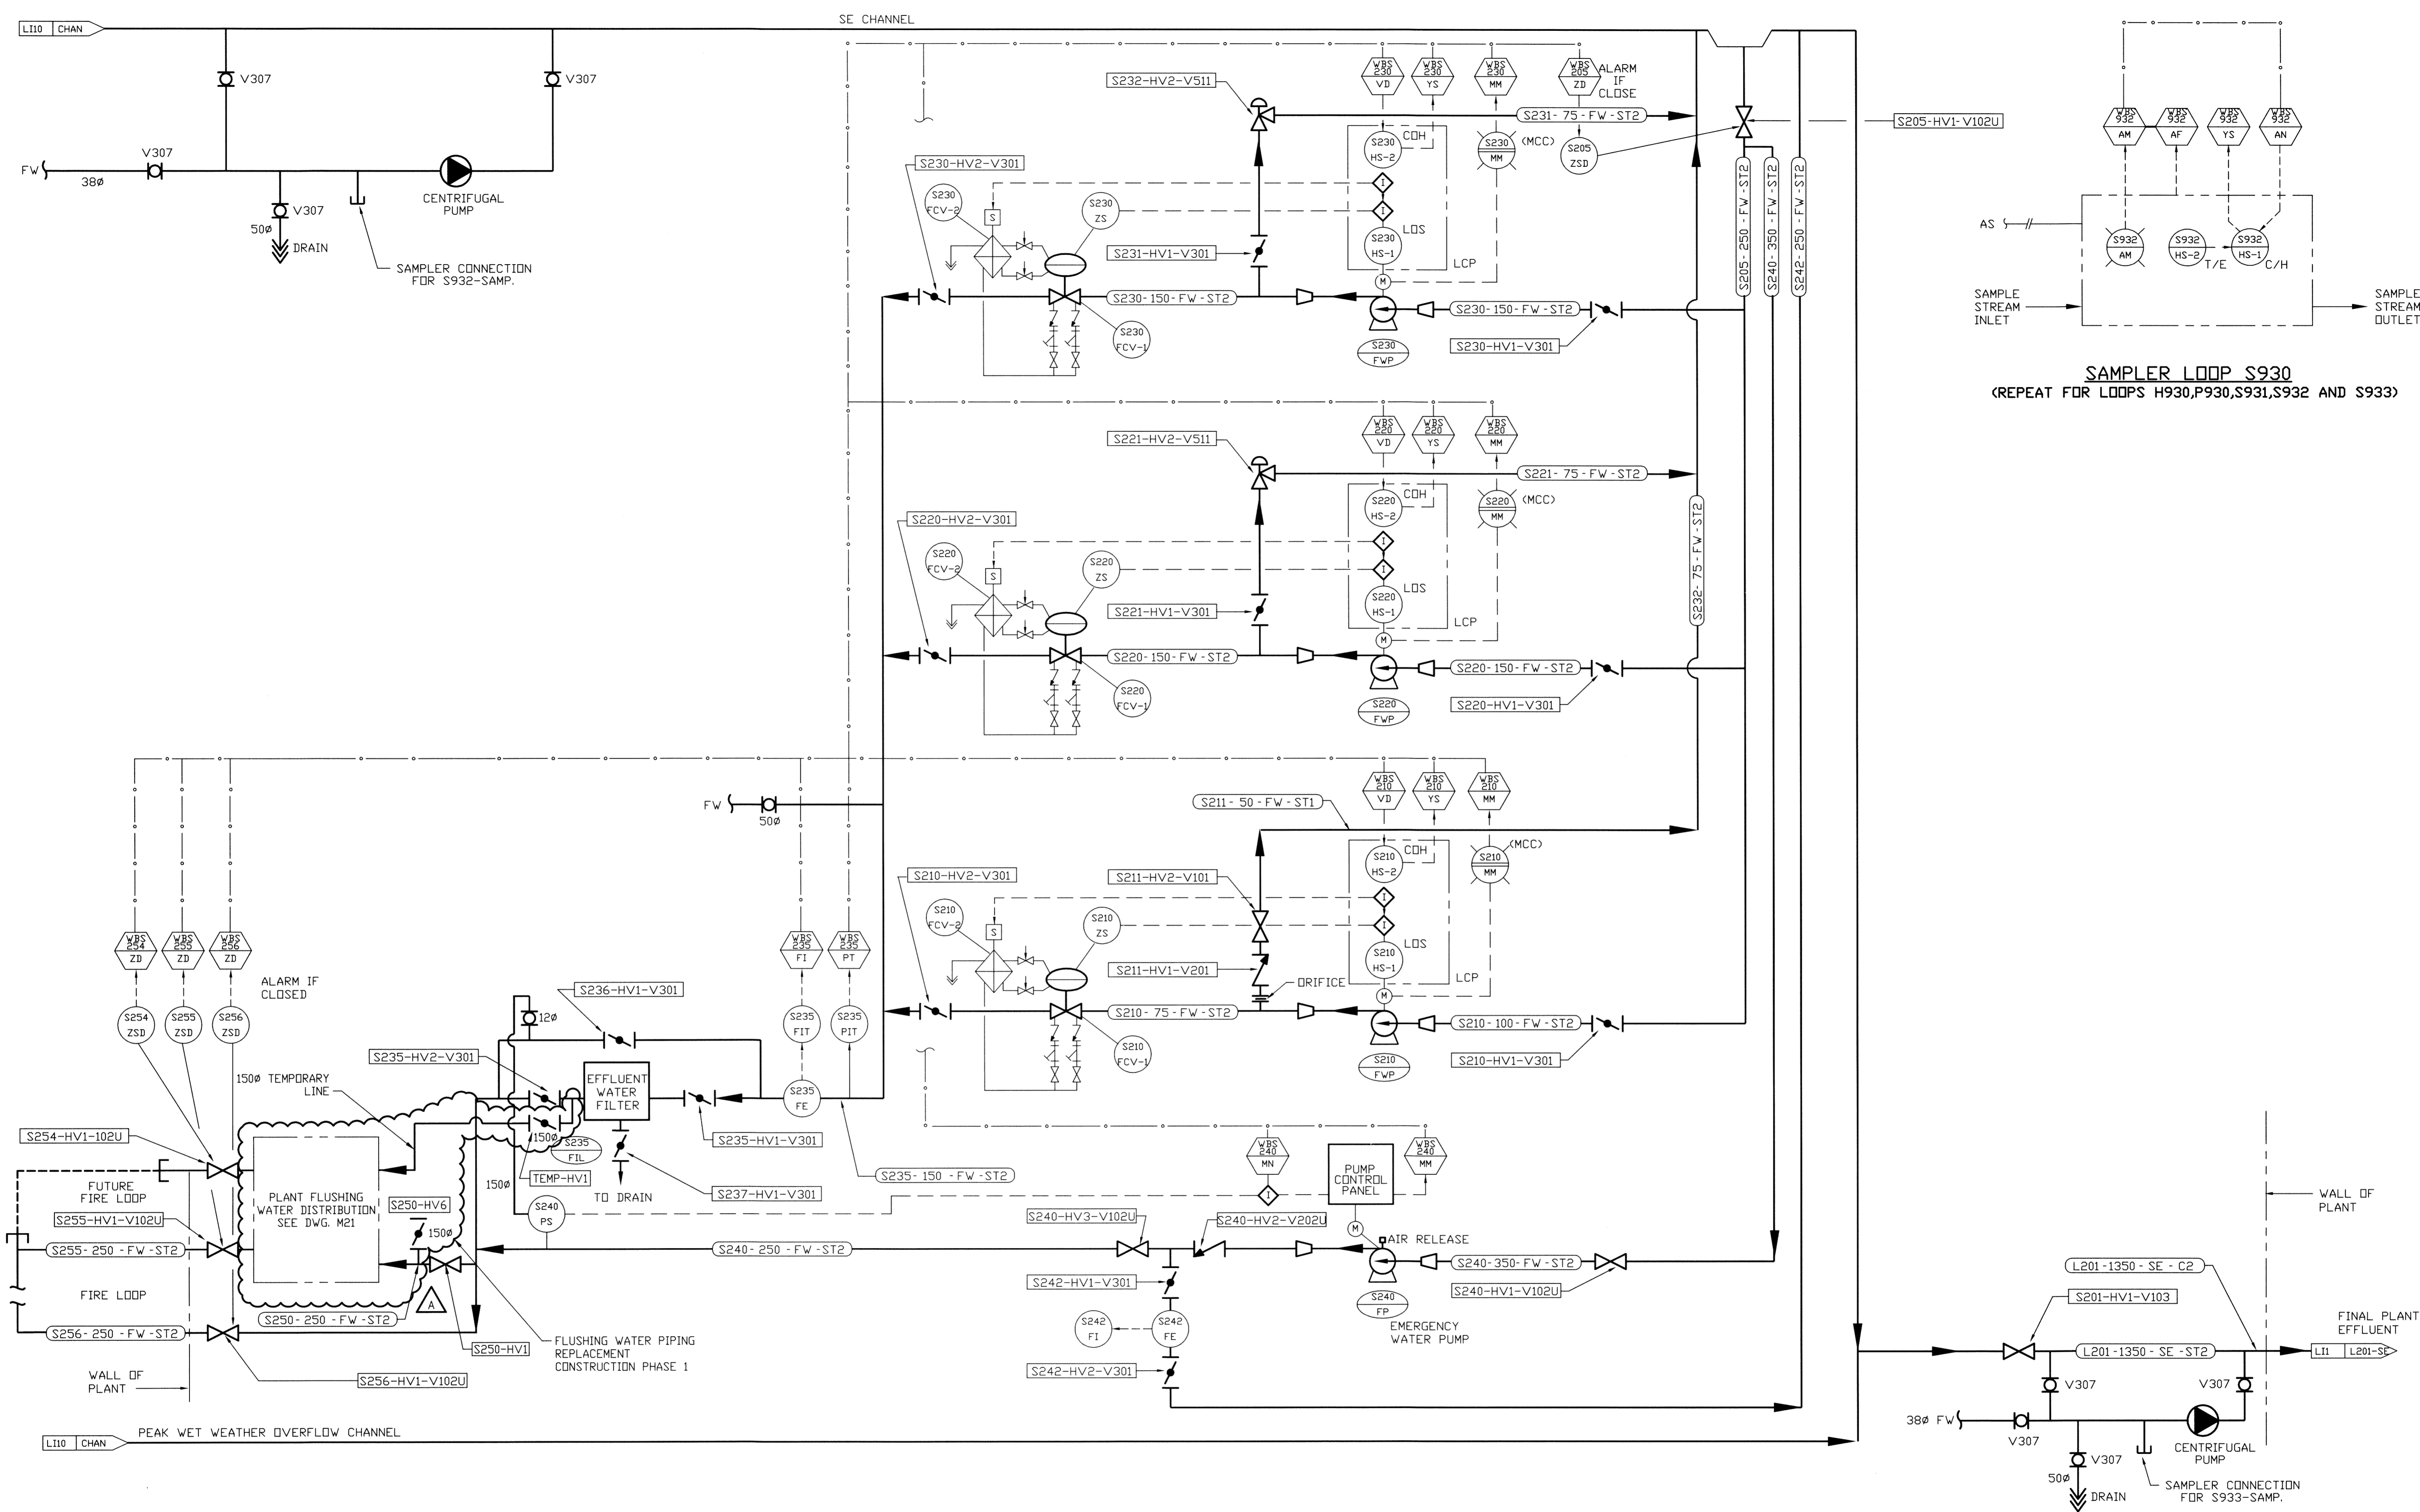

FIELD BOOK #		DESIGNED BY JS		CHECKED BY MKR	
POSTED TO LBSIS		DRAWN BY JFS		APPROVED BY JS	
0 ISSUED FOR CONSTRUCTION	16/05/09	HOR. SCALE AS NOTED		RELEASED FOR CONSTRUCTION	
NO. REVISIONS	DATE	VERTICAL AS NOTED	DATE 2016 02 29	DATE 2016-05-09	

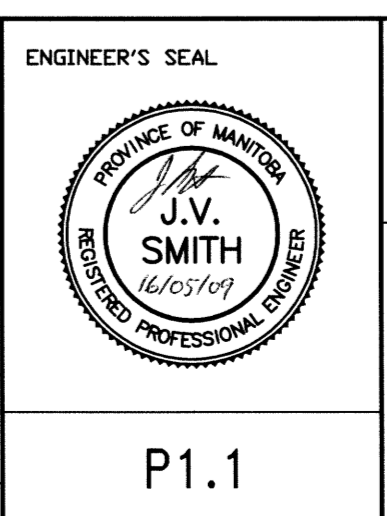

**THE CITY OF WINNIPEG**  
 WATER AND WASTE DEPARTMENT  
 WEWPC FW PIPE REPLACEMENT  
**MECHANICAL**  
 FLUSHING WATER PIPE REPLACEMENT  
 CONSTRUCTION PHASE 1  
 PIPING AND INSTRUMENTATION DIAGRAM

SHEET 1 OF 1  
 CITY DRAWING NUMBER  
 1-0103S-P0023-001