


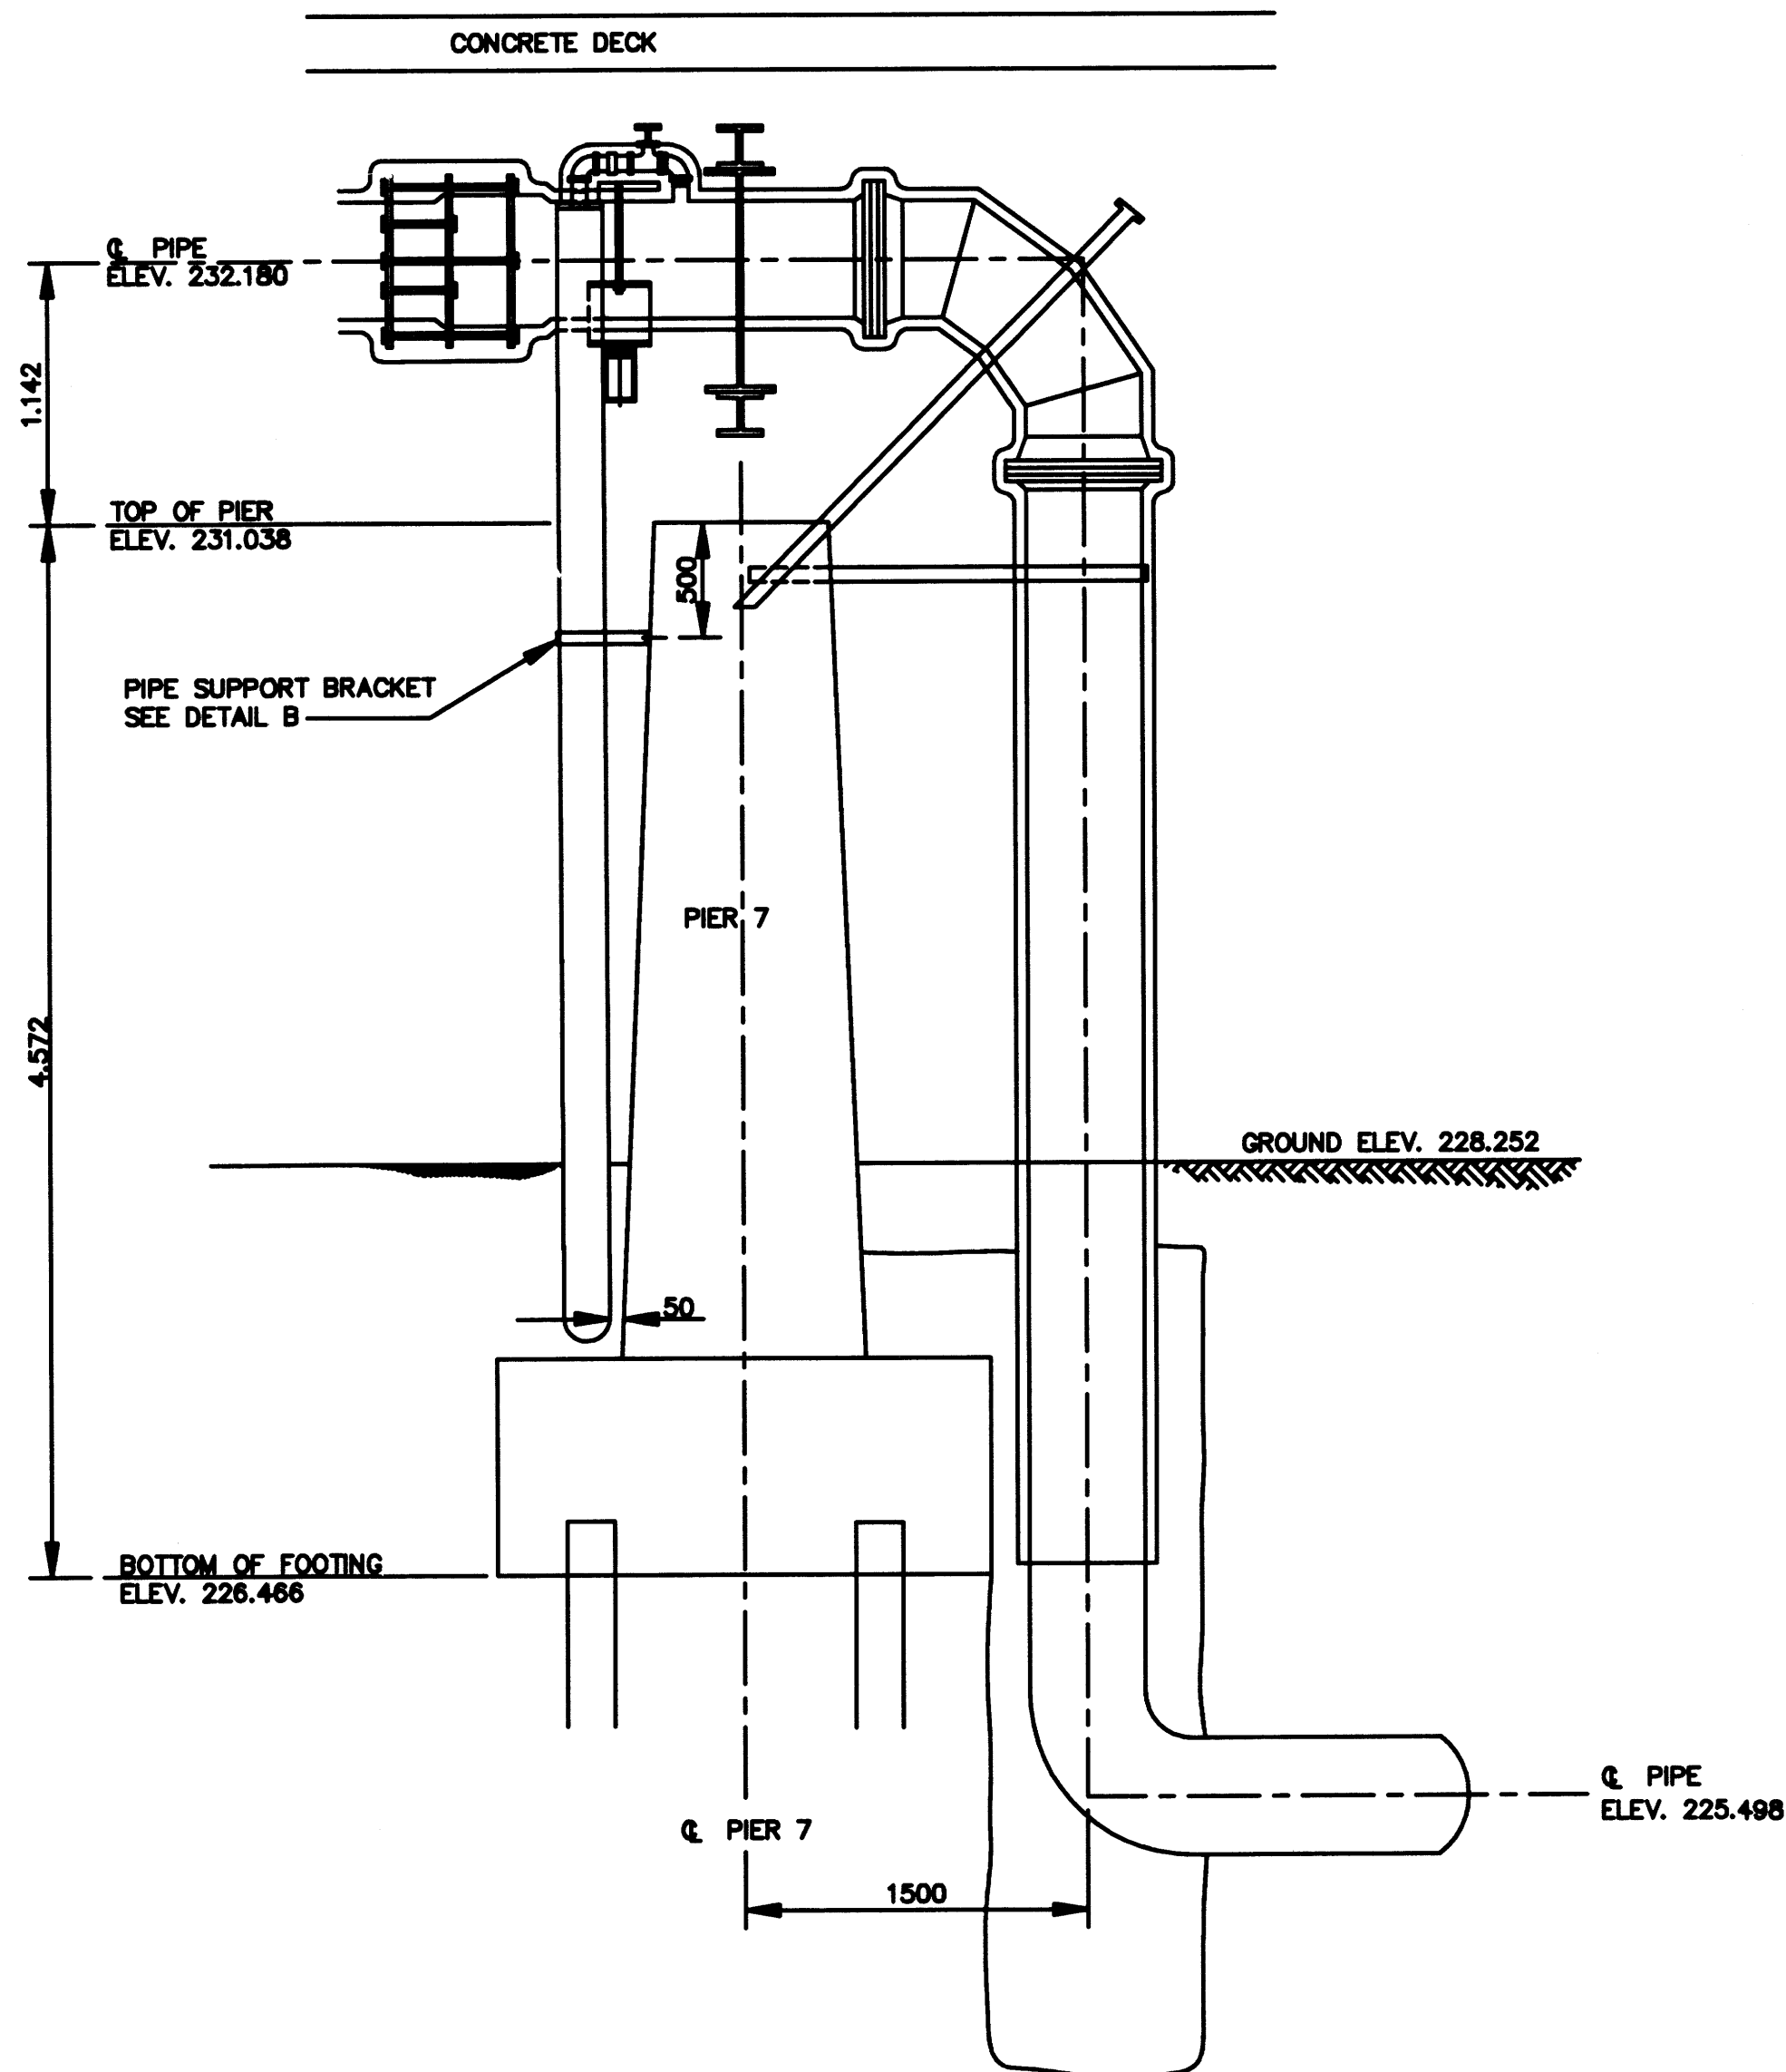


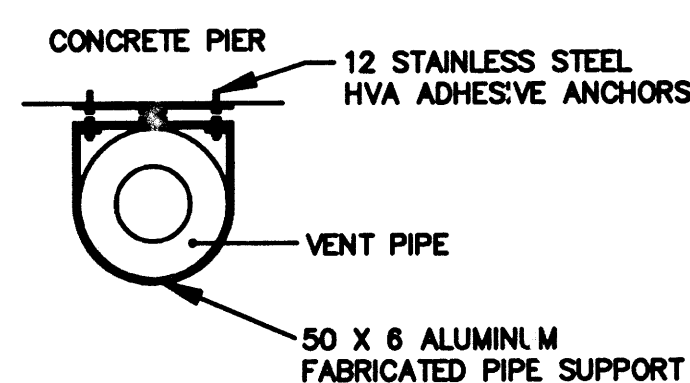


DETAIL
SCALE 1:30

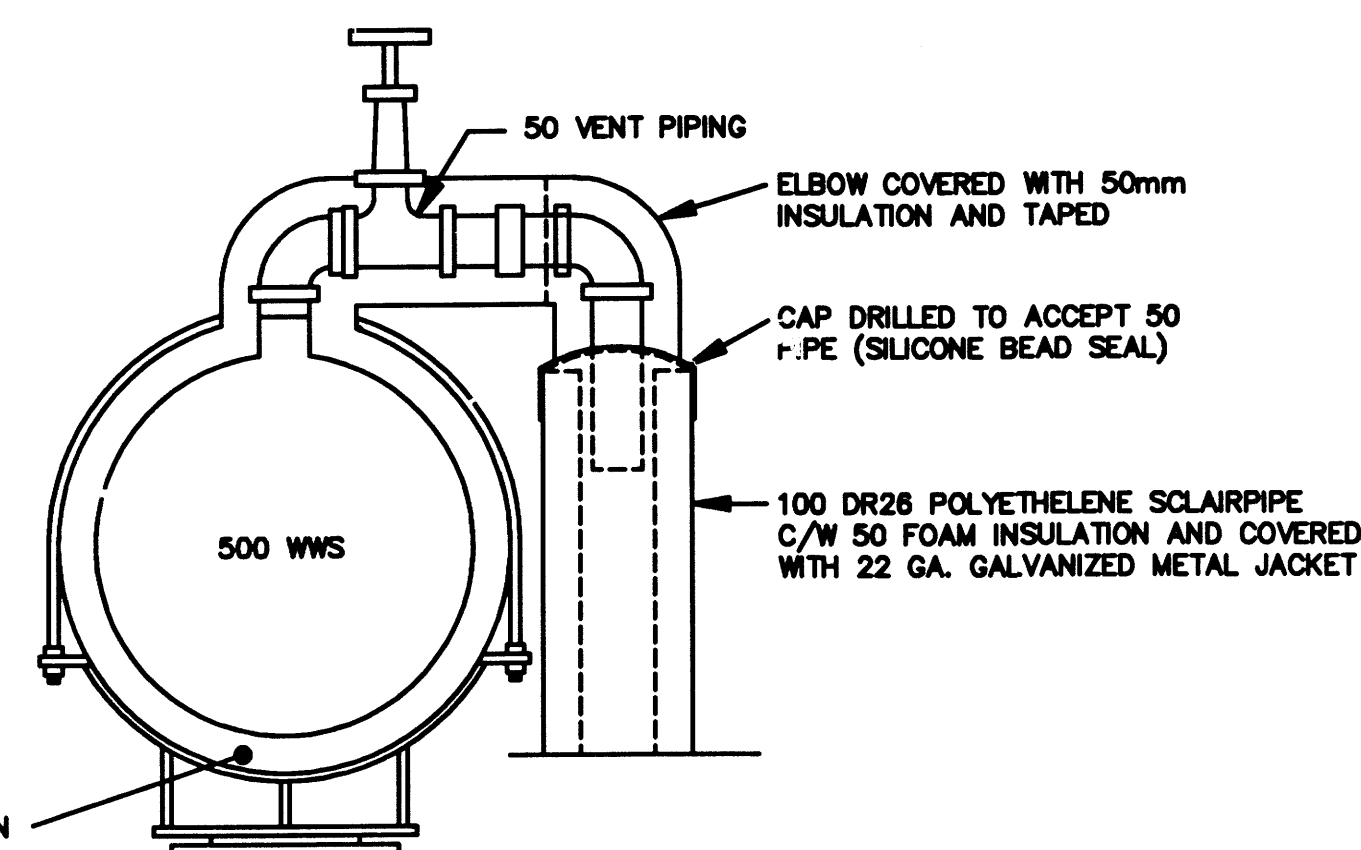

DETAIL "B"
SCALE 1:10

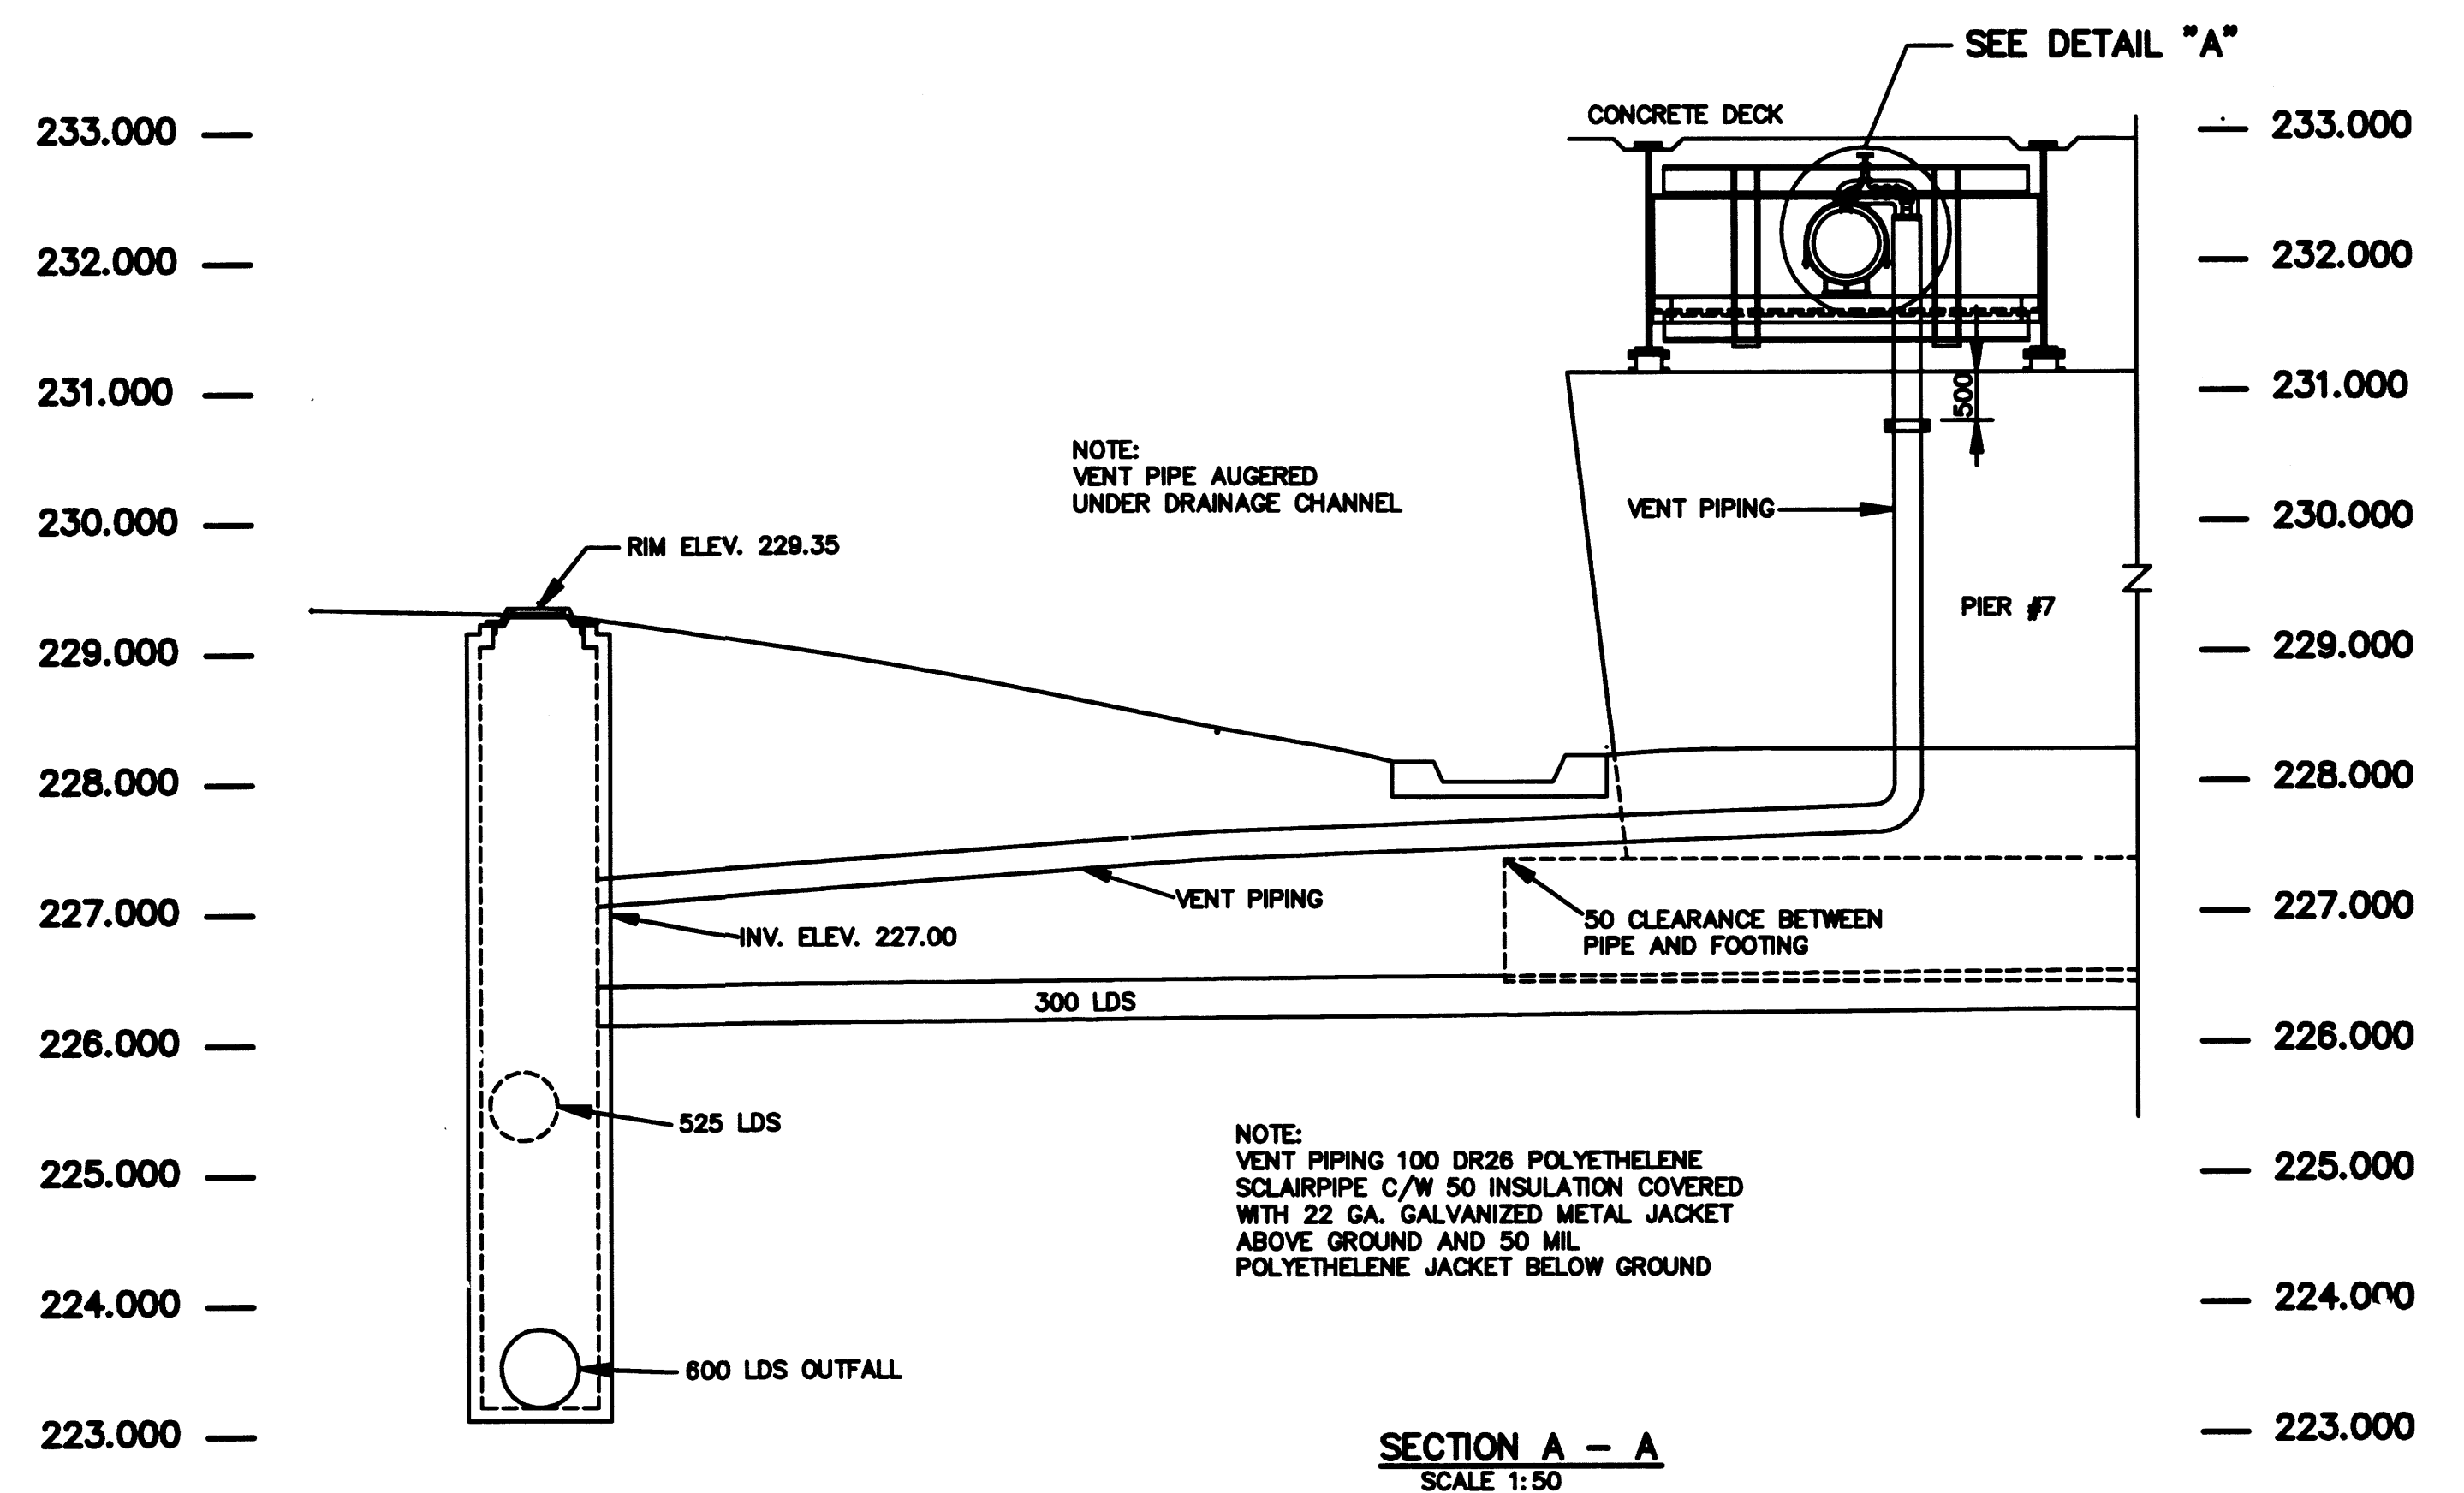

DETAIL "A"
SCALE 1:10

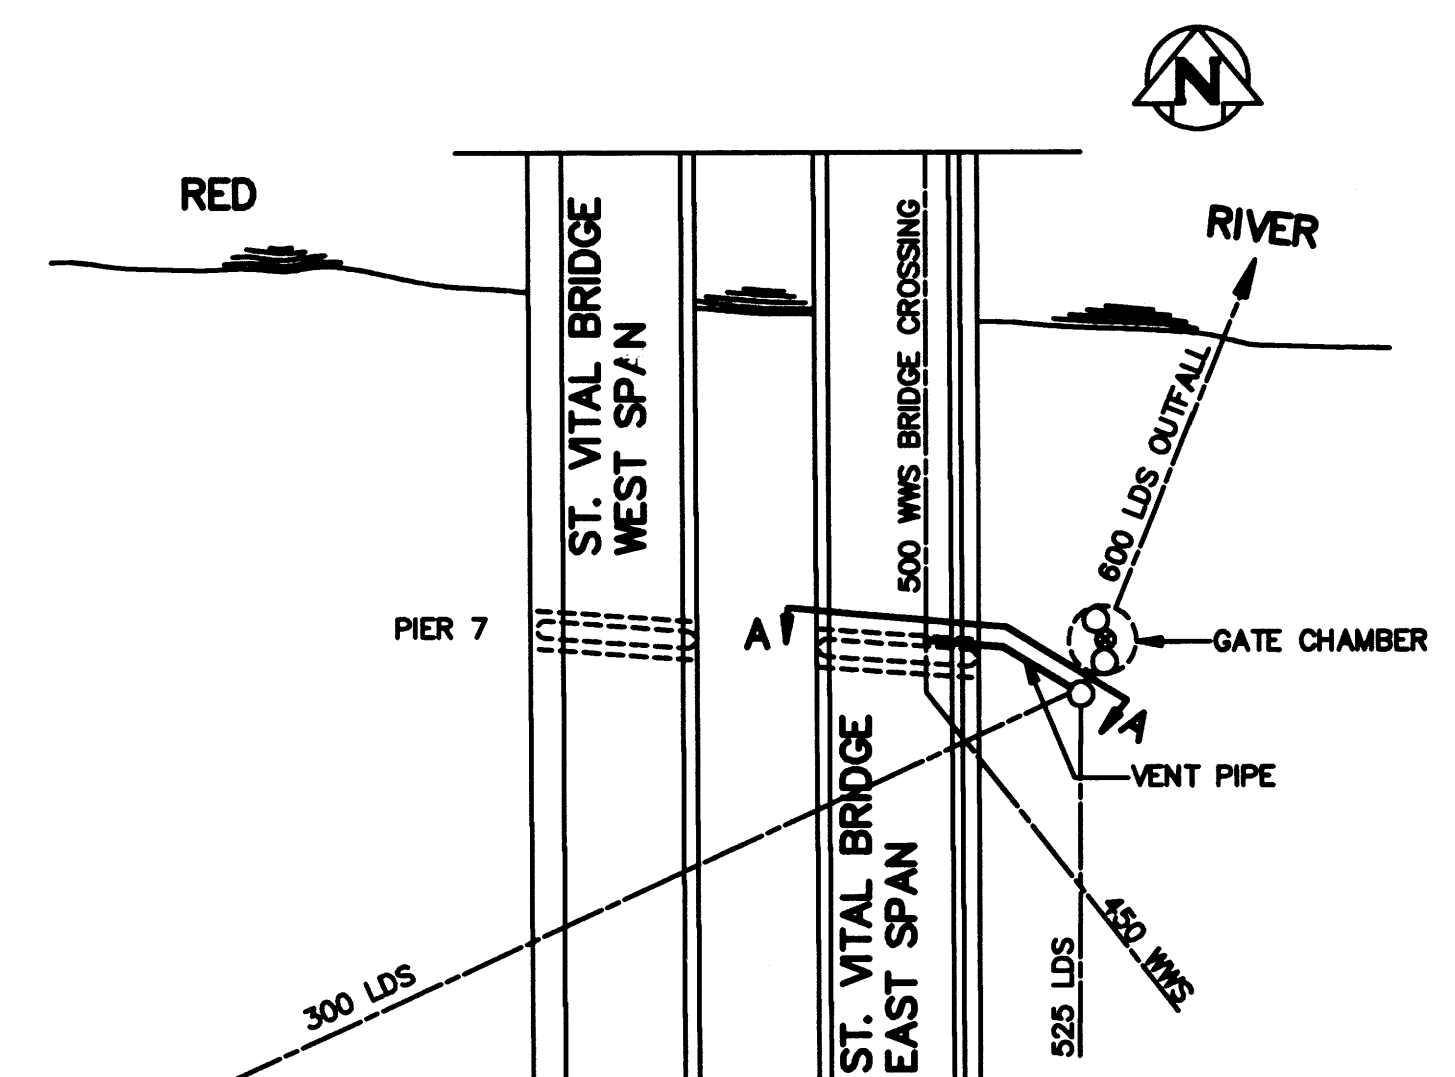

 
SITE PLAN
SCALE 1:500

AS-CONSTRUCTED

LaBonte John E. Jr. 9.2.07.08

INSPECTION / SURVEY TECHNICAL SERVICES DATE

WATERWORKS, WASTE & DISPOSAL DEPARTMENT

B.M. ELEV.								ENGINEER'S SEAL 				 THE CITY OF WINNIPEG WORKS AND OPERATIONS DIVISION WATERWORKS WASTE AND DISPOSAL DEPARTMENT																			
				DESIGNED BY JE		CHECKED BY JE		APPROVED BY <i>R.M. McCreary</i> <i>92.01.03</i>				BALTIMORE FORCEMAIN VENT PIPING AT PIER 7 ST. VITAL BRIDGE				SHEET 1 OF 1															
				DRAWN BY EN												CITY DRAWING NUMBER															
				HOR. SCALE AS NOTED				RELEASED FOR CONSTRUCTION <i>R.M. McCreary</i>																							
1	REVISED TO "AS BUILT"			06/92	EN	VERTICAL								1351																	
NO.	REVISIONS			DATE	BY	DATE OCTOBER 1991				DATE 92.01.03/				CONSULTANT DRAWING NO.																	
BALTIMORE FORCEMAIN																VENT PIPING AT PIER 7 ST. VITAL BRIDGE															

file # FAV 0117