


WET WELL PLAN
SCALE: 1 : 20

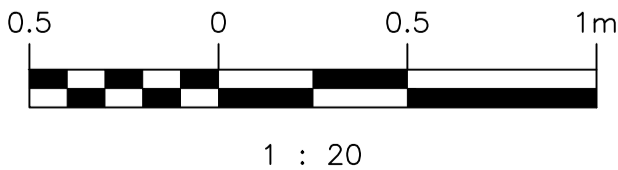

DEMOLITION NOTES:


- (A) DEMOLISH ALL EXISTING LIGHT FIXTURES, INCLUDING THE EMERGENCY LIGHTING FIXTURES, AND ASSOCIATED CABLING, CONDUIT, AND CONTROLS.
- (B) DEMOLISH ALL EXISTING WET WELL LEVEL SWITCHES. RETAIN EXISTING CONDUIT FOR RE-USE.

CONSTRUCTION NOTES:

- (1) PROVIDE AND INSTALL NEW LED LIGHT FIXTURE.
- (2) PROVIDE AND INSTALL NEW ULTRASONIC LEVEL TRANSMITTER SENSOR THROUGH HOLE PENETRATION ON MAIN FLOOR.
- (3) PROVIDE AND INSTALL NEW WET WELL LEVEL SWITCHES. REFER TO THE 'WET WELL LEVEL SWITCHES' DETAIL ON THIS DRAWING.

LEGEND:

- EXISTING
- NEW WORK
- - - DEMOLISH

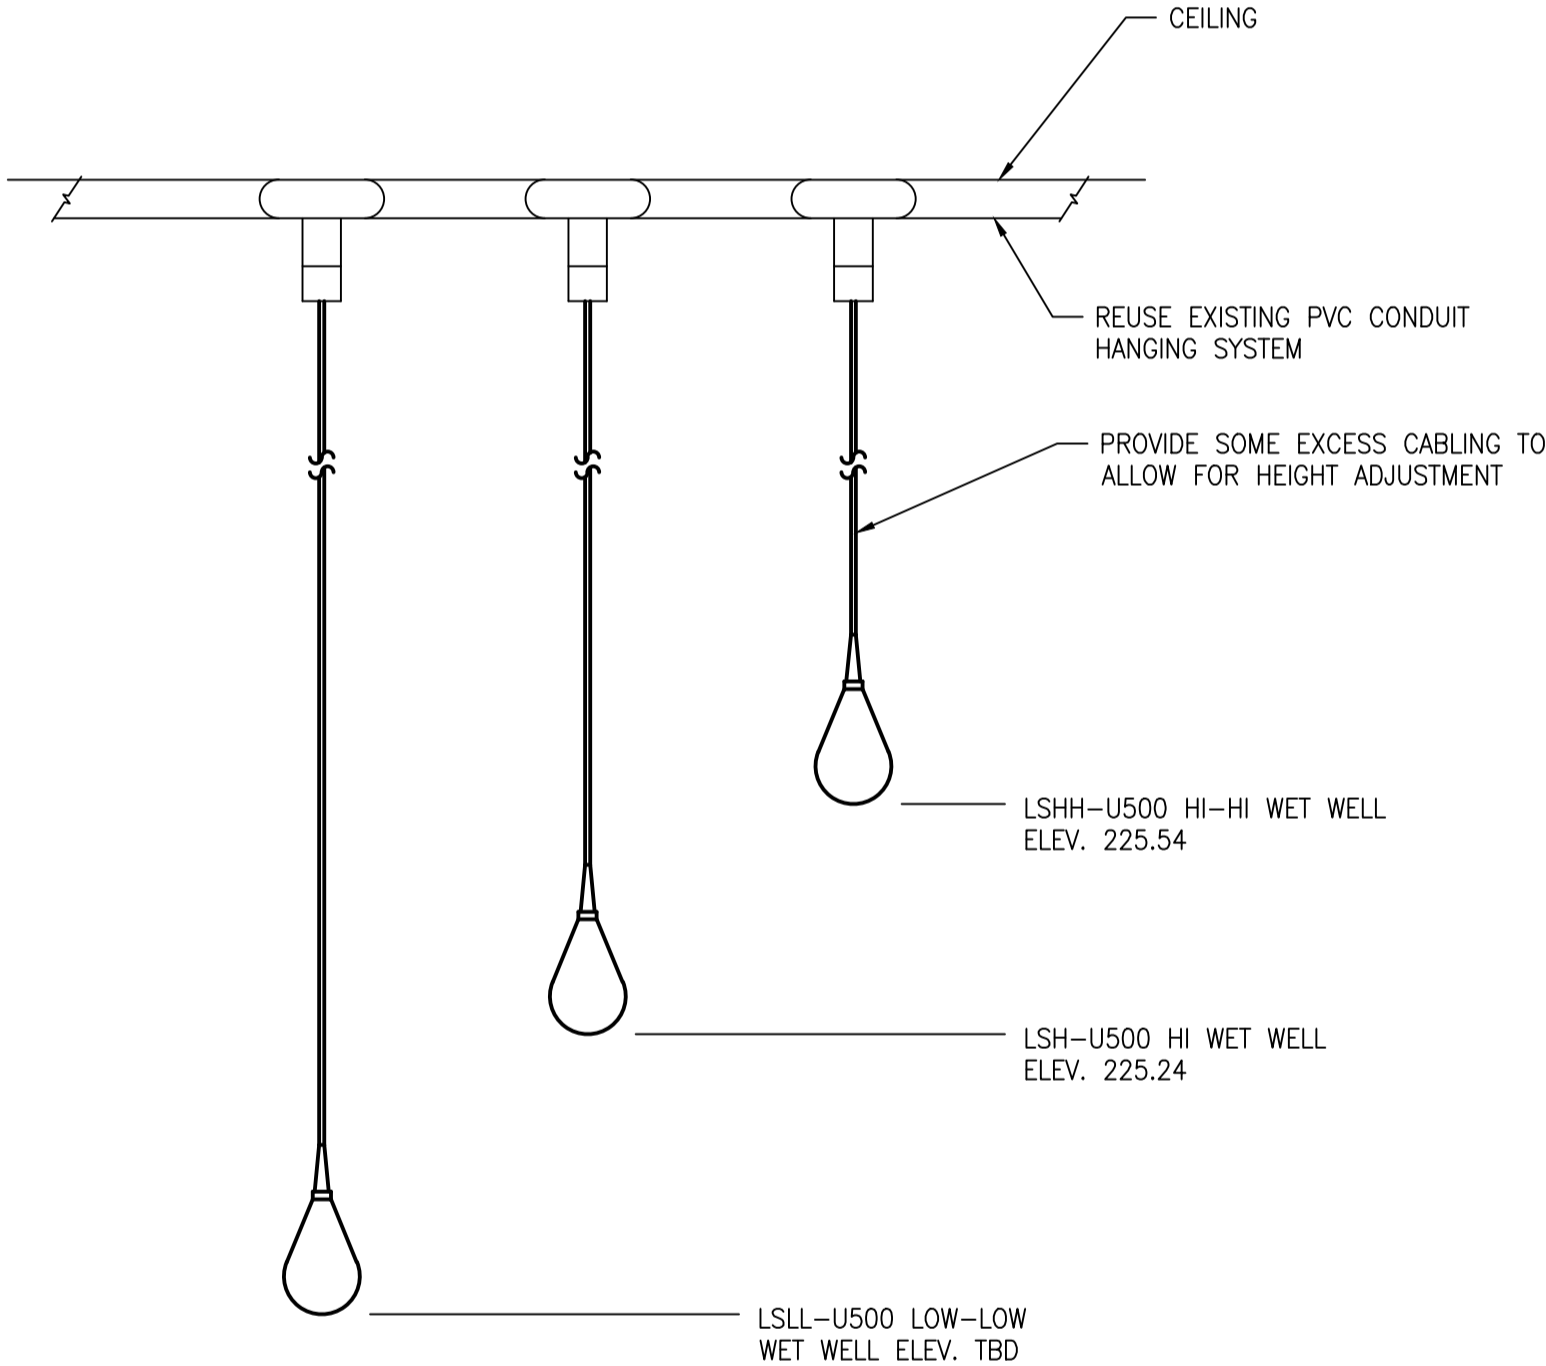

WET WELL LEVEL SWITCHES
SCALE: N.T.S.

DRAWING NUMBER	REFERENCE DRAWINGS

00	ISSUED FOR TENDER, BID OPP: 475-2018	2018/05/09	BC	PP	
NO.	REVISIONS	DATE	DESIGN	CHECK	

 SNC-LAVALIN INC. 148 Nature Park Way Winnipeg, MB, Canada R3P 0X7 204-786-8080	
DESIGNED BY: B. CLEVEN	CHECKED BY: P. PANUFNIK
DRAWN BY: Y. KONIG	APPROVED BY: B. CLEVEN
SCALE: 1:20	ISSUED FOR CONSTRUCTION BY: DATE:
DATE: 2017/08/15	
CONSULTANT NO.:	

ENGINEER'S SEAL

PRELIMINARY
NOT TO BE
USED FOR
CONSTRUCTION

 THE CITY OF WINNIPEG WATER AND WASTE DEPARTMENT			
METRO ROUTE 20 UNDERPASS PUMPING STAION 2018 UPGRADES ELECTRICAL AND LIGHTING PLAN LAYOUT WET WELL			
CITY DRAWING NUMBER 1-0309U-E0005	SHEET 001	REV. 00	SIZE A1