



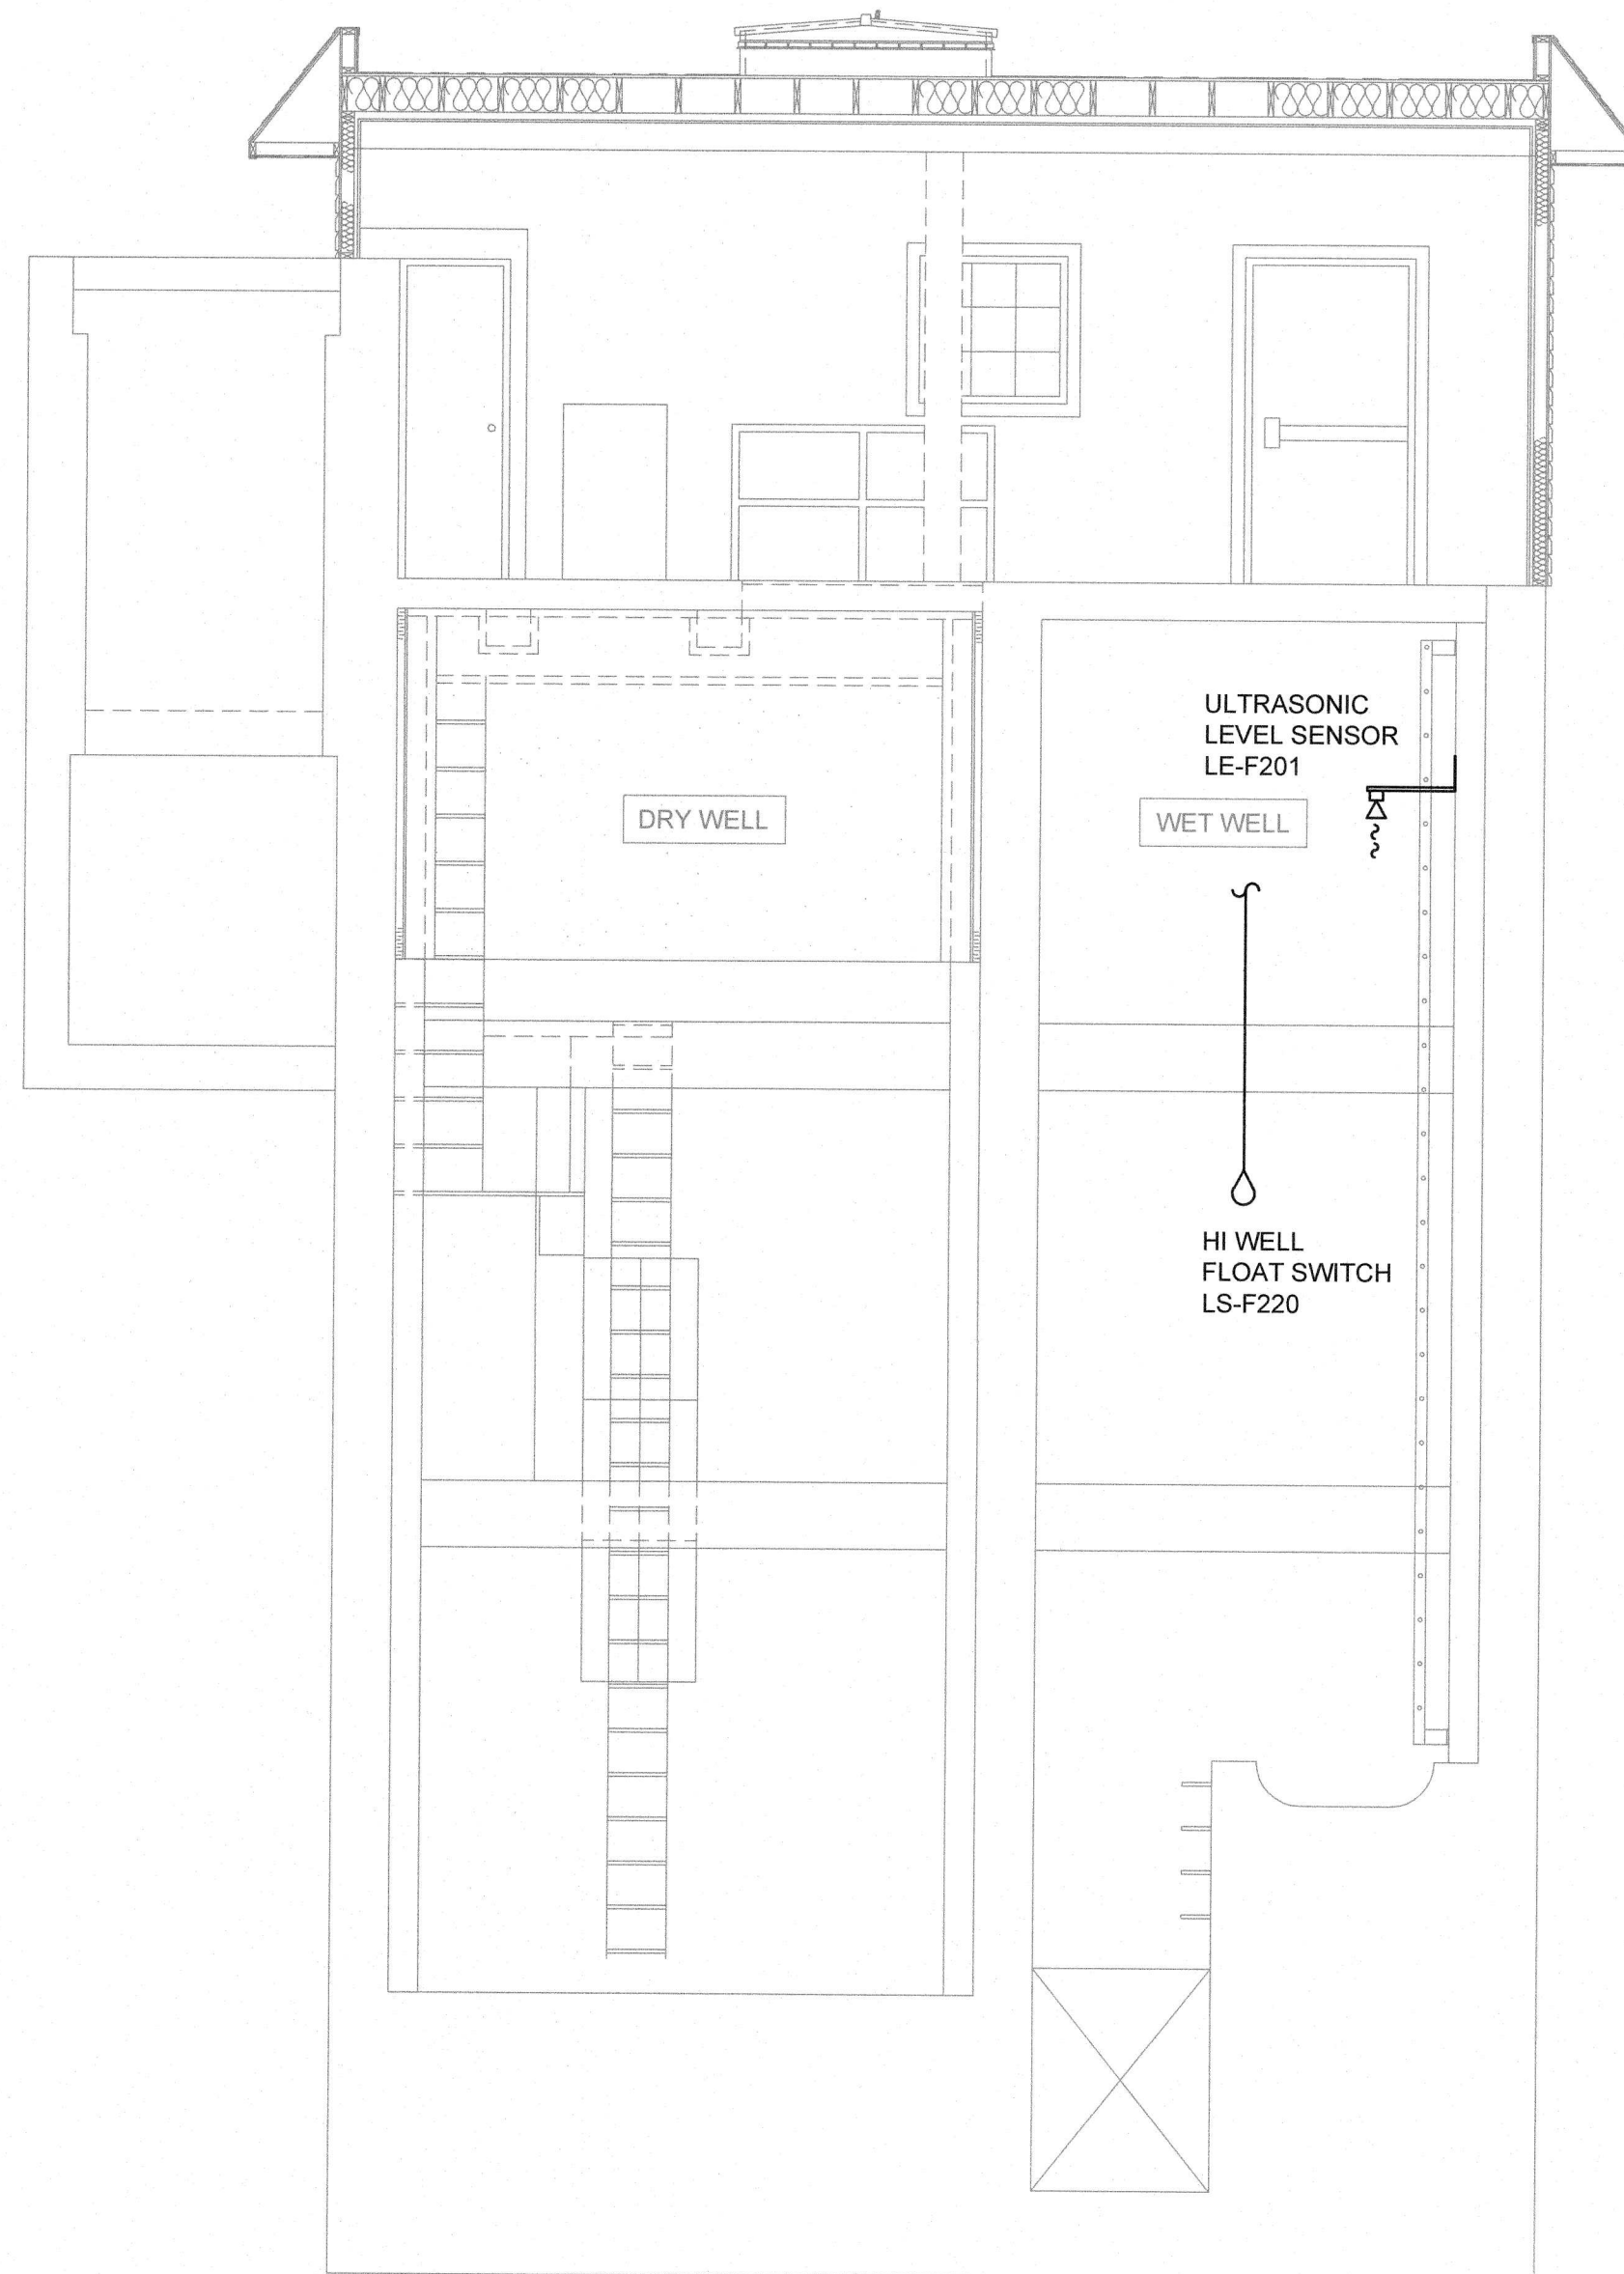

4 SECTION
E0002 E0003 1:50

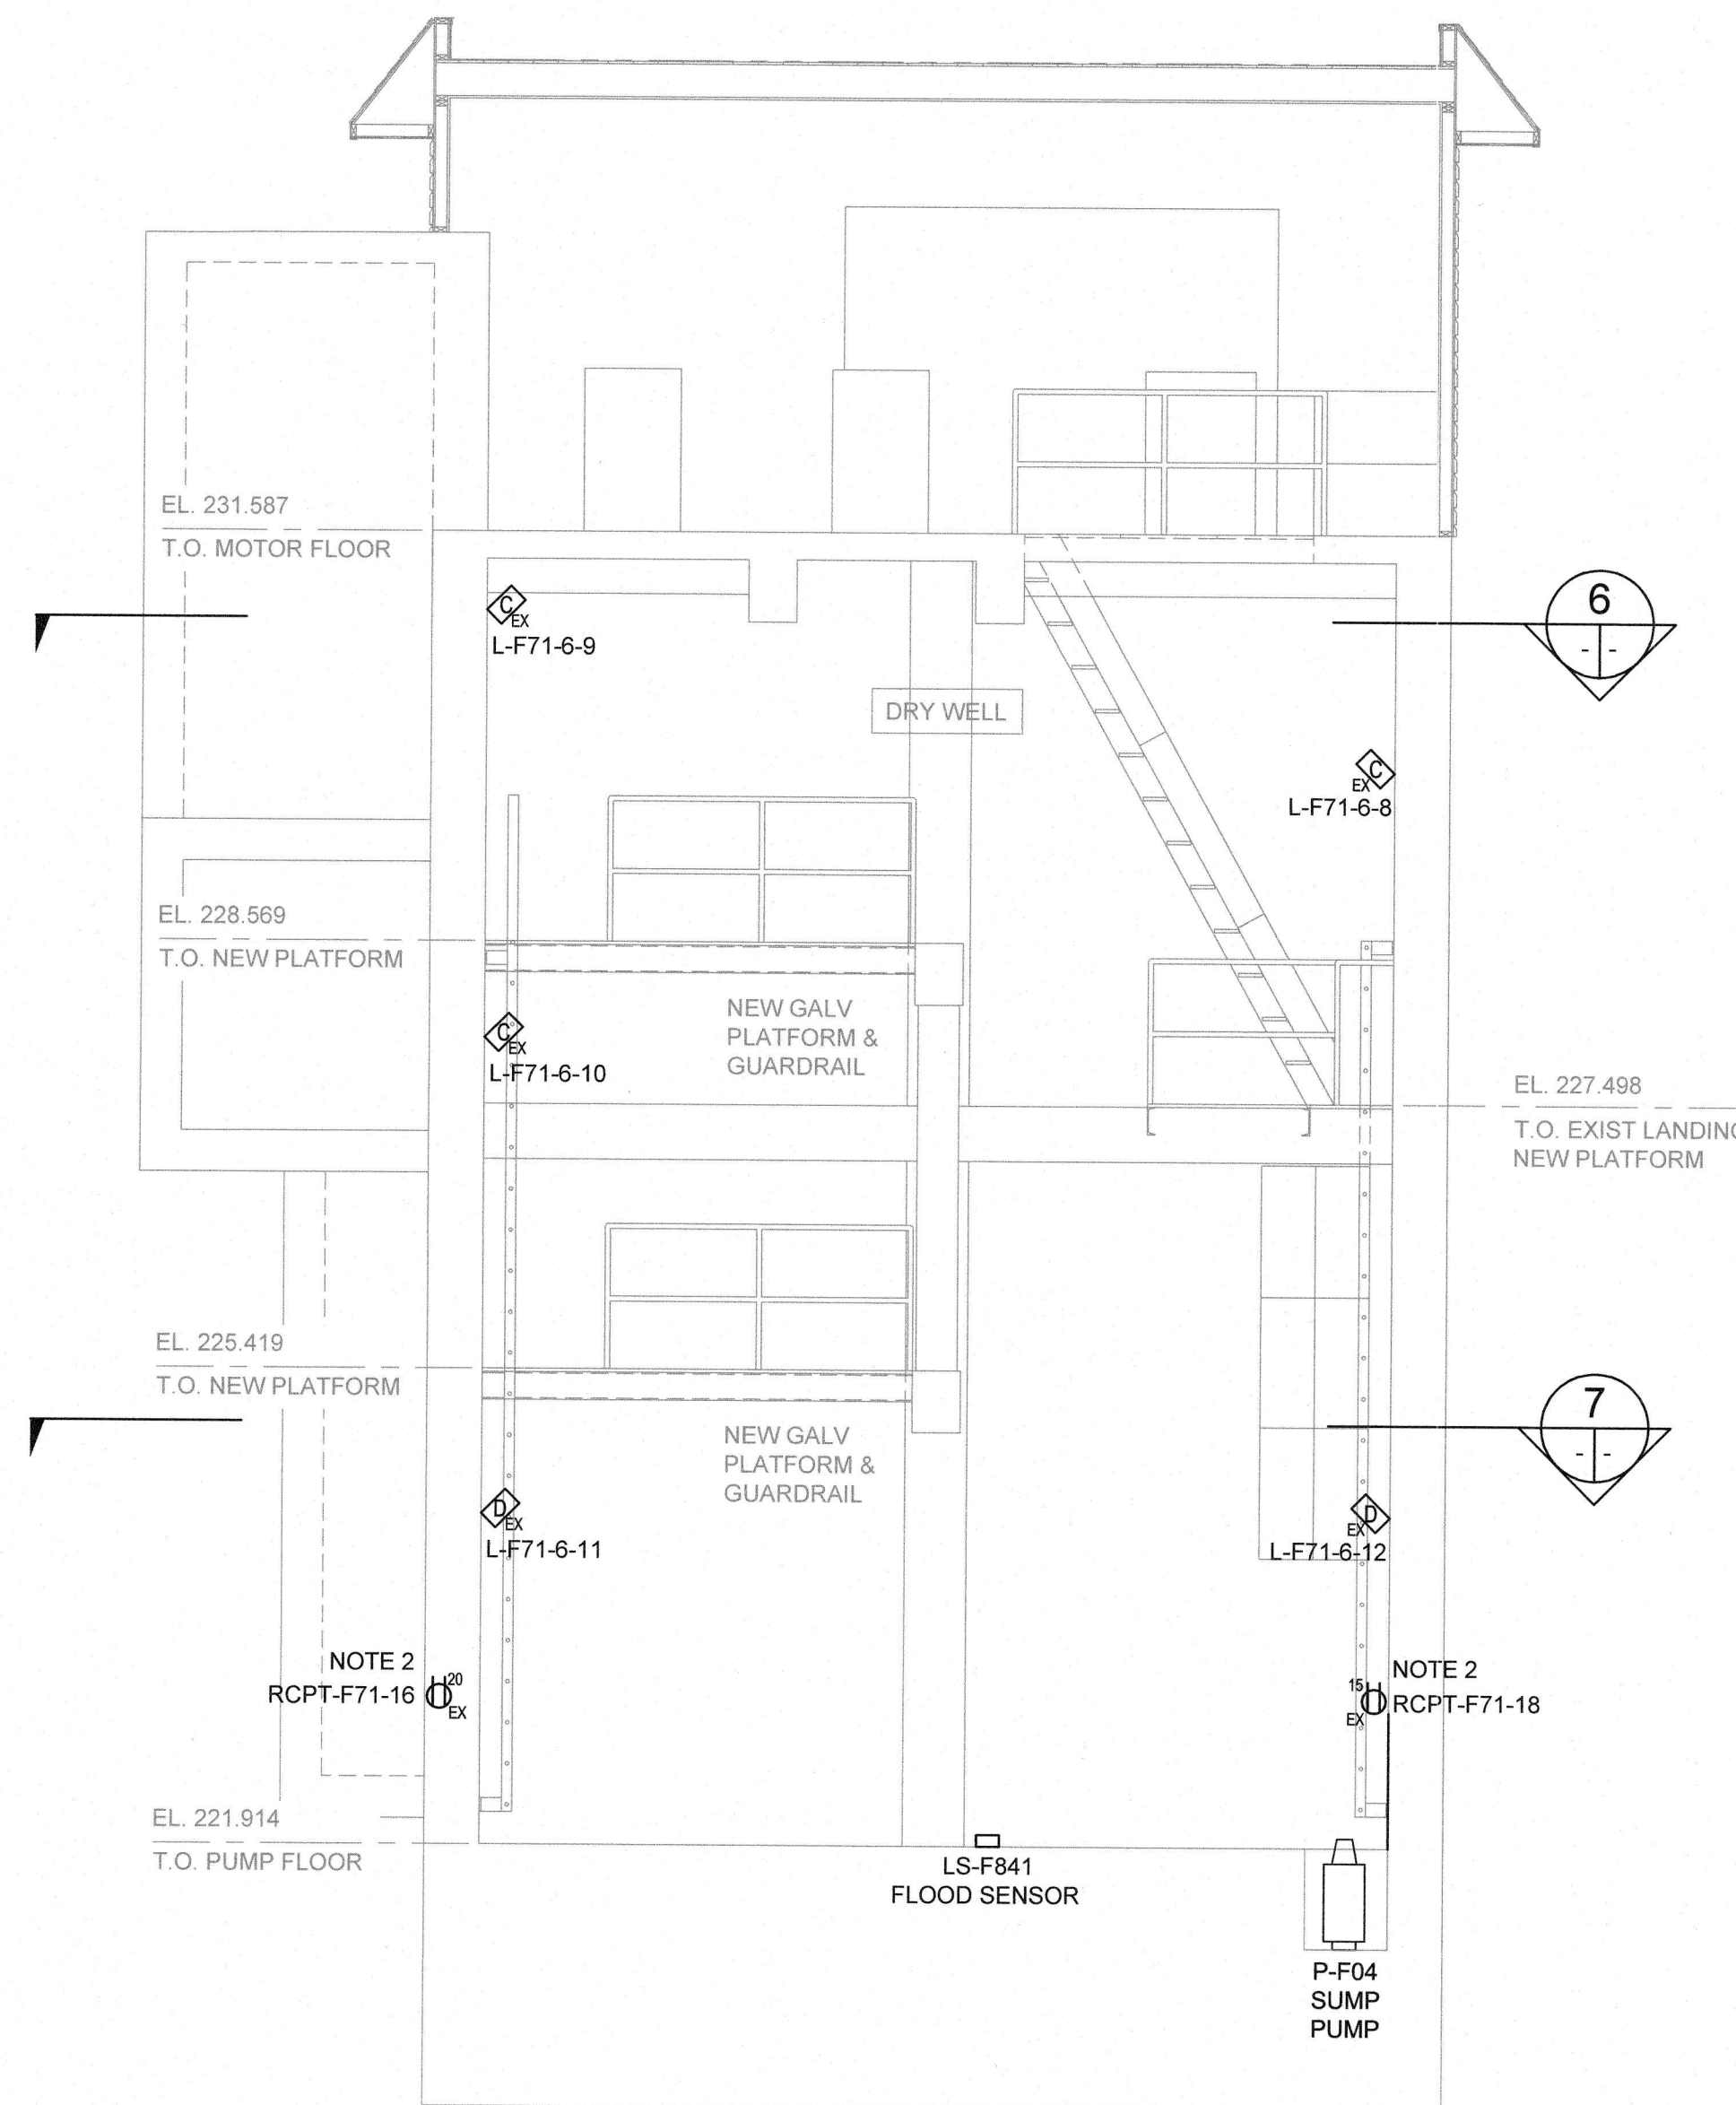


5 SECTION
E0002 E0003 1:50


- NOTES:
1. LIGHT FIXTURE L-F71-6-10 IS IN THE SIMILAR LOCATION BUT BELOW THE UPPER PLATFORM.
 2. RECEPTACLES TO BE INSTALLED AT 1000mm A.F.F.

LEGEND

A_{EX} LIGHT FIXTURE TYPE A
'EX' DENOTES EXPLOSION PROOF

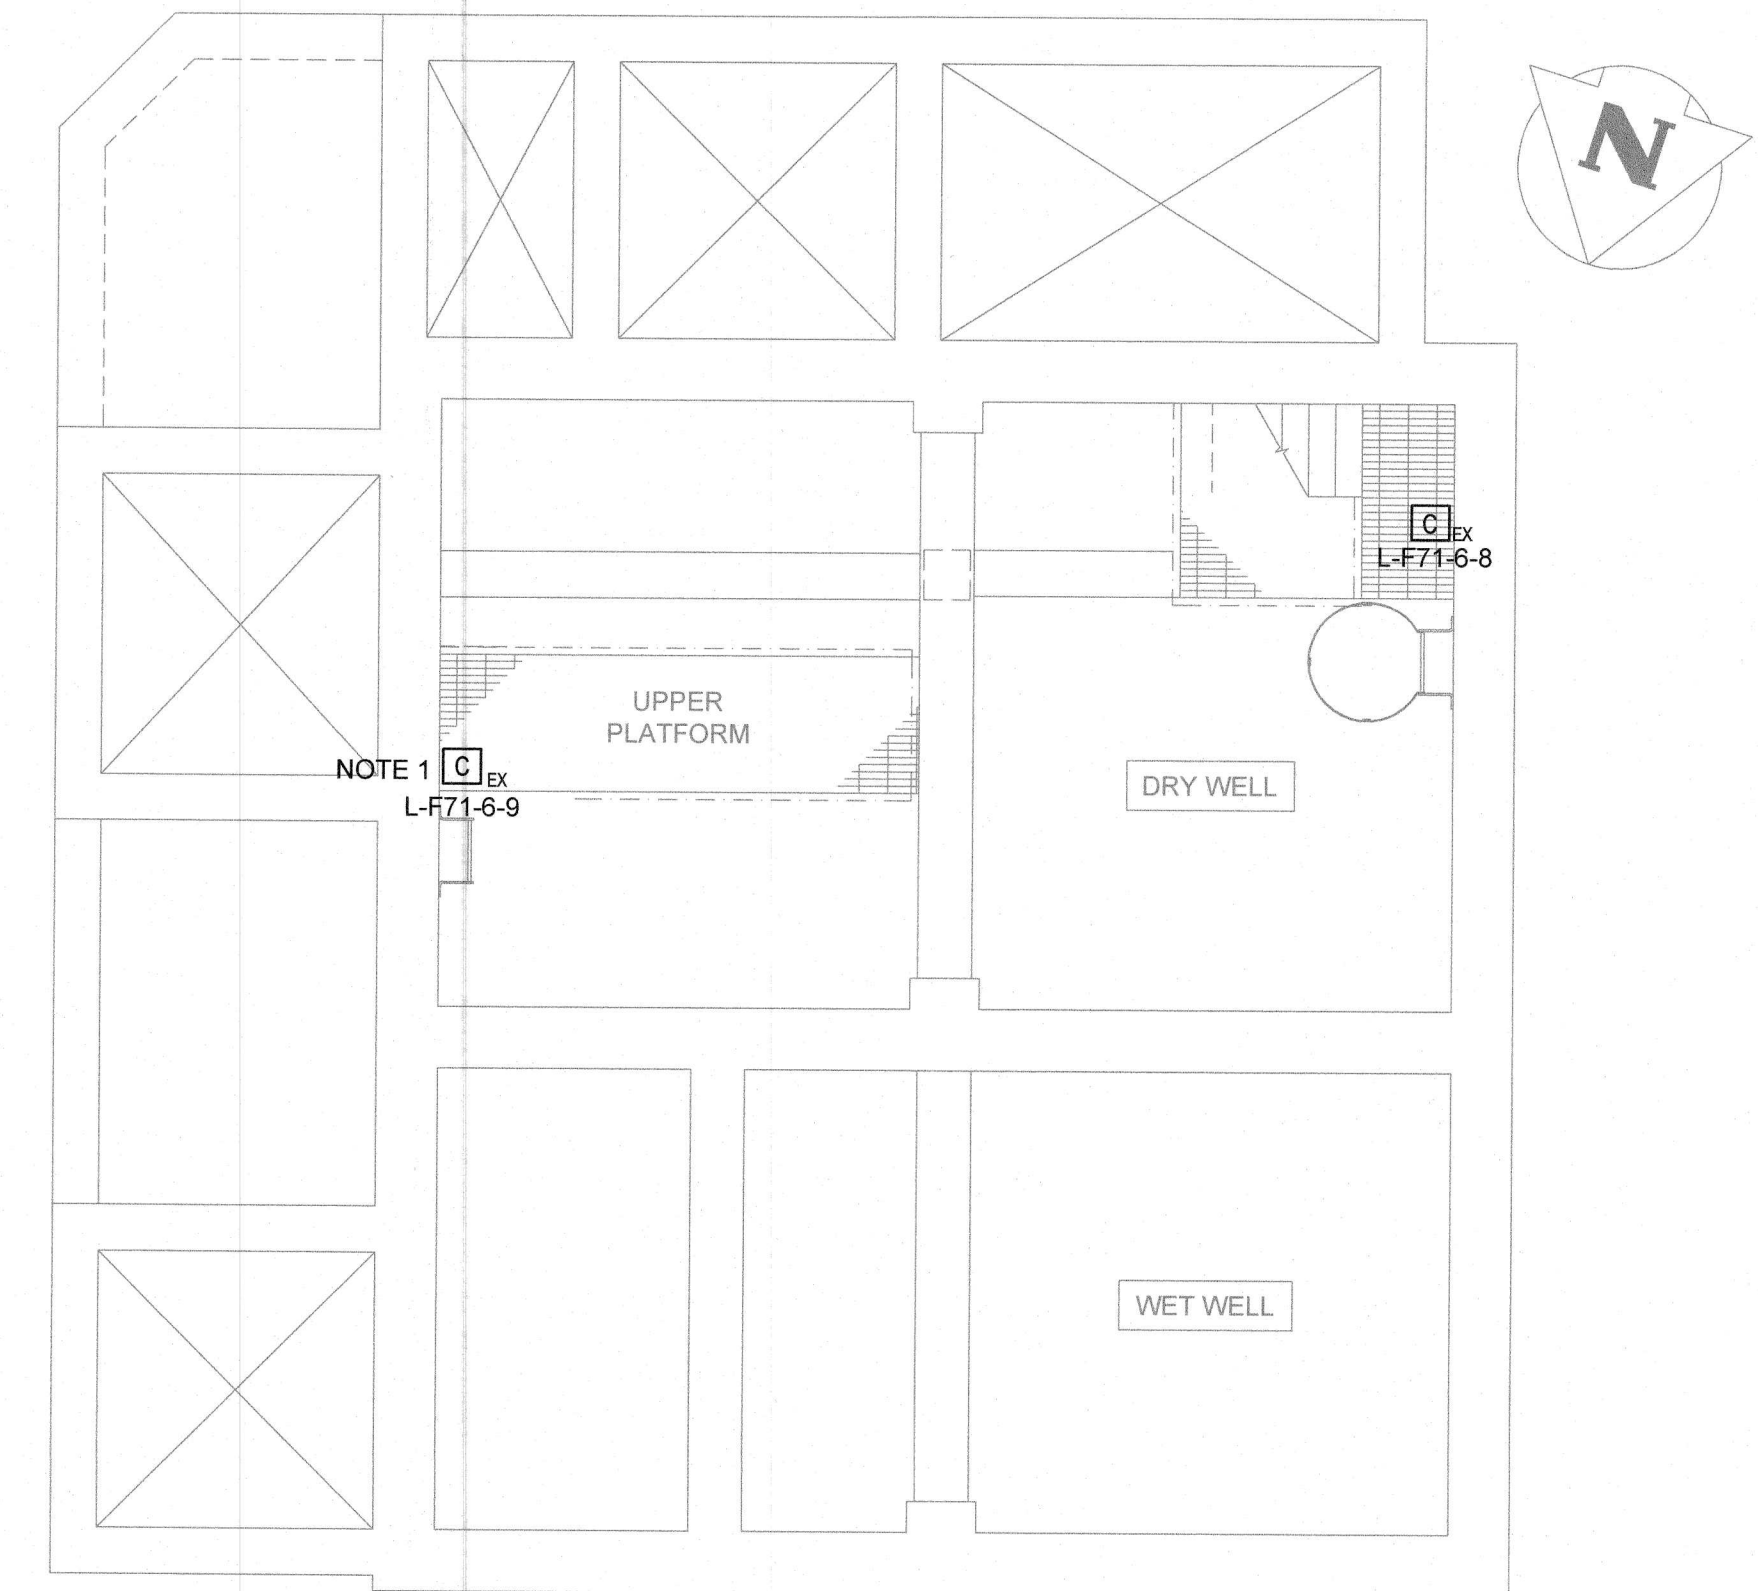

6 DRY/WET WELL PLAN
1:50
T.O. PUMP FLOOR @ EL. 227.498

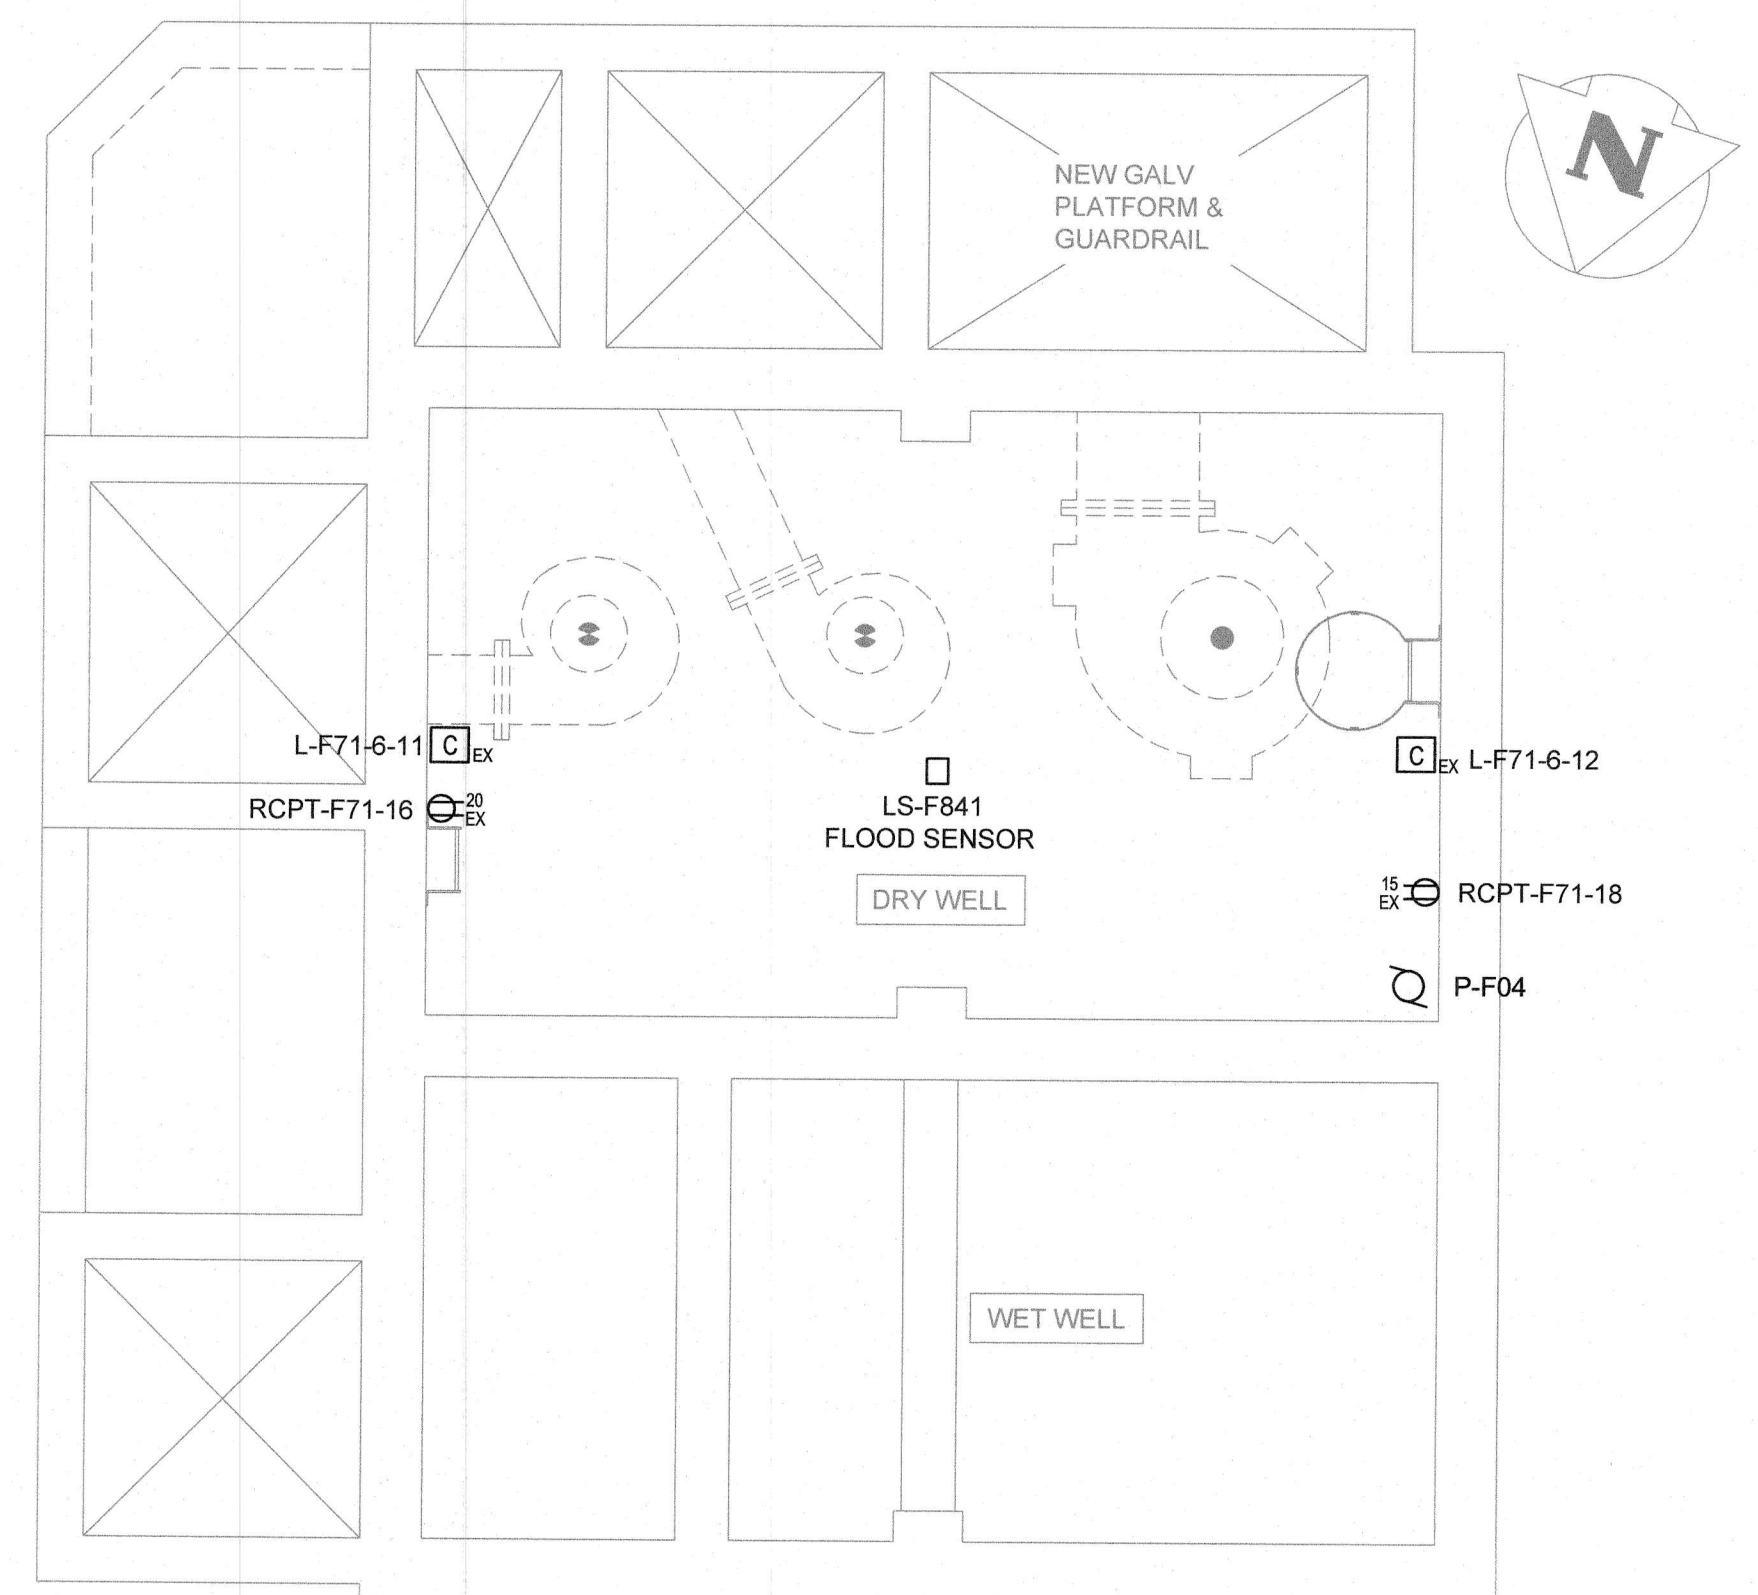

7 DRY/WET WELL PLAN
1:50
T.O. PUMP FLOOR @ EL. 221.914

1:50
1 0 1 2m




THE INFORMATION CONTAINED ON THIS DRAWING HAS BEEN PREPARED SOLELY FOR THE OWNER FOR USE ON THIS PROJECT AND IS COPYRIGHTED. ANY UNAUTHORIZED USE OF THIS INFORMATION IS A BREACH OF COPYRIGHT AND WILL BE PURSUED AS SUCH. USE OF THE INFORMATION ON THIS DRAWING IN WHOLE OR IN PART OTHER THAN FOR THE INTENDED PURPOSE IS AT THE SOLE RISK OF THE USER.

LOCATION APPROVED
UNDERGROUND STRUCTURES

SUPR. U/G STRUCTURES DATE
COMMITTEE
NOTE:
LOCATION OF UNDERGROUND STRUCTURES AS SHOWN ARE BASED ON THE BEST INFORMATION AVAILABLE BUT NO GUARANTEE IS GIVEN THAT ALL EXISTING UTILITIES ARE SHOWN OR THAT THE GIVEN LOCATIONS ARE EXACT. CONFIRMATION OF EXISTENCE AND EXACT LOCATION OF ALL SERVICES MUST BE OBTAINED FROM THE INDIVIDUAL UTILITIES BEFORE PROCEEDING WITH CONSTRUCTION.

NO.	REVISIONS	DATE	BY	TL
00	ISSUED FOR TENDER	18.08.02		

DESIGNED BY	TL
CHECKED BY	
DRAWN BY	CPG
APPROVED BY	
HOR. SCALE	AS NOTED
VERTICAL	
RELEASED FOR CONSTRUCTION	
DATE	

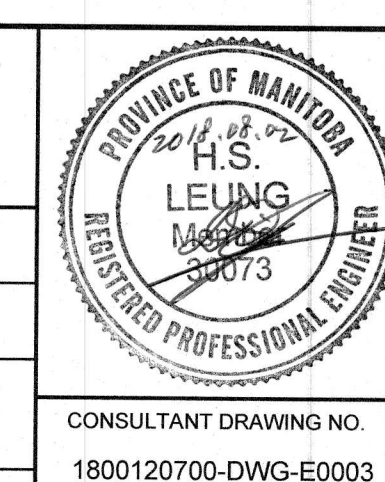

THE CITY OF WINNIPEG WATER AND WASTE DEPARTMENT	
BALTIMORE FLOOD PUMPING STATION UPGRADES	CITY DRAWING NUMBER
ELECTRICAL POWER DISTRIBUTION AND LIGHTING DRY WELL FLOOR PLANS	SHEET 15 OF 23
	E0003