


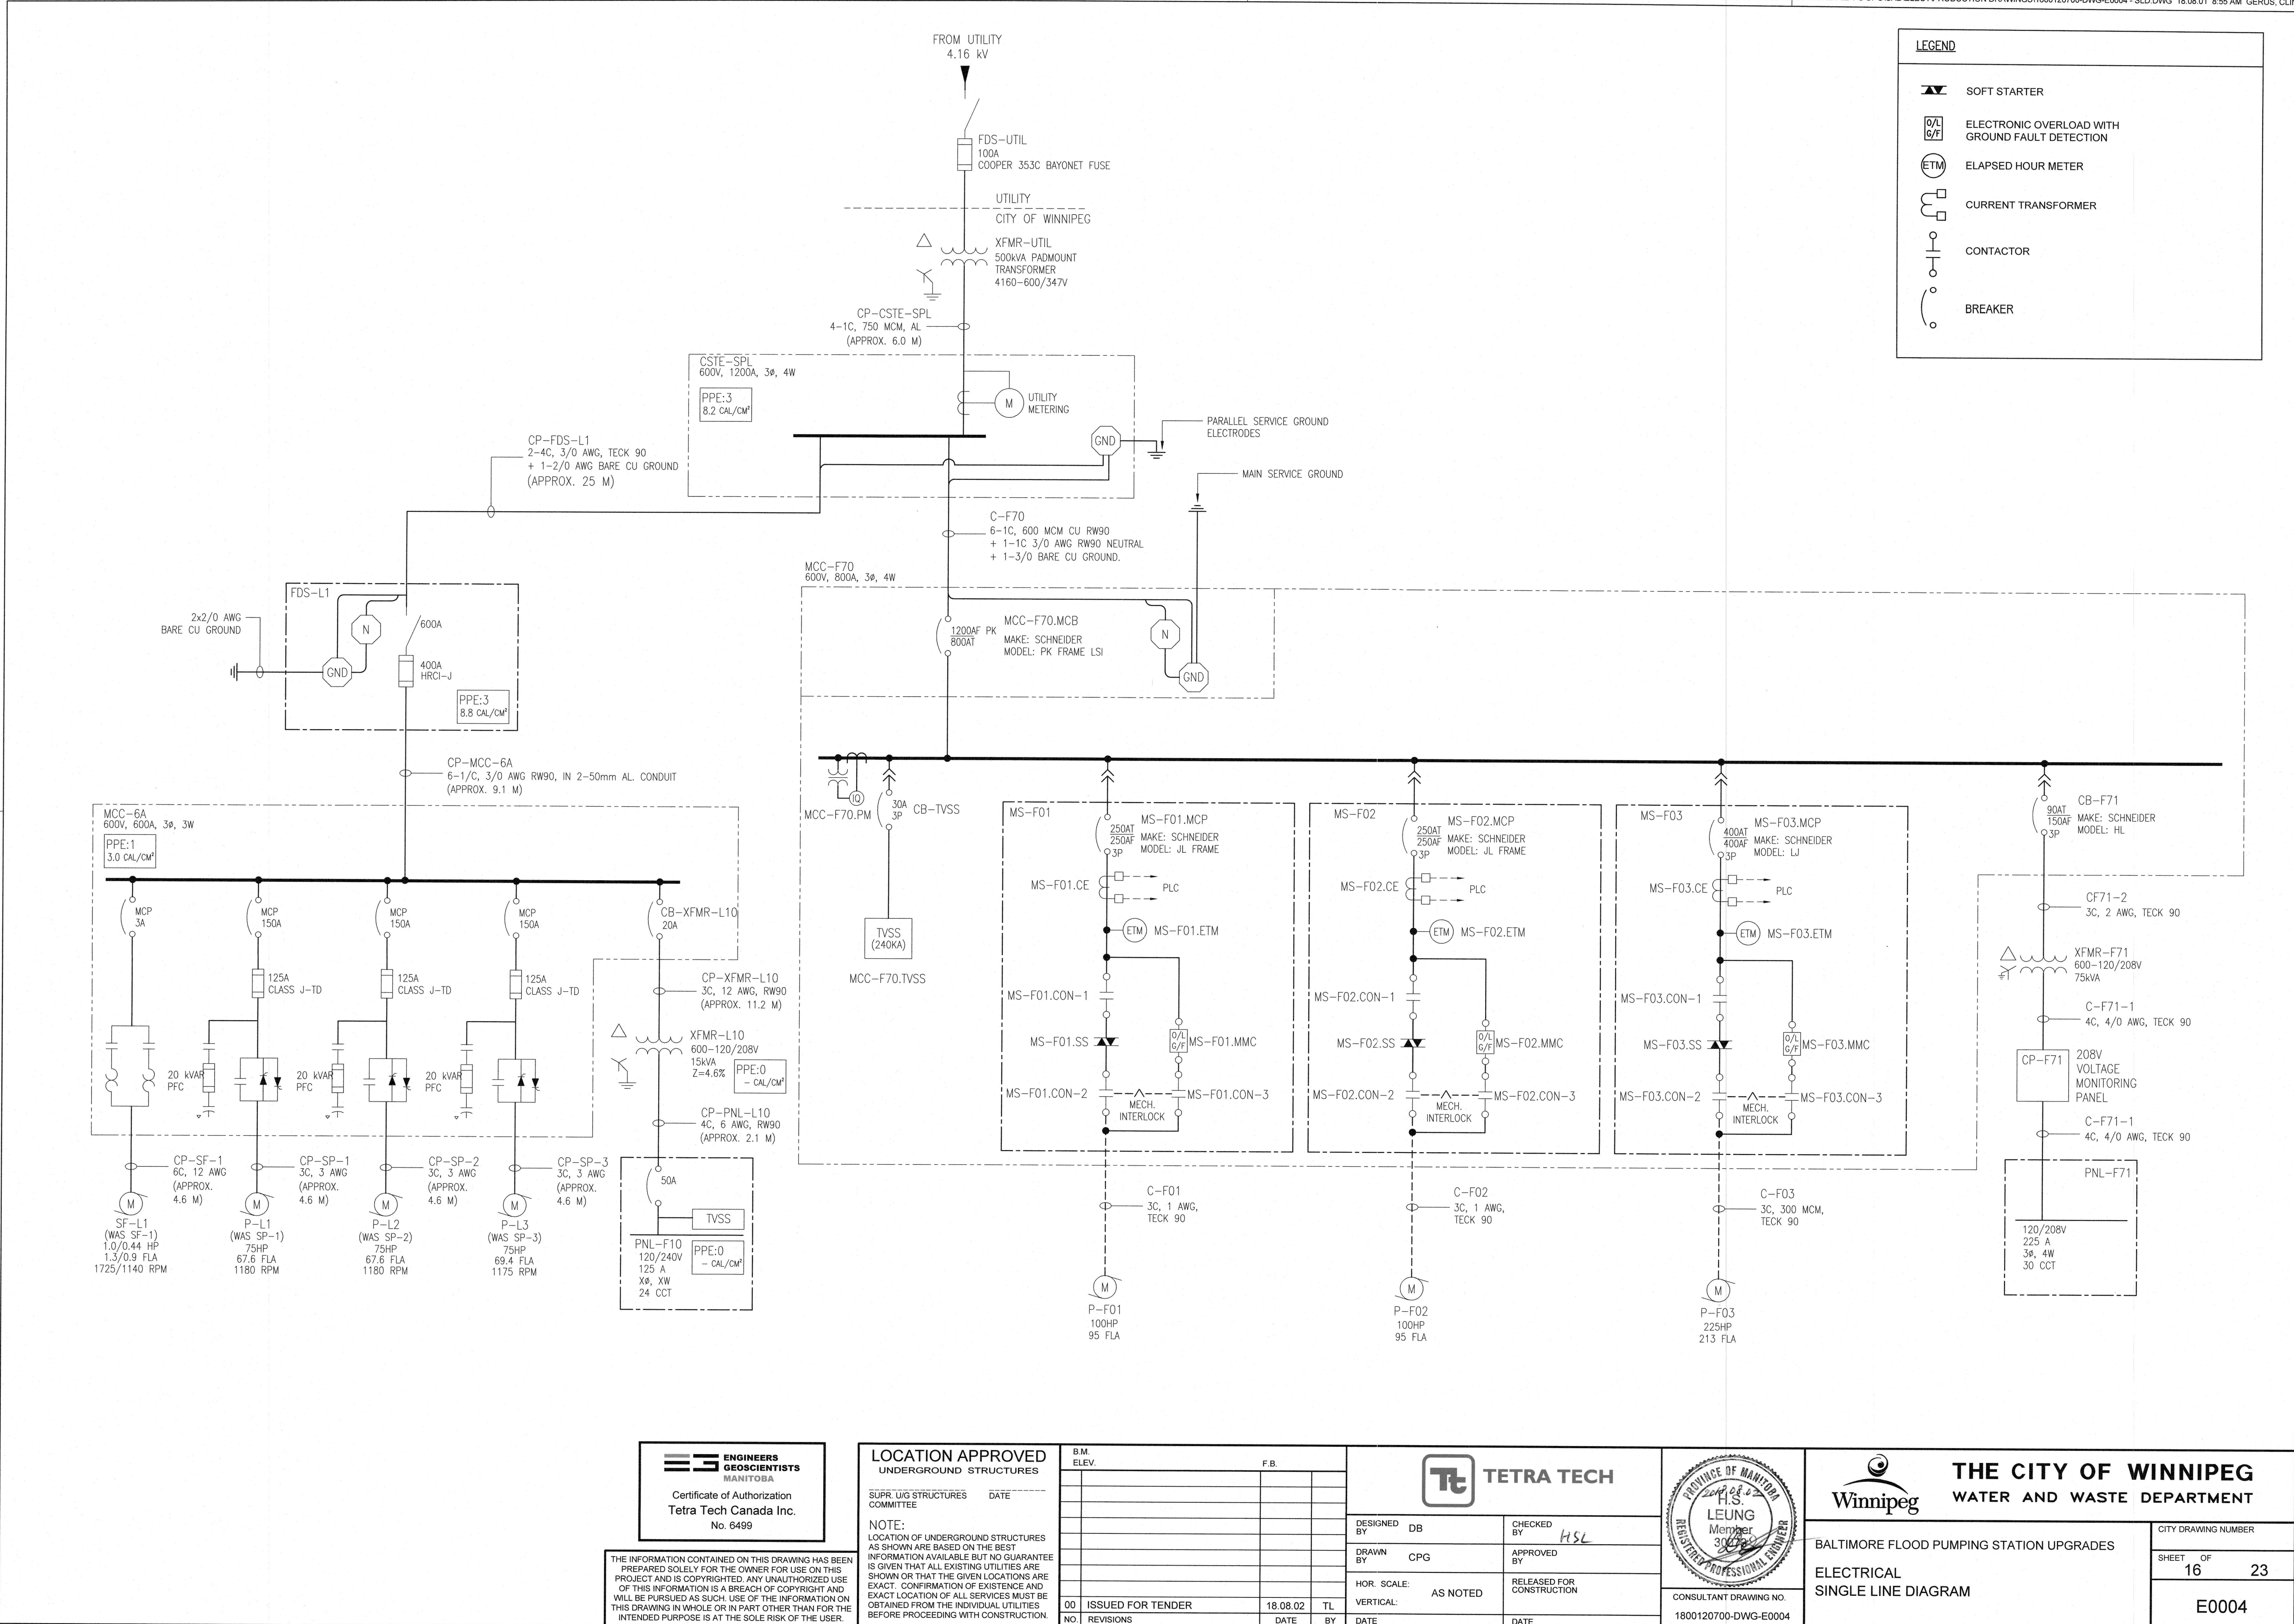

LEGEND

- SOFT STARTER
- ELECTRONIC OVERLOAD WITH GROUND FAULT DETECTION
- ELAPSED HOUR METER
- CURRENT TRANSFORMER
- CONTACTOR
- BREAKER

LOCATION APPROVED
UNDERGROUND STRUCTURES

REVISIONS

NO.	REVISIONS	DATE	BY
00	ISSUED FOR TENDER	18.08.02	TL

DESIGNED BY DB
DRAWN BY CPG
HOR. SCALE: AS NOTED
VERTICAL: AS NOTED

CHECKED BY HSL
APPROVED BY
RELEASED FOR CONSTRUCTION

CONSULTANT DRAWING NO. 1800120700-DWG-E0004

THE CITY OF WINNIPEG
WATER AND WASTE DEPARTMENT

BALTIMORE FLOOD PUMPING STATION UPGRADES
ELECTRICAL
SINGLE LINE DIAGRAM

CITY DRAWING NUMBER 16 OF 23
SHEET 16
OF 23
E0004

