




NOTES:

1. ALL CSO EQUIPMENT IS EXISTING.
2. REFER TO THE CITY OF WINNIPEG CSO OUTFALL MONITORING DRAWINGS AS FOLLOWS:
1-0117-A-A0202-001-00; 1-0117-A-A0202-002-00;
1-0117-A-A0203-001-00; 1-0117-A-A0204-001-00;
1-0117-A-A0204-002-00; AND CSO PANEL CONNECTION

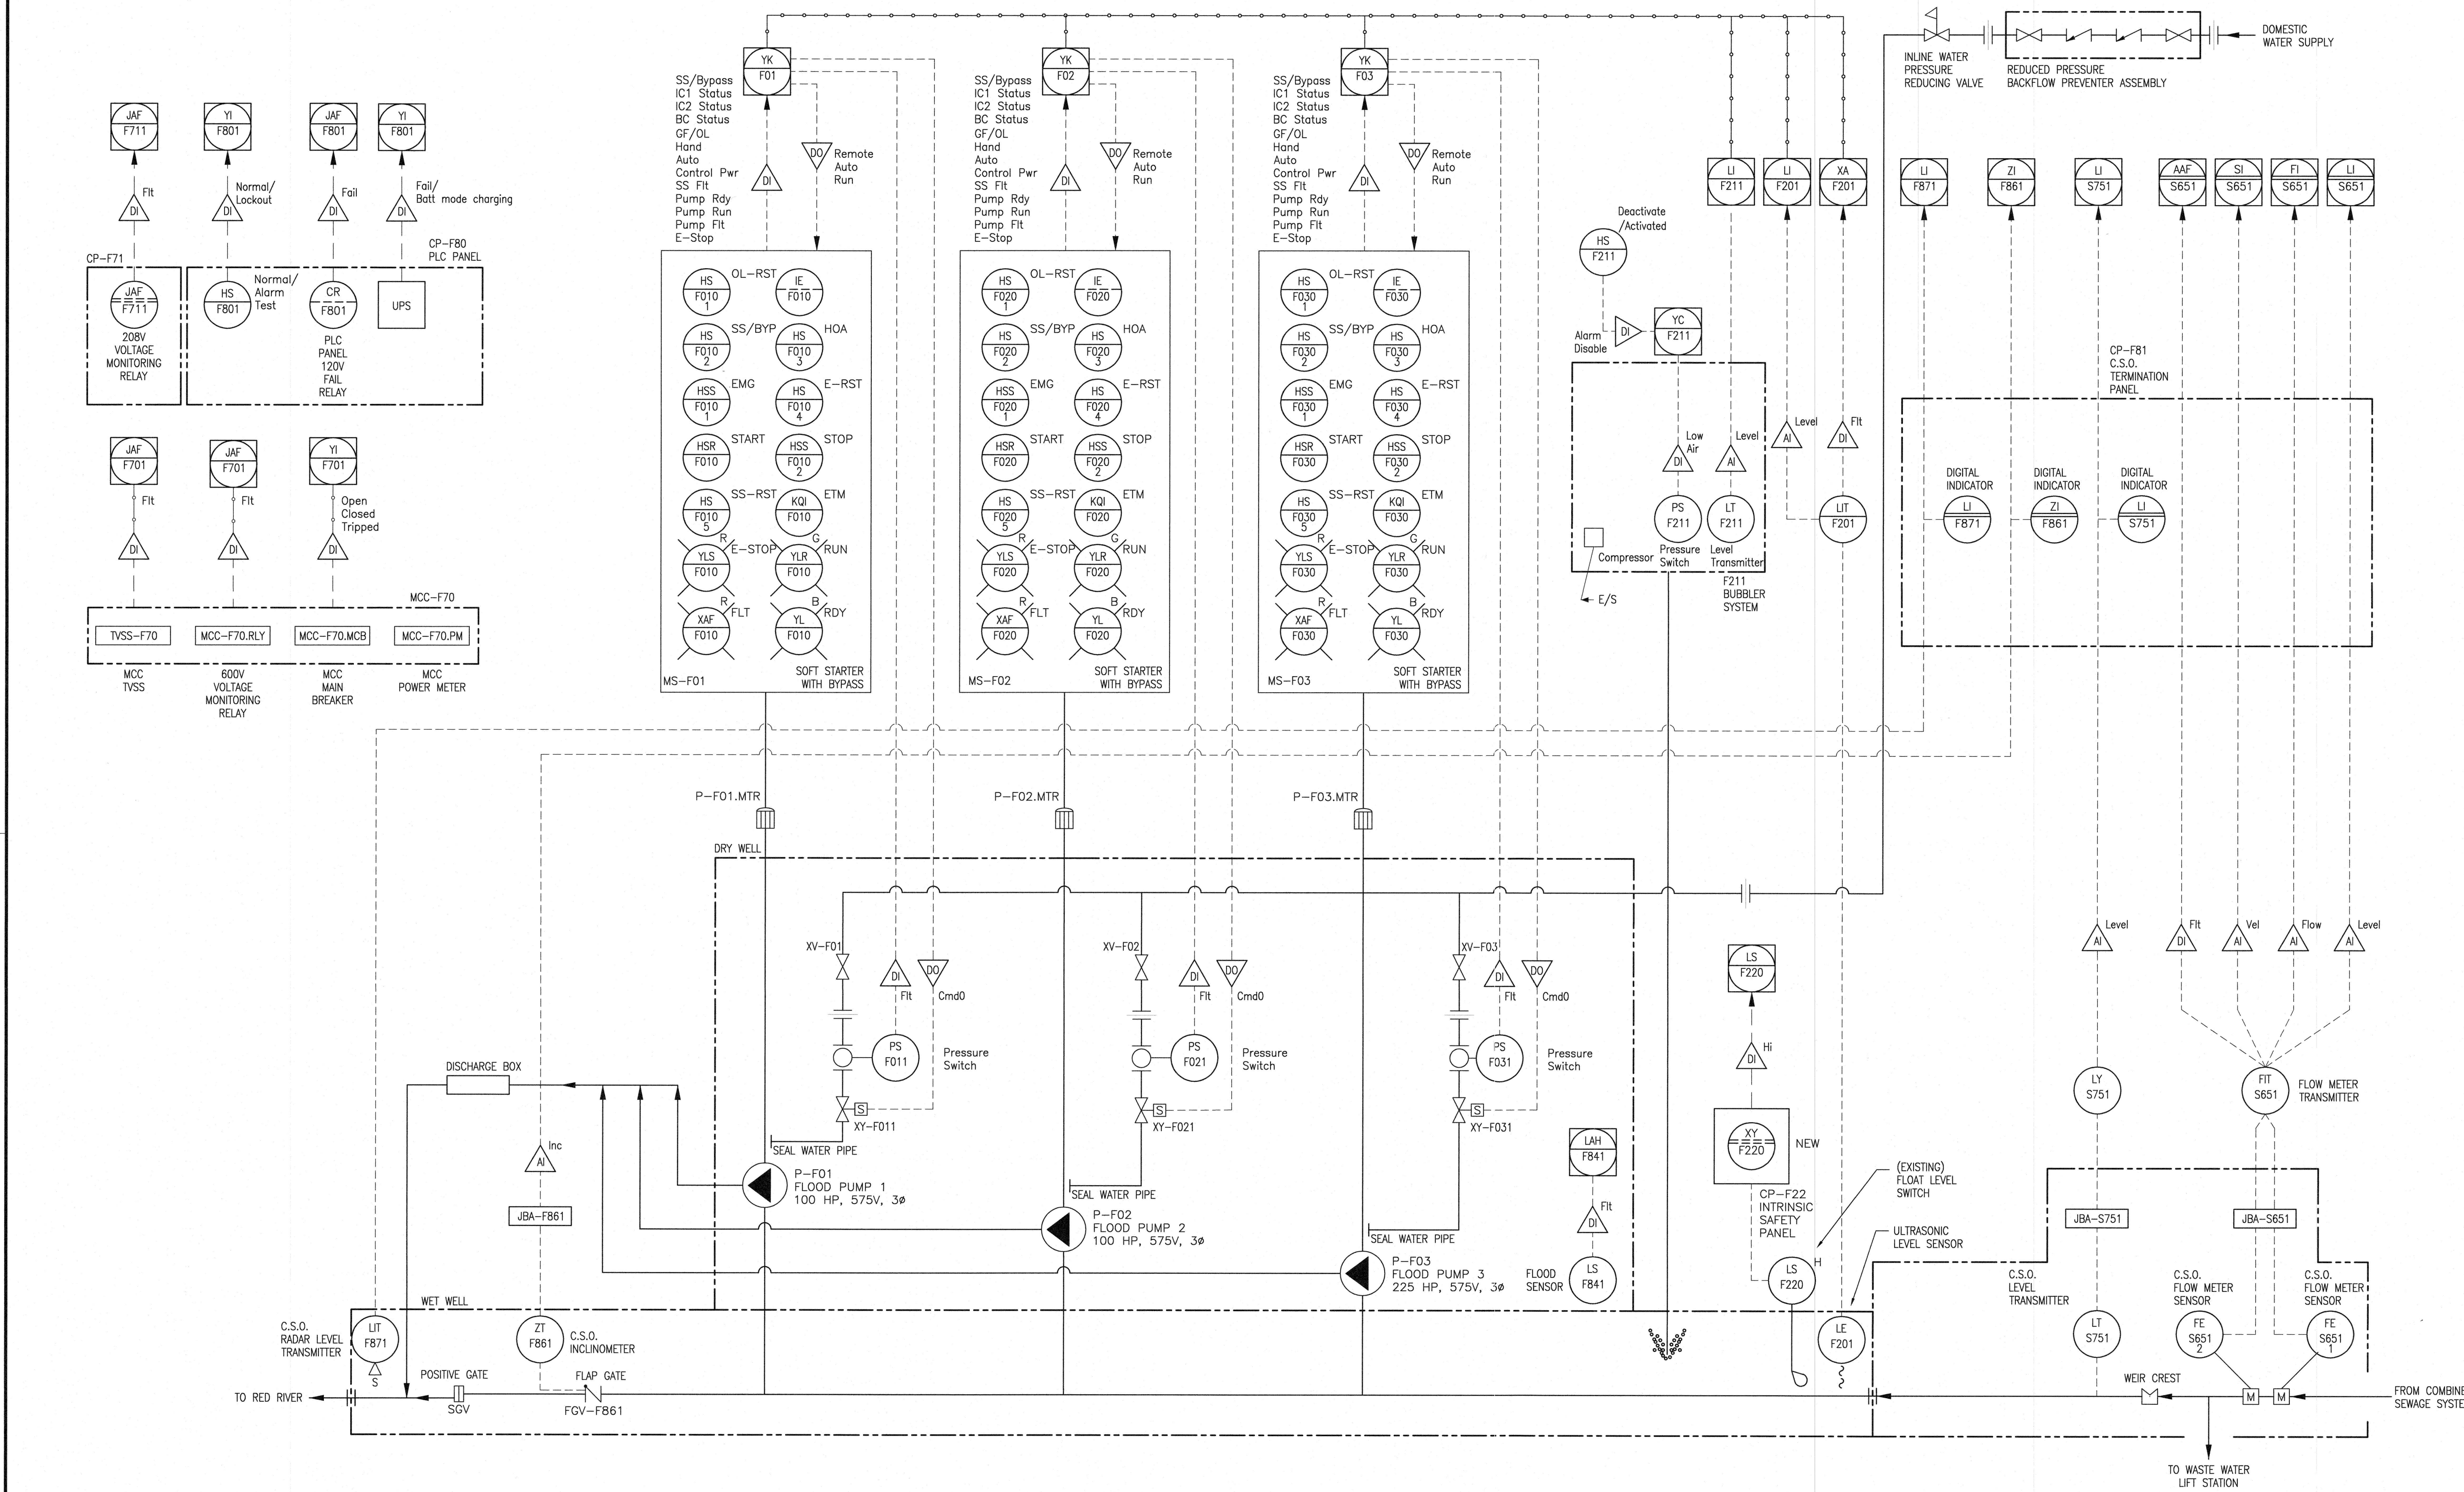

THE INFORMATION CONTAINED ON THIS DRAWING HAS BEEN PREPARED SOLELY FOR THE OWNER FOR USE ON THIS PROJECT AND IS COPYRIGHTED. ANY UNAUTHORIZED USE OF THIS INFORMATION IS A BREACH OF COPYRIGHT AND WILL BE PURSUED AS SUCH. USE OF THE INFORMATION ON THIS DRAWING IN WHOLE OR IN PART OTHER THAN FOR THE INTENDED PURPOSE IS AT THE SOLE RISK OF THE USER.

LOCATION APPROVED
UNDERGROUND STRUCTURES


SUPR. U/G STRUCTURES COMMITTEE DATE

NOTE:
LOCATION OF UNDERGROUND STRUCTURES AS SHOWN ARE BASED ON THE BEST INFORMATION AVAILABLE BUT NO GUARANTEE IS GIVEN THAT ALL EXISTING UTILITIES ARE SHOWN OR THAT THE GIVEN LOCATIONS ARE EXACT. CONFIRMATION OF EXISTENCE AND EXACT LOCATION OF ALL SERVICES MUST BE OBTAINED FROM THE INDIVIDUAL UTILITIES.

B.M. ELEV.			
00	ISSUED FOR TENDER	18.08.02	TI
NO	REVISIONS	DATE	R



DESIGNED BY	TL	CHECKED BY	HGL
DRAWN BY	DW	APPROVED BY	
HOR. SCALE:	N.T.S.	RELEASED FOR CONSTRUCTION	
VERTICAL:			
DATE		DATE	

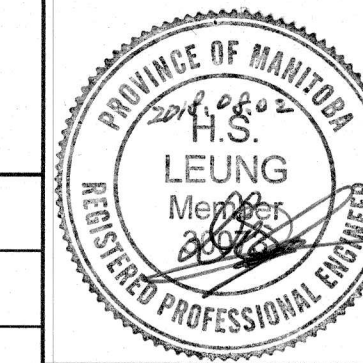

CONSULTANT DRAWING NO
1800120700-DWG-P000



THE CITY OF WINNIPEG
WATER AND WASTE DEPARTMENT

Baltimore Flood Pumping Station Upgrades

PROCESS MECHANICAL
P&ID - PUMPING

CITY DRAWING NUMBER

SHEET 22 OF 23

P0002