


1. FOR GENERAL NOTES, REFER TO DWG. S0001

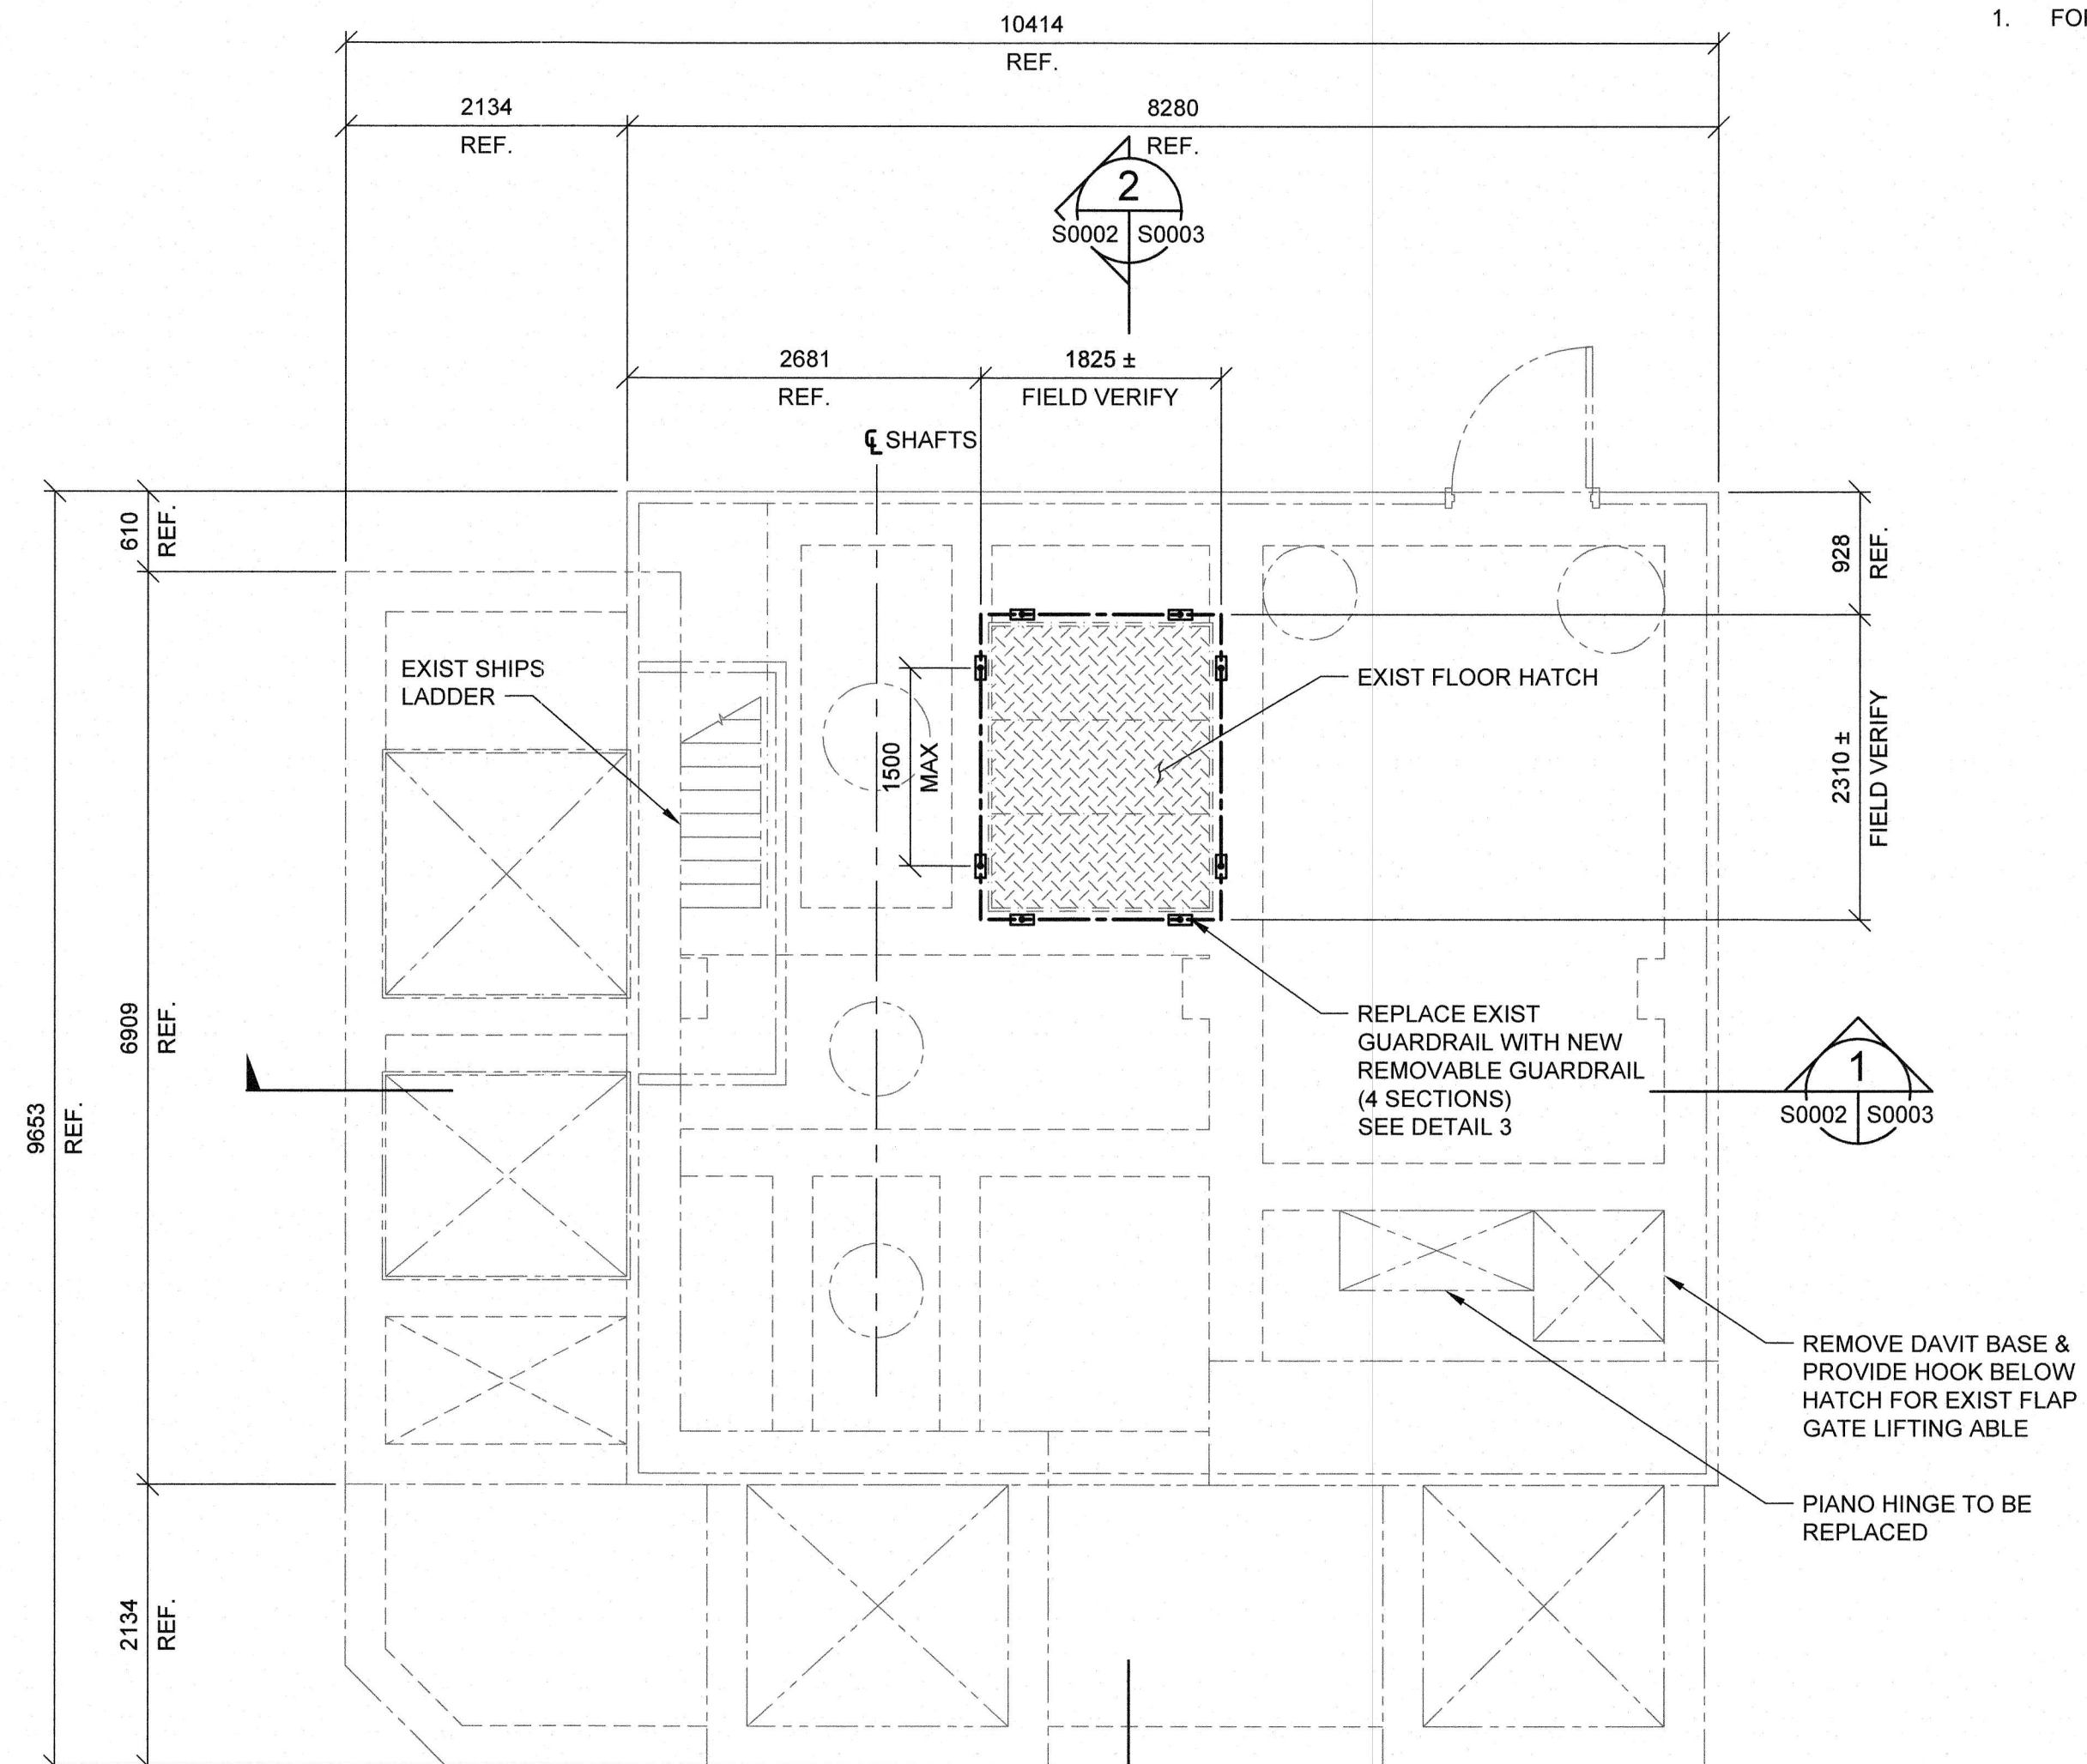


2
- -

MOTOR FLOOR PLAN


1 : 50

T.O. EXIST MOTOR FLOOR @ EL. 231.587

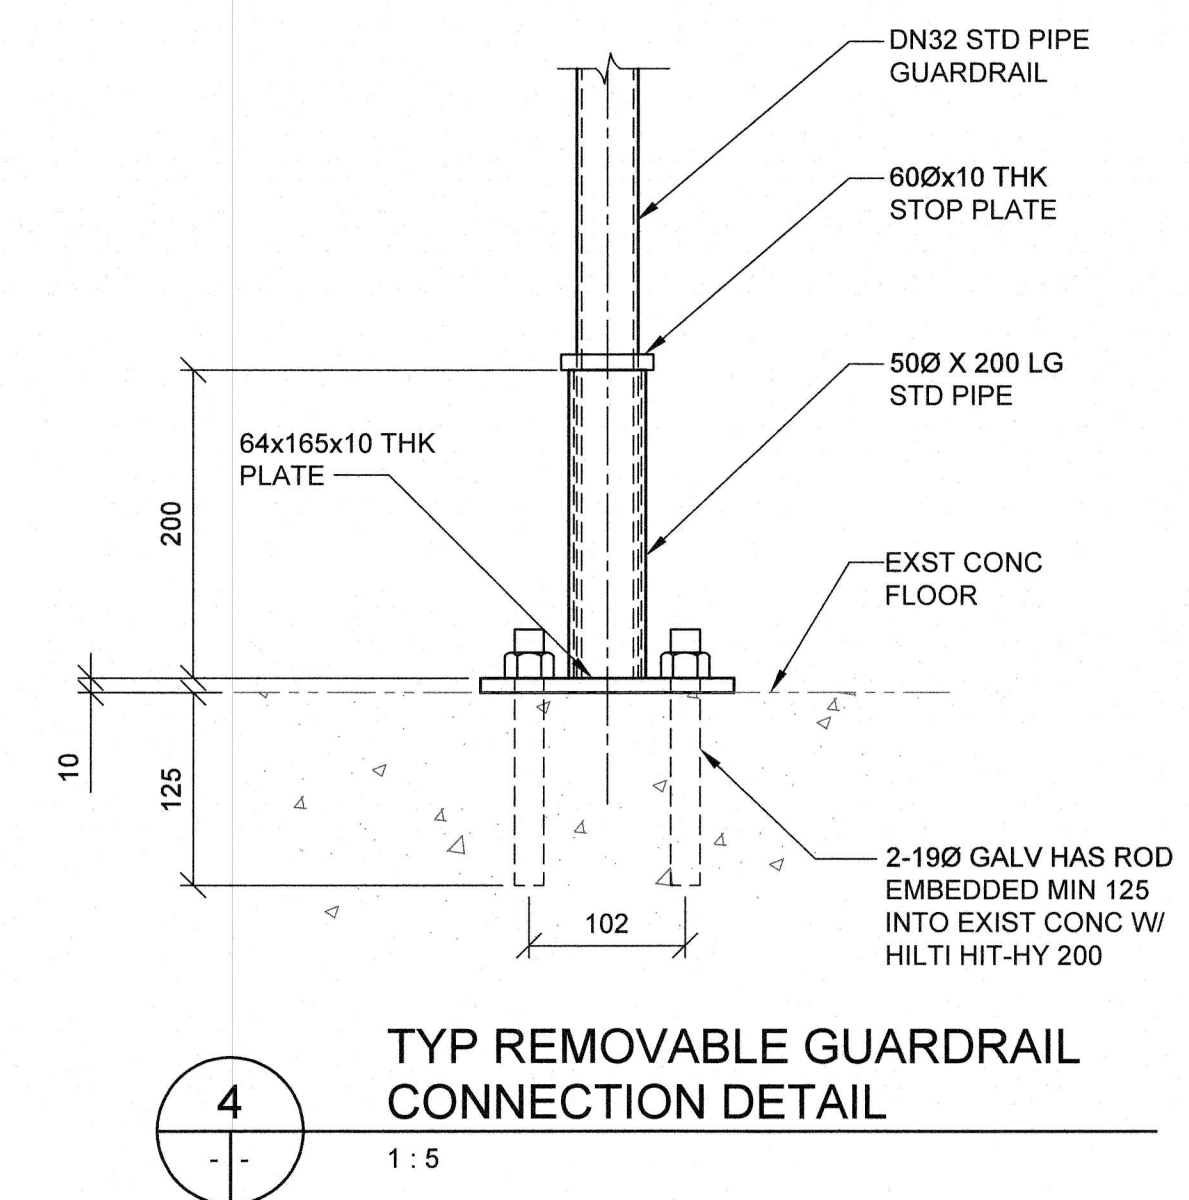

TYP REMOVABLE GUARDRAIL DETAIL

TYP REMOVABLE GUARDRAIL CONNECTION DETAIL

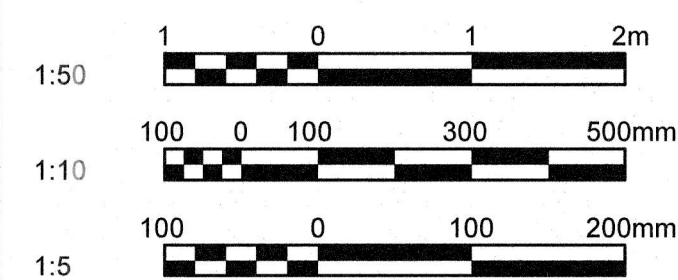

THE INFORMATION CONTAINED ON THIS DRAWING HAS BEEN PREPARED SOLELY FOR THE OWNER FOR USE ON THIS PROJECT AND IS COPYRIGHTED. ANY UNAUTHORIZED USE OF THIS INFORMATION IS A BREACH OF COPYRIGHT AND WILL BE PURSUED AS SUCH. USE OF THE INFORMATION ON THIS DRAWING IN WHOLE OR IN PART OTHER THAN FOR THE INTENDED PURPOSE IS AT THE SOLE RISK OF THE USER.


LOCATION APPROVED
UNDERGROUND STRUCTURES

SUPR. U/G STRUCTURES _____ DATE _____
COMMITTEE

NOTE:
LOCATION OF UNDERGROUND STRUCTURES AS SHOWN ARE BASED ON THE BEST INFORMATION AVAILABLE BUT NO GUARANTEE IS GIVEN THAT ALL EXISTING UTILITIES ARE SHOWN OR THAT THE GIVEN LOCATIONS ARE EXACT. CONFIRMATION OF EXISTENCE AND EXACT LOCATION OF ALL SERVICES MUST BE OBTAINED FROM THE INDIVIDUAL UTILITIES BEFORE PROCEEDING WITH CONSTRUCTION.

[illegible]

DESIGNED BY	MS	CHECKED BY	
DRAWN BY	EV/HA	APPROVED BY	
HOR. SCALE:		RELEASED FOR CONSTRUCTION	
VERTICAL:	AS NOTED		
DATE		DATE	

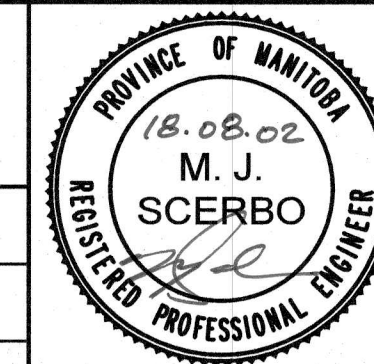

CONSULTANT DRAWING NO.
1800120700-DWG-S0002



THE CITY OF WINNIPEG
WATER AND WASTE DEPARTMENT

BALTIMORE FLOOD PUMPING STATION UPGRADES
STRUCTURAL
DRY/WET WELL PLANS

CITY DRAWING NUMBER

SHEET 5 OF 23

S0002