


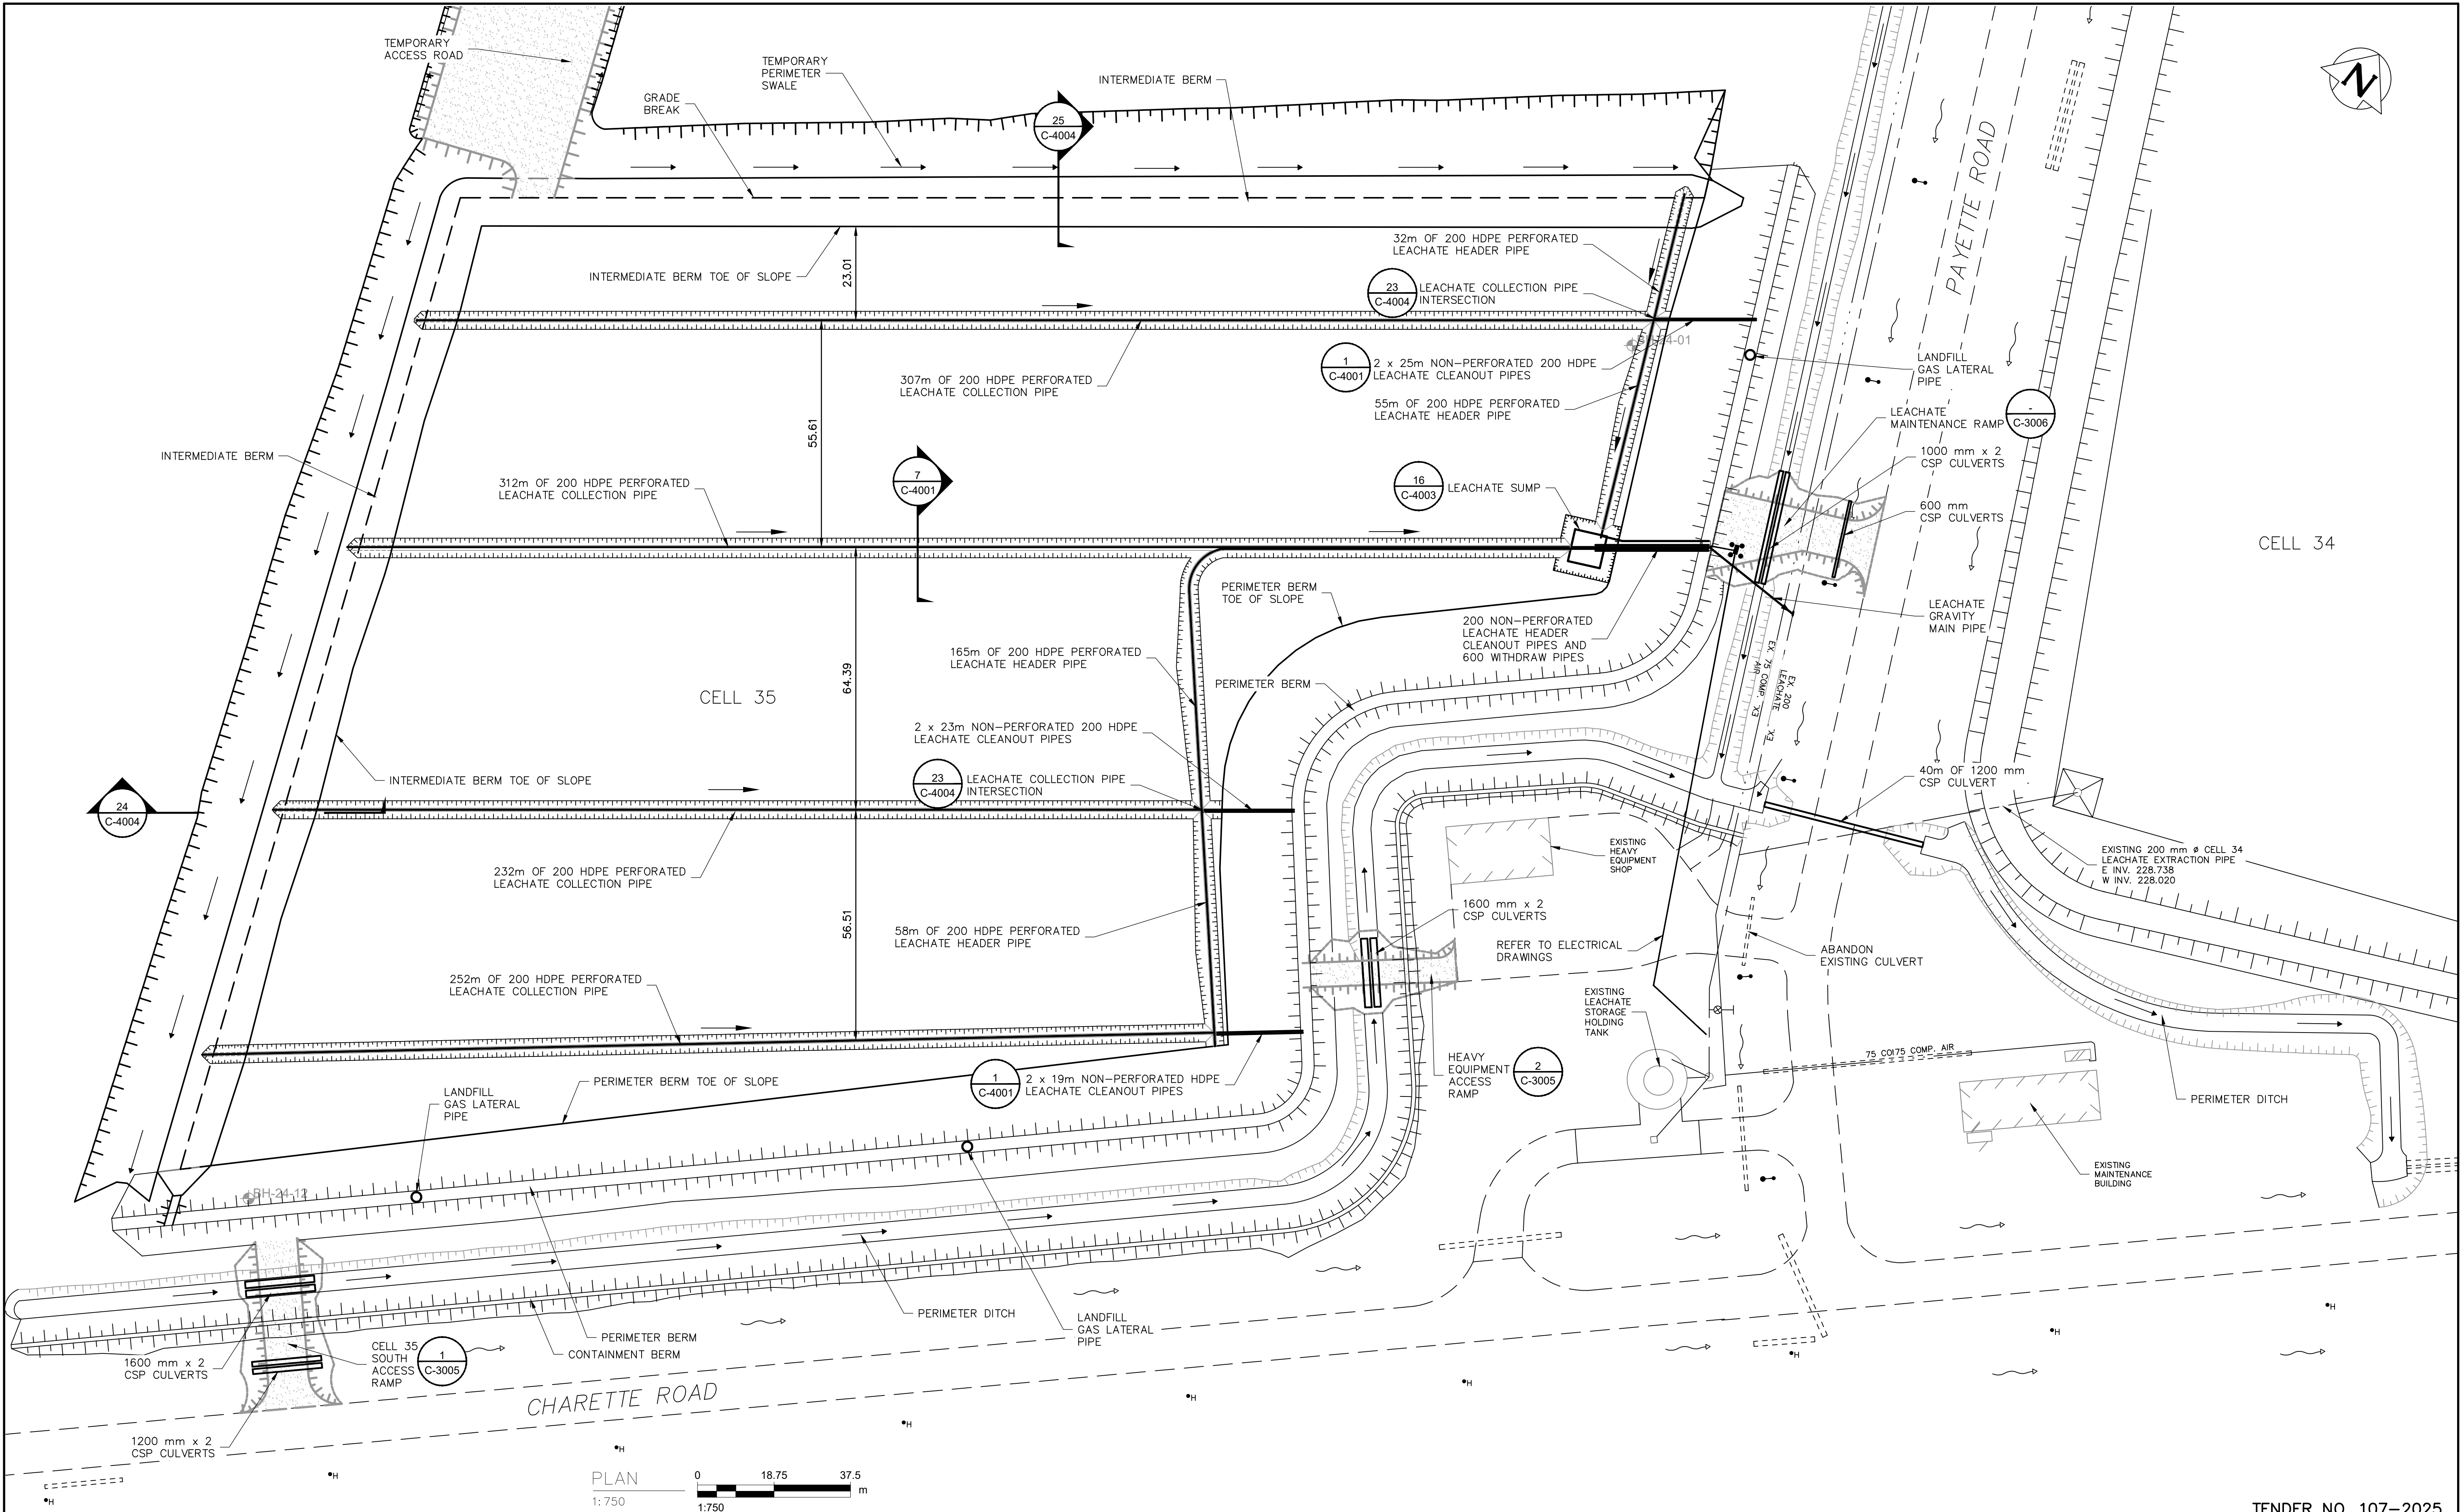

TENDER NO. 107-2025

**ENGINEERS
GEOSCIENTISTS
MANITOBA**
Certificate of Authorization
AECOM Canada ULC
No. 4671

METRIC
WHOLE NUMBERS INDICATE MILLIMETRES
DECIMALIZED NUMBERS INDICATE METRES

WARNING

IF POWER EQUIPMENT OR EXPLOSIVES ARE TO BE USED FOR EXCAVATION ON THIS PROJECT THE CONTRACTOR MUST:

- 1) NOTIFY THE GAS COMPANY OF THE PROPOSED LOCATION OF EXCAVATION.
- 2) TAKE PRECAUTION TO AVOID DAMAGE TO GAS COMPANY INSTALLATIONS.

SEE PROVINCIAL REGULATION 210/72 FOR DETAILS

**LOCATION APPROVED
UNDERGROUND STRUCTURES**

SUPV. U/G STRUCTURES COMMITTEE DATE

NOTE:
LOCATION OF UNDERGROUND STRUCTURES AS SHOWN ARE BASED ON THE BEST INFORMATION AVAILABLE BUT NO GUARANTEE IS GIVEN THAT ALL EXISTING UTILITIES ARE SHOWN OR THAT THE GIVEN LOCATIONS ARE EXACT. CONFIRMATION OF EXISTENCE AND EXACT LOCATION OF ALL SERVICES MUST BE OBTAINED FROM THE INDIVIDUAL UTILITIES BEFORE PROCEEDING WITH CONSTRUCTION.

B.M.
ELEV.

CONSTRUCTION COMPLETION DATE: YYYY MM DD

NO.	ISSUED FOR TENDER	DATE	BY
00	ISSUED FOR TENDER	2025/03/31	BM

AECOM

DESIGNED BY	BM	CHECKED BY	SJ
DRAWN BY	JP	APPROVED BY	KO
SCALE:			
HORIZONTAL	1:750	RELEASED FOR CONSTRUCTION	
VERTICAL	—		
DATE	2025 03 31	DATE	

PLOT DATE: 2025 03 31

ENGINEER'S SEAL

CONSULTANT DRAWING NUMBER
C-1005



THE CITY OF WINNIPEG
WATER AND WASTE DEPARTMENT
SOLID WASTE SERVICES

BRADY ROAD RESOURCE MANAGEMENT FACILITY
CELL 35
PIPING PLAN
LEACHATE PIPE & CULVERT LAYOUT

SHEET **7** OF **27**
CITY DRAWING NUMBER
1-0400L-C0010-001

FILE PATH: C:\Users\moreirabezerra\DC\ACCDocs\AECOM\EN-AMER(CAN)-60733855-COW Brady Dump\Project Files\900 Design Collaboration\910 CAD\20-
FILE NAME: C-1005.dwg