



ELEMENTARY DIAGRAM:

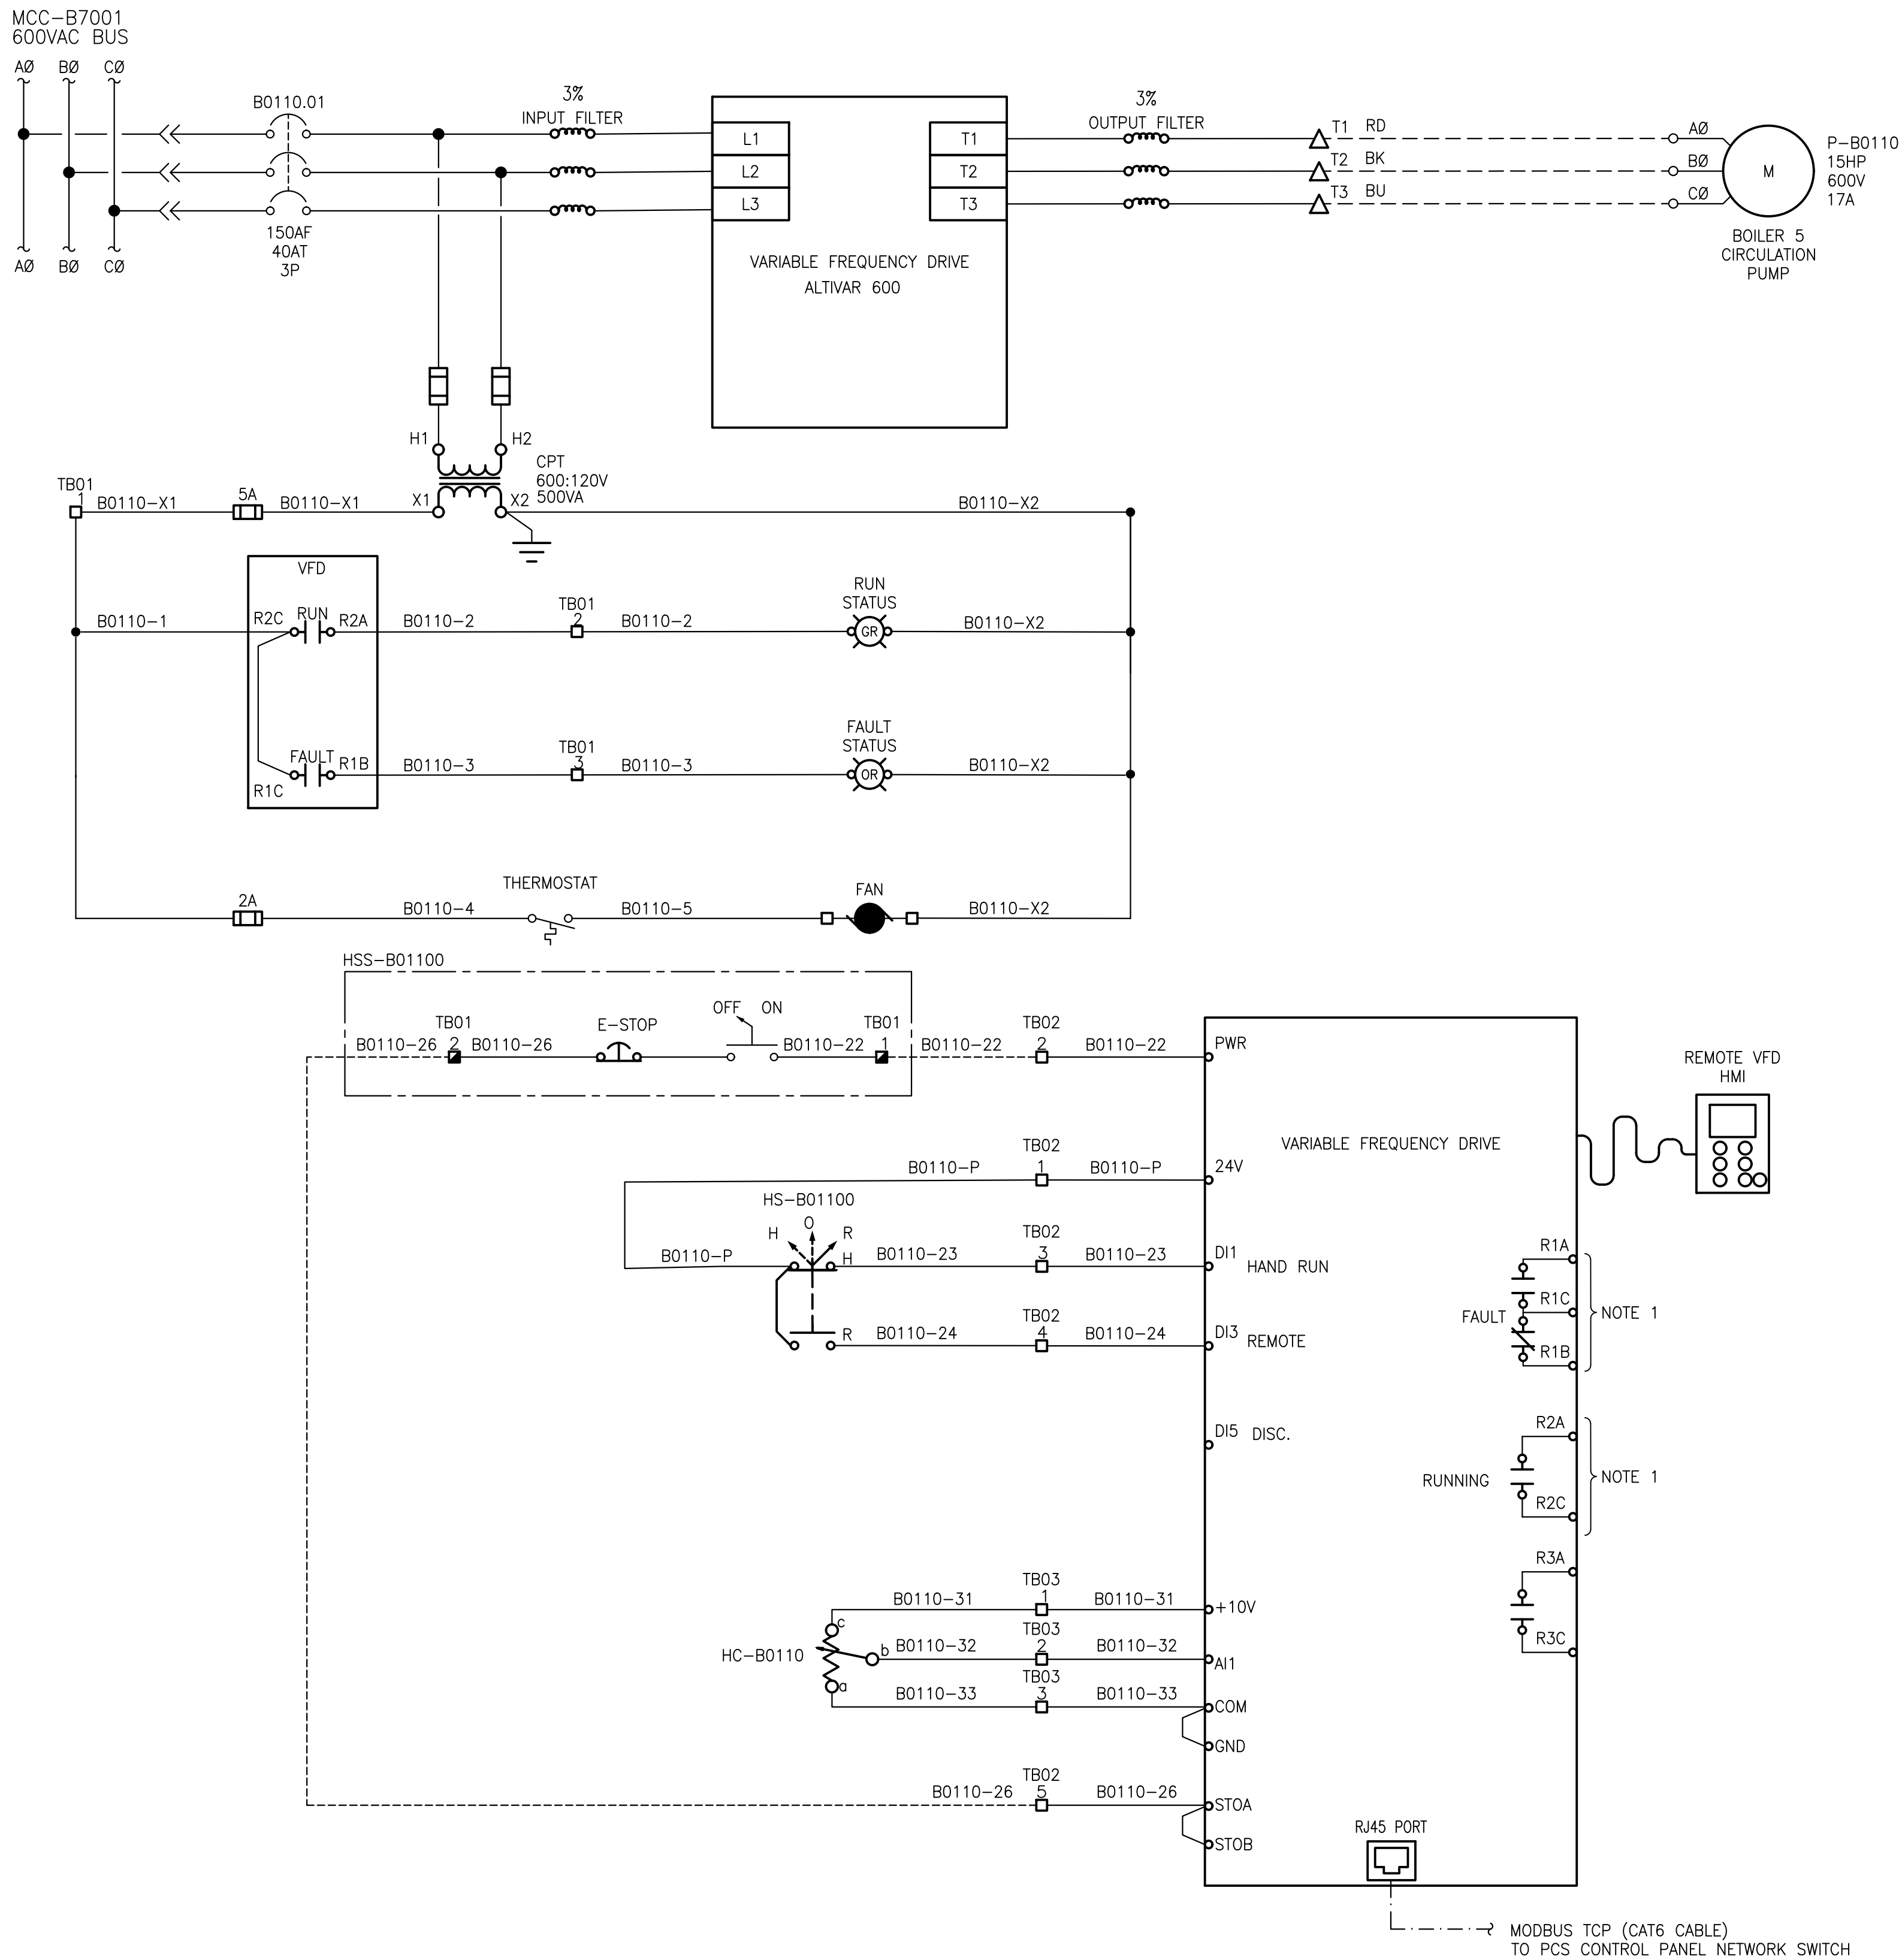

FIELD CONNECTION DIAGRAM:

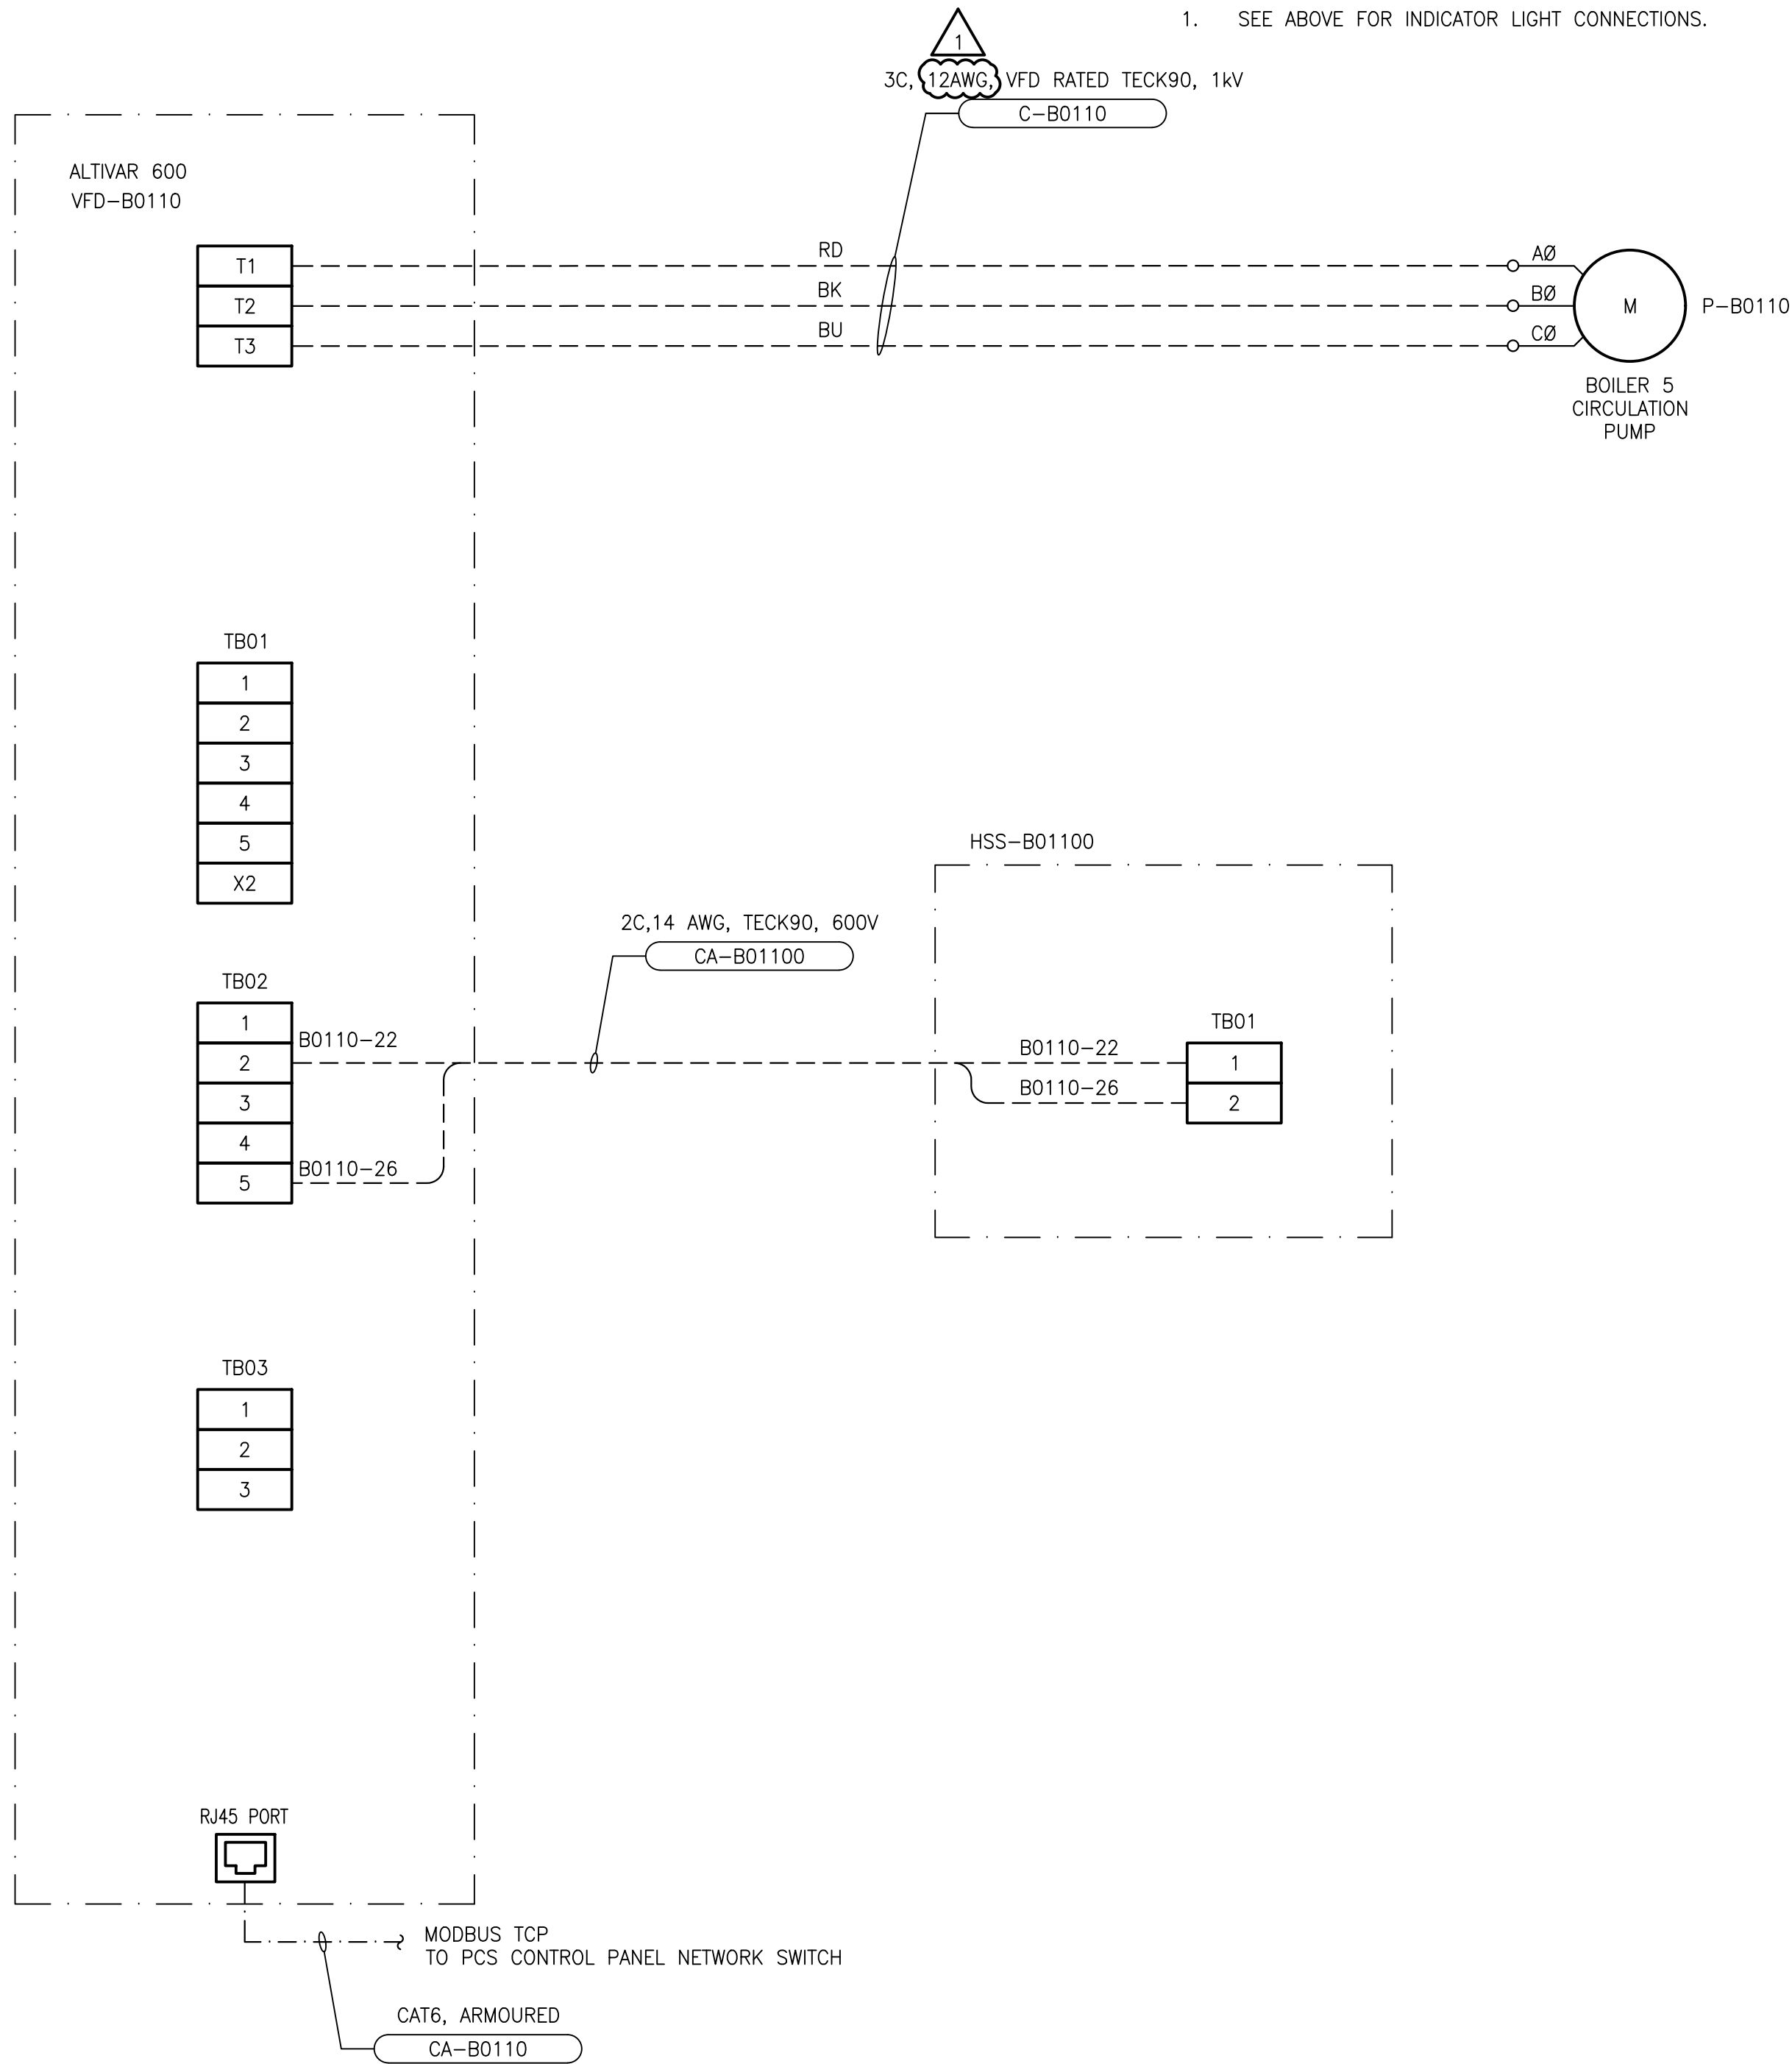

GENERAL NOTES:

1. SEE ABOVE FOR INDICATOR LIGHT CONNECTIONS.

10	—	—
9	—	—
8	—	—
7	—	—
6	—	—
5	—	—
4	—	—
3	—	—
2	1-0101-ANET-B001-001	AUTOMATION — NETWORK BLOCK DIAGRAM
1	1-0101-ESLD-B001-001	ELECTRICAL — MCC-B7001 SINGLE LINE DIAGRAM
NO.	DRAWING NUMBER	REFERENCE DRAWING TITLE
REFERENCE DRAWINGS		



B.M. ELEV.			
CONSTRUCTION COMPLETION DATE: YYYY MM DD			
1	RE-ISSUED FOR CONSTRUCTION	2025 04 11	
0	ISSUED FOR CONSTRUCTION	2025 03 25	CLR
NO.	REVISIONS	DATE	BY

KGS GROUP			
DESIGNED BY	AMS	CHECKED BY	CLR
DRAWN BY	DIS	APPROVED BY	CLR
SCALE:	AS SHOWN		
DATE	2024 08 07	DATE	

ENGINEER'S SEAL	
CONSULTANT DRAWING NUMBER	
23-0107-010_PB_E2-03	

THE CITY OF WINNIPEG WATER AND WASTE DEPARTMENT ENGINEERING DIVISION	
NORTH END SEWAGE TREATMENT PLANT (NEWPCC) NEWPCC BOILER REPLACEMENT 2025-2026 AREA B — BOILER ROOM	
ELECTRICAL MOTOR SCHEMATIC WIRING DIAGRAM — P-B0110 BOILER 5 CIRC PUMP	
CITY DRAWING NUMBER	1-0101-EMCL-B003-001
SHEET	1 OF 1

PLOT DATE: 2025 04 11

BID OPPORTUNITY: 277-2025
CONTRACT NUMBER:

FILE PATH: R:\Projects\2023\23-0107-010\Drawg\Elec\2_PermBoiler\
FILE NAME: 1-0101-EMCL-B003-001.dwg