



ELEMENTARY DIAGRAM:

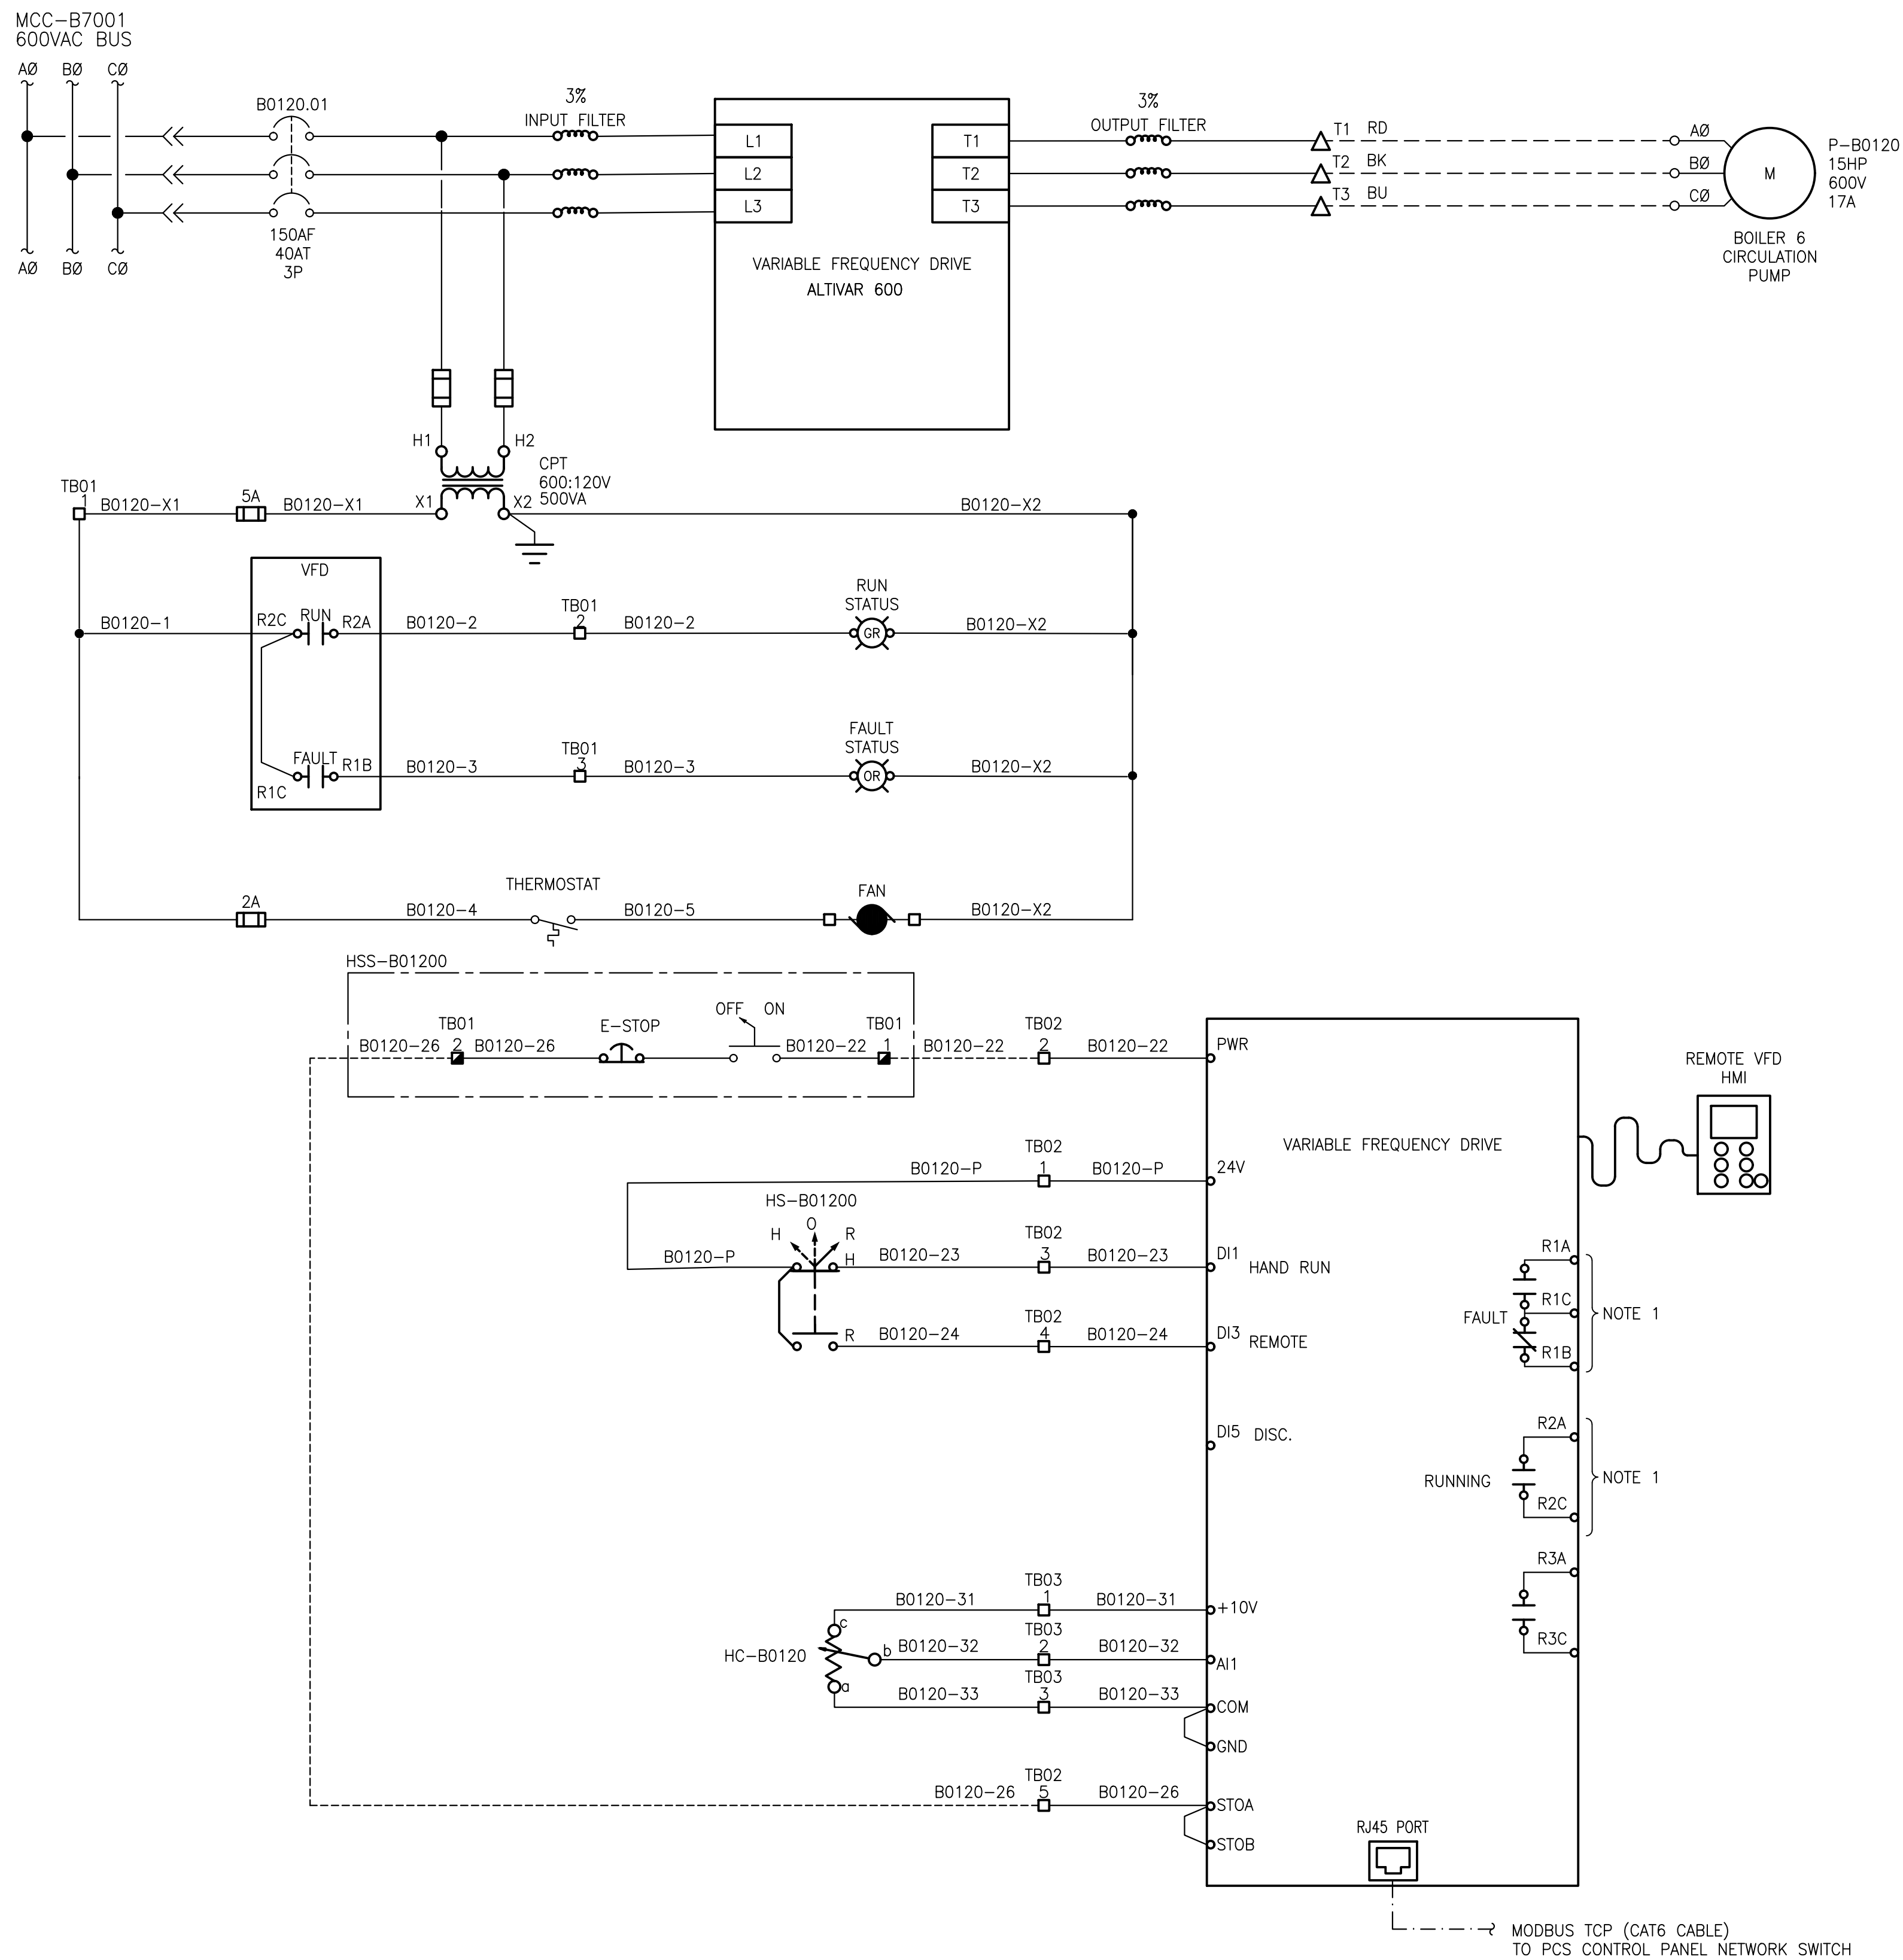

FIELD CONNECTION DIAGRAM:

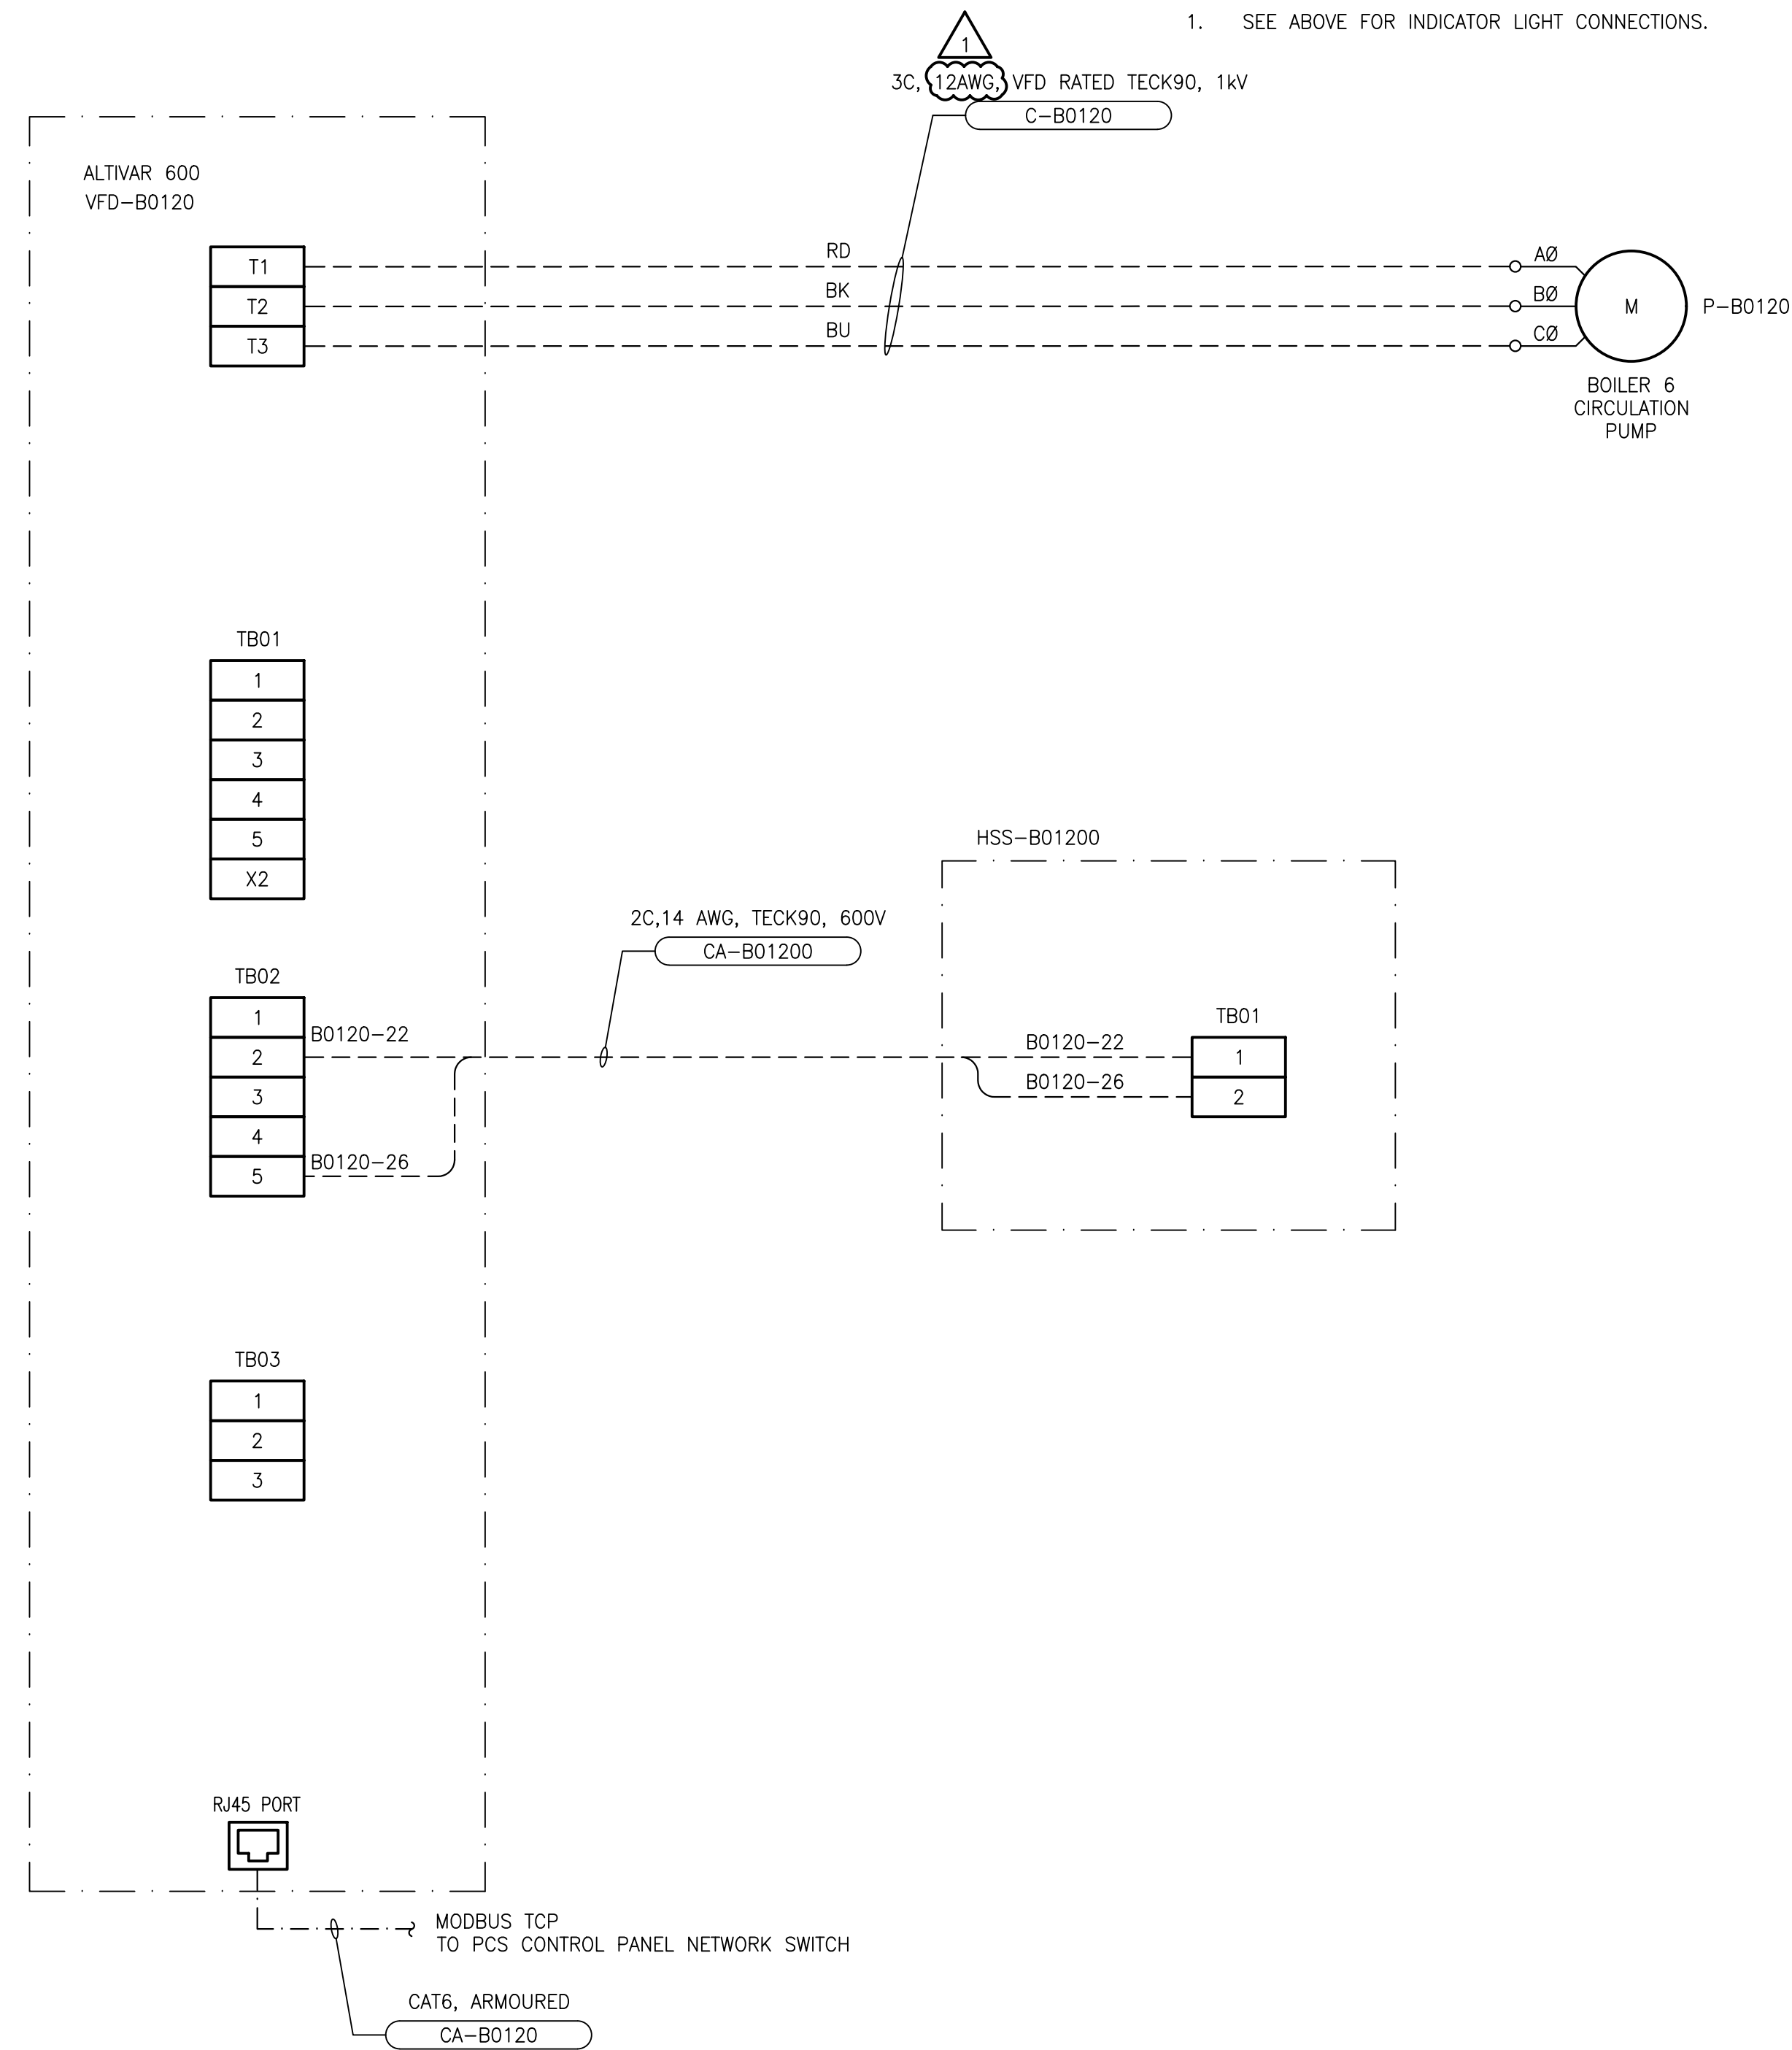

GENERAL NOTES:

- SEE ABOVE FOR INDICATOR LIGHT CONNECTIONS.

10	—	—
9	—	—
8	—	—
7	—	—
6	—	—
5	—	—
4	—	—
3	—	—
2	1-0101-ANET-B001-001	AUTOMATION — NETWORK BLOCK DIAGRAM
1	1-0101-ESLD-B001-001	ELECTRICAL — MCC-B7001 SINGLE LINE DIAGRAM
NO.	DRAWING NUMBER	REFERENCE DRAWING TITLE
REFERENCE DRAWINGS		



B.M.		
ELEV.		
CONSTRUCTION COMPLETION DATE: YYYY MM DD		
1	RE-ISSUED FOR CONSTRUCTION	2025 04 11
0	ISSUED FOR CONSTRUCTION	2025 03 25
NO.	REVISIONS	DATE
		BY

KGS GROUP	
DESIGNED BY	AMS
CHECKED BY	CLR
DRAWN BY	FA
APPROVED BY	CLR
SCALE:	AS SHOWN
DATE	2025 02 20
DATE	2025 04 11
DATE	2025 03 25

ENGINEER'S SEAL
CONSULTANT DRAWING NUMBER
23-0107-010_PB_E2-04

	THE CITY OF WINNIPEG WATER AND WASTE DEPARTMENT ENGINEERING DIVISION
NORTH END SEWAGE TREATMENT PLANT (NEWPCC) NEWPCC BOILER REPLACEMENT 2025-2026 AREA B — BOILER ROOM	
ELECTRICAL MOTOR SCHEMATIC WIRING DIAGRAM — P-B0120 BOILER 6 CIRC PUMP	
CITY DRAWING NUMBER	1-0101-EMCL-B004-001
SHEET	1 OF 1

PLOT DATE: 2025 04 11

BID OPPORTUNITY: 277-2025
CONTRACT NUMBER:FILE PATH: R:\Projects\2023\23-0107-010\Drawings\Elec\2_PermBoiler\
FILE NAME: 1-0101-EMCL-B004-001.dwg