



ELEMENTARY DIAGRAM:

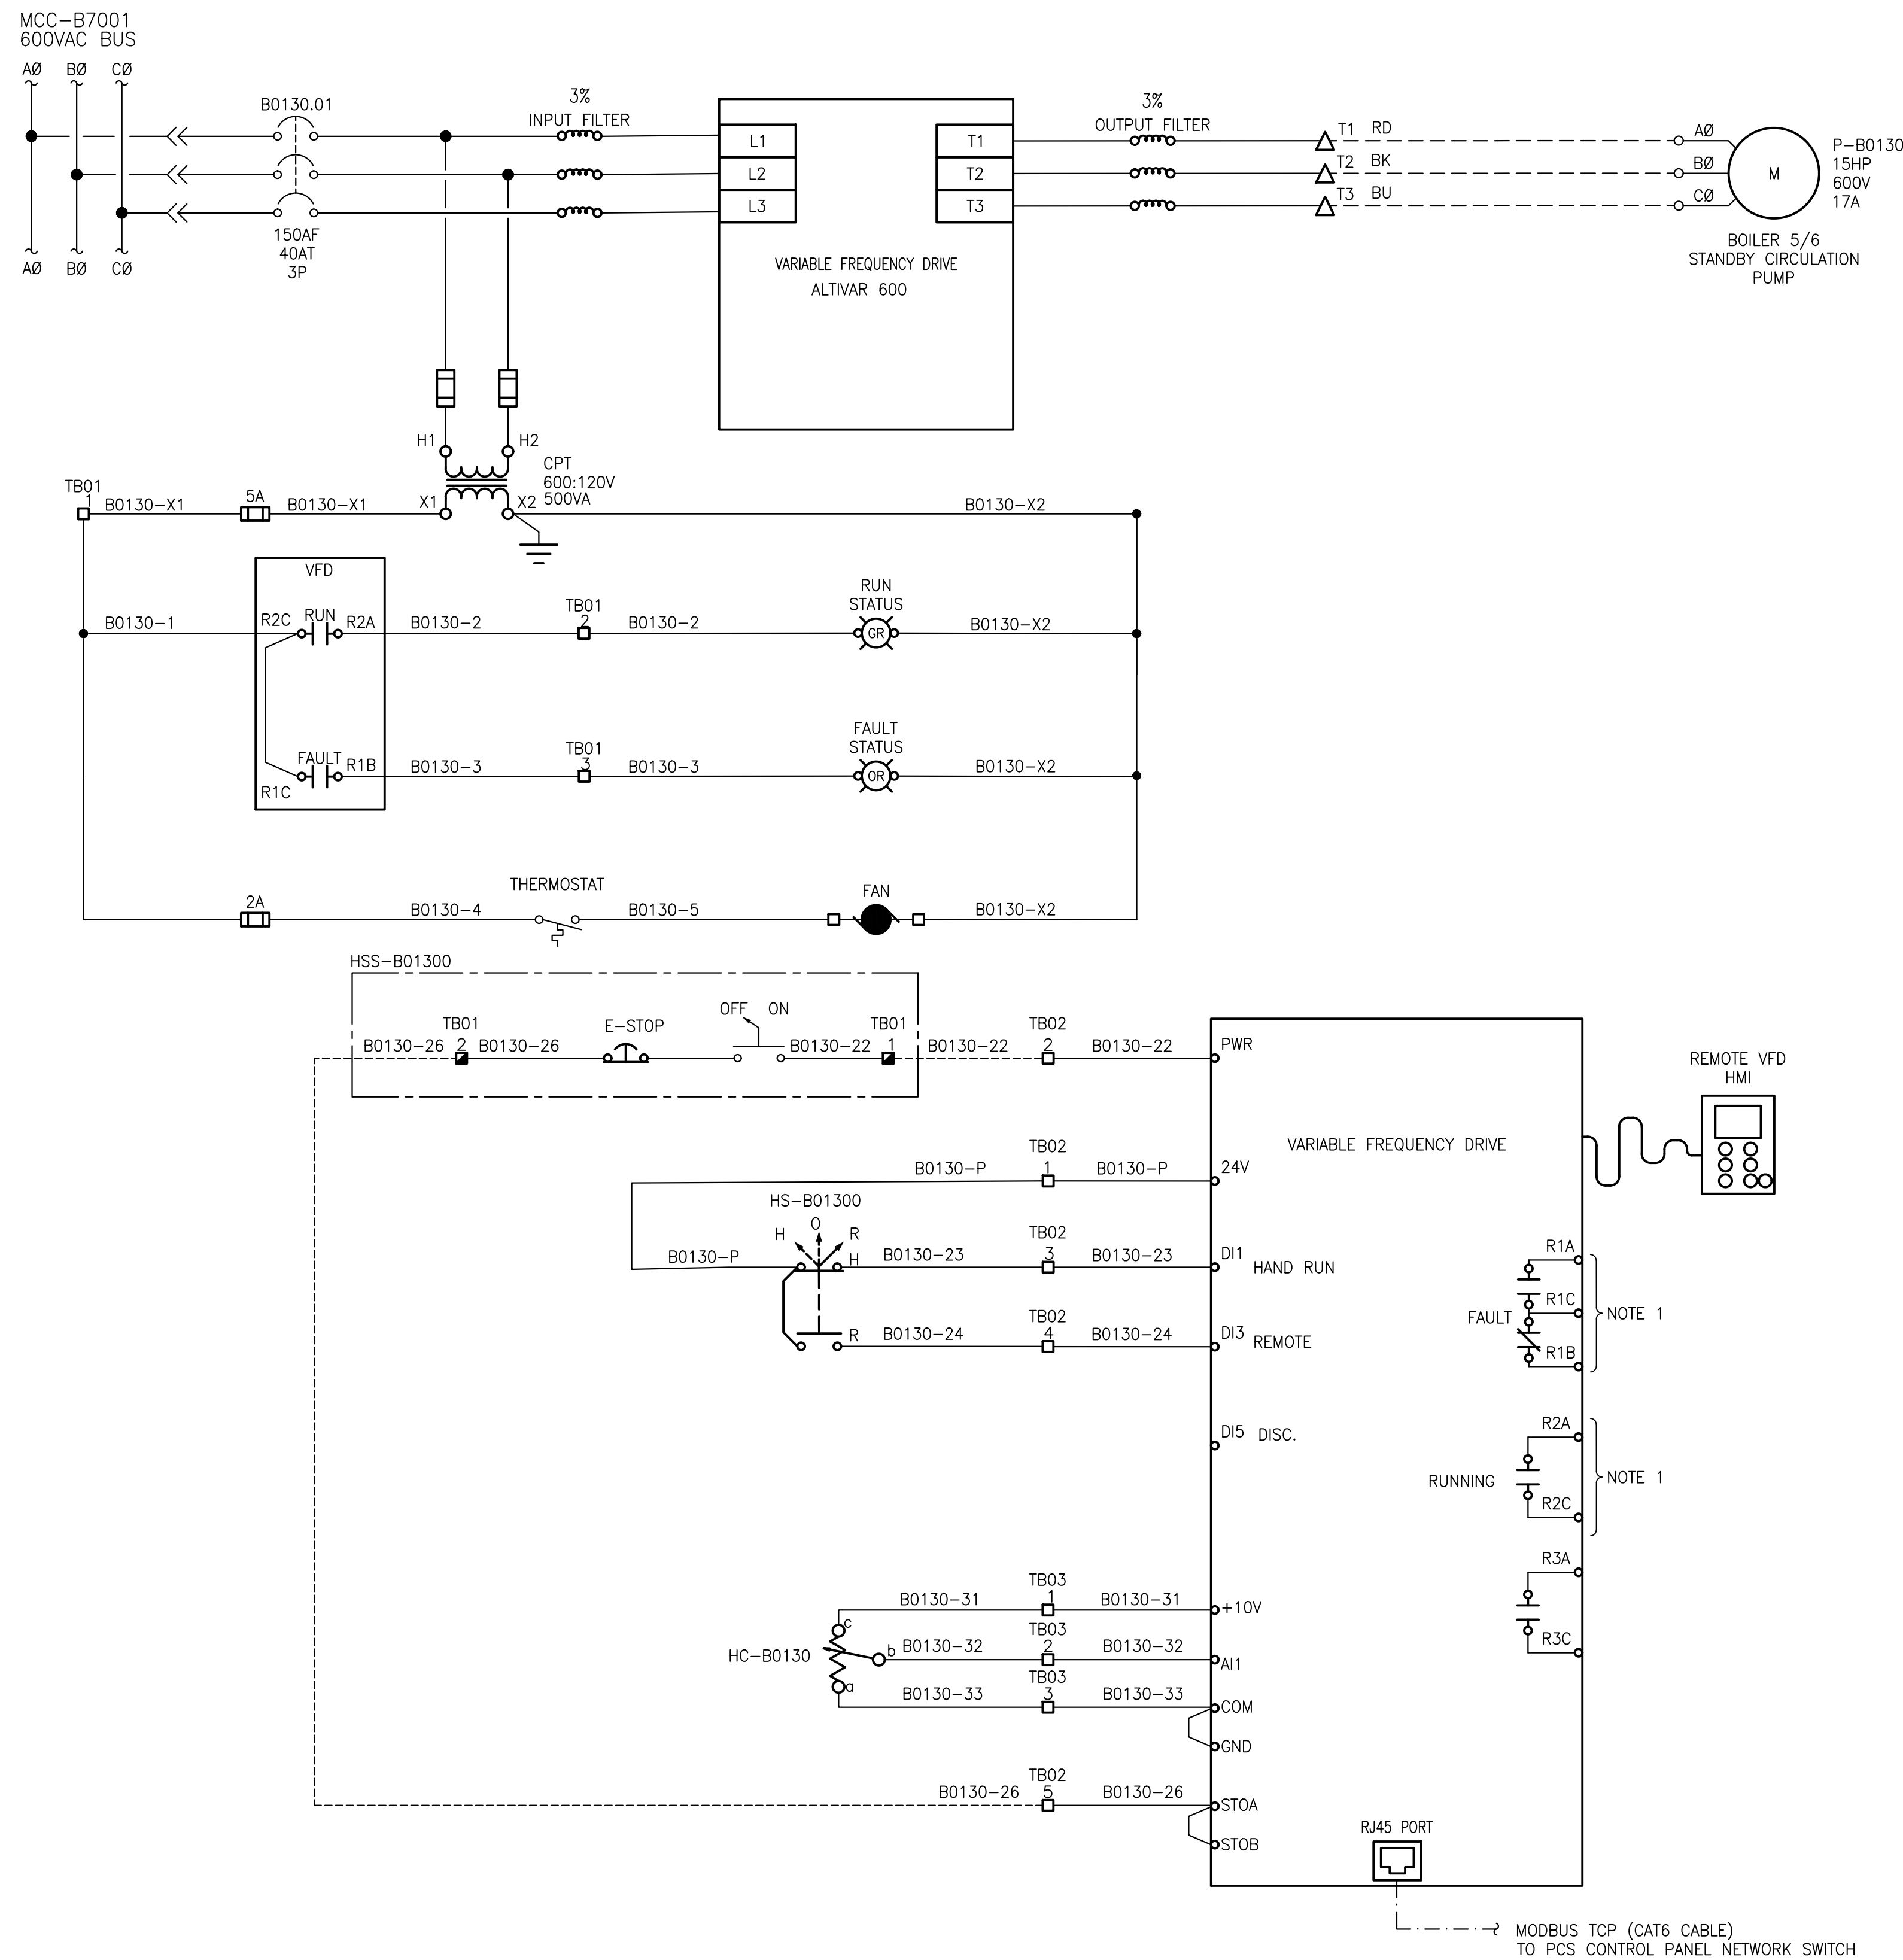

FIELD CONNECTION DIAGRAM:

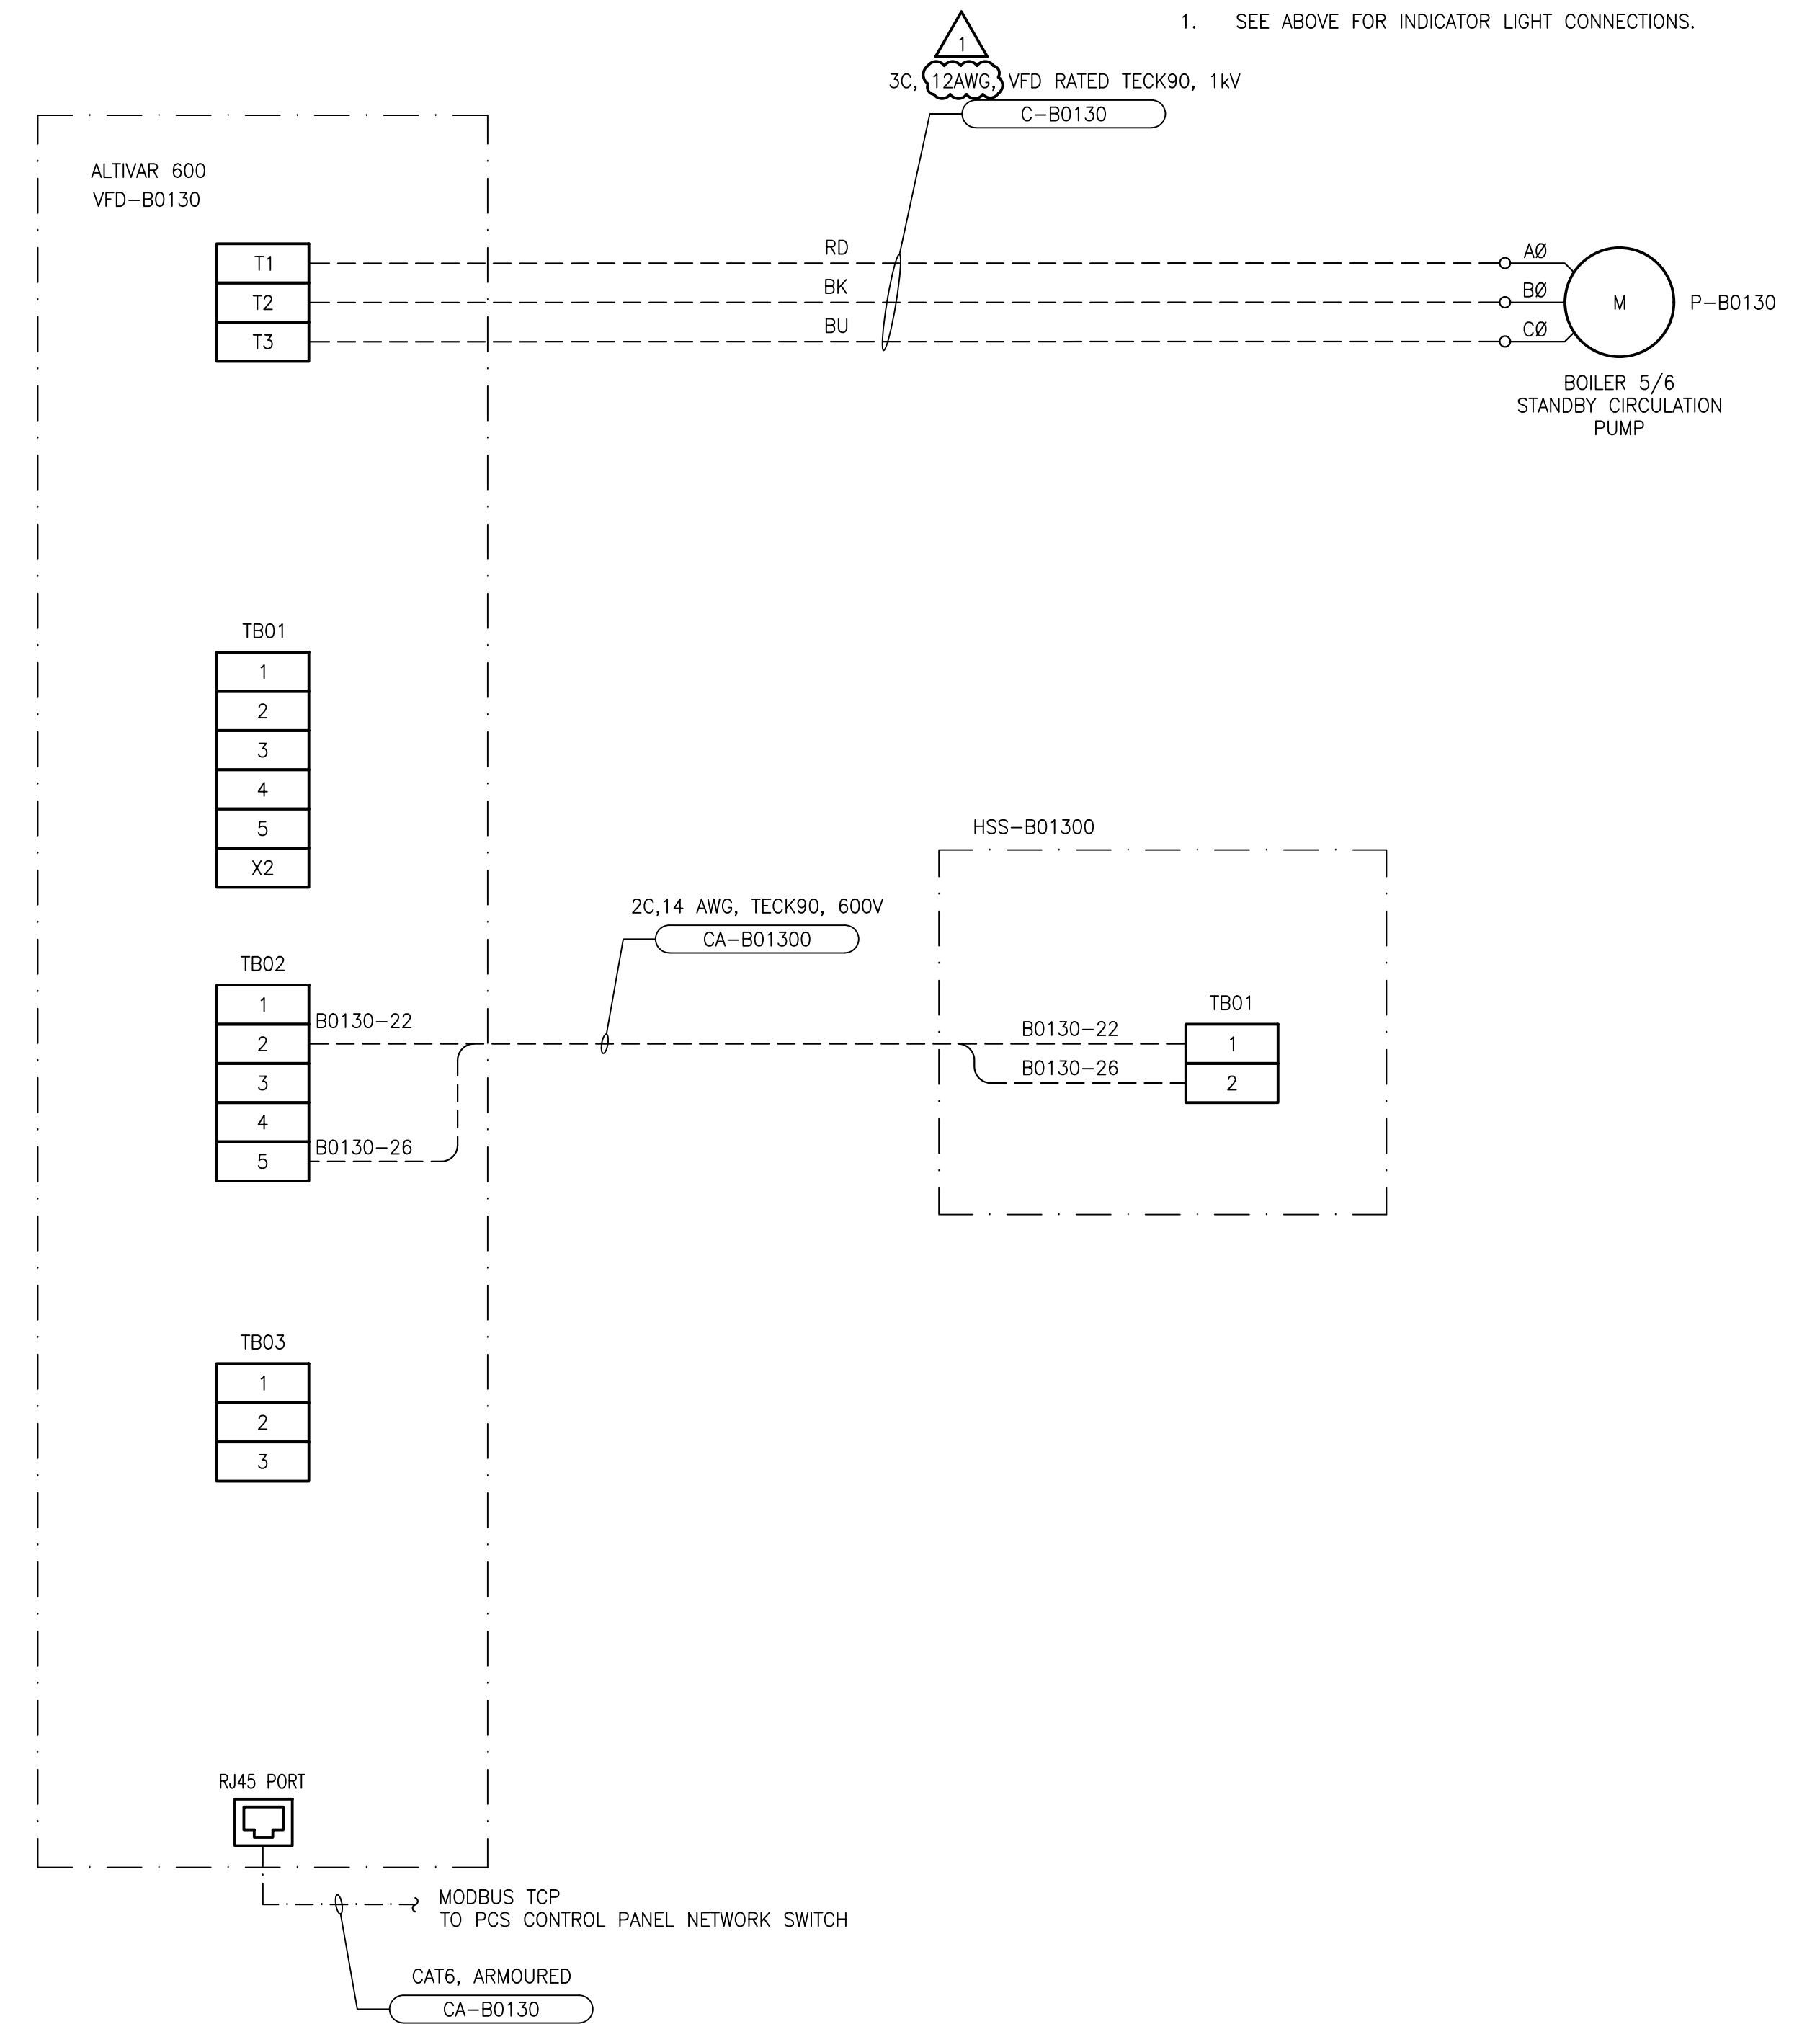

GENERAL NOTES:

1. SEE ABOVE FOR INDICATOR LIGHT CONNECTIONS.

10	—	—
9	—	—
8	—	—
7	—	—
6	—	—
5	—	—
4	—	—
3	—	—
2	1-0101-ANET-B001-001	AUTOMATION — NETWORK BLOCK DIAGRAM
1	1-0101-ESLD-B001-001	ELECTRICAL — MCC-B7001 SINGLE LINE DIAGRAM
NO.	DRAWING NUMBER	REFERENCE DRAWING TITLE
REFERENCE DRAWINGS		


[illegible]

KGS GROUP							
DESIGNED BY		AMS		CHECKED BY		CLR	
DRAWN BY		FA		APPROVED BY		CLR	
SCALE: AS SHOWN				RELEASED FOR CONSTRUCTION			
DATE: 2025 02 20				DATE:			

ENGINEER'S SEAL

CONSULTANT DRAWING NUMBER

23-0107-010_PB_E2-05

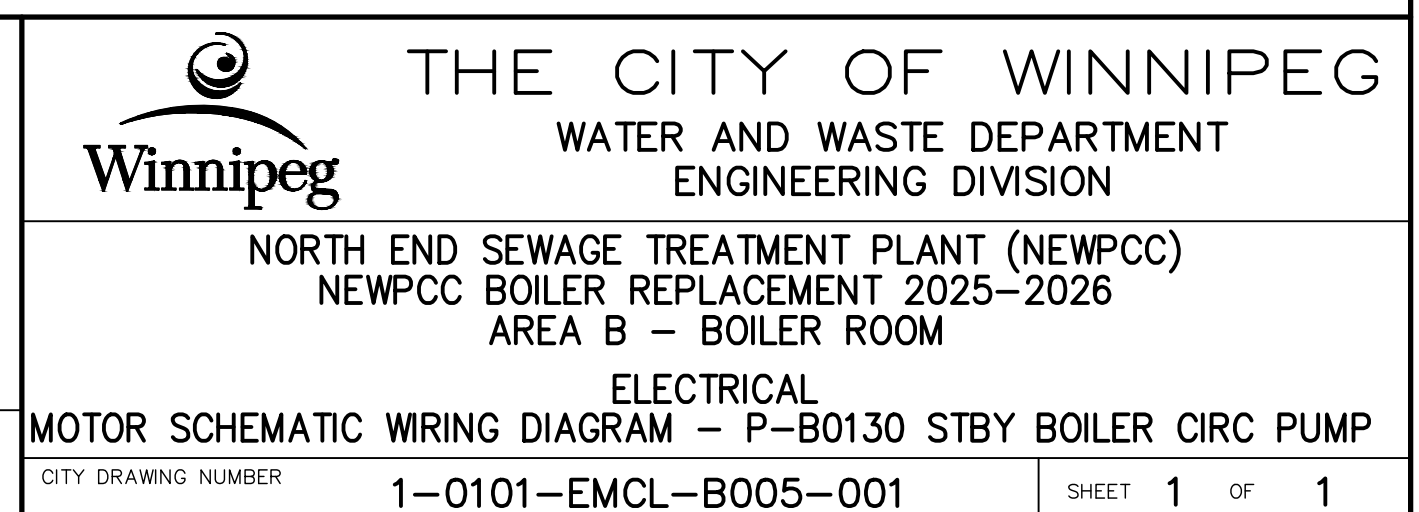

PLOT DATE: 2025 04 11

BID OPPORTUNITY: 277-2025
CONTRACT NUMBER:

FILE PATH: R:\Projects\2023\23-0107-010\Dwg\Elec\2_PermBoiler\
FILE NAME: 1-0101-EMCL-B005-001.dwg

SHEET 1 OF 1