




LAST SAVE: 2025-04-24 1:38:41 PM
PATH: Autocad Doss\\City of Winnipeg - NEWPCC Upgrades 2023\\BMOD-U101.rvt
A1 SIZE - 594mm x 841mm

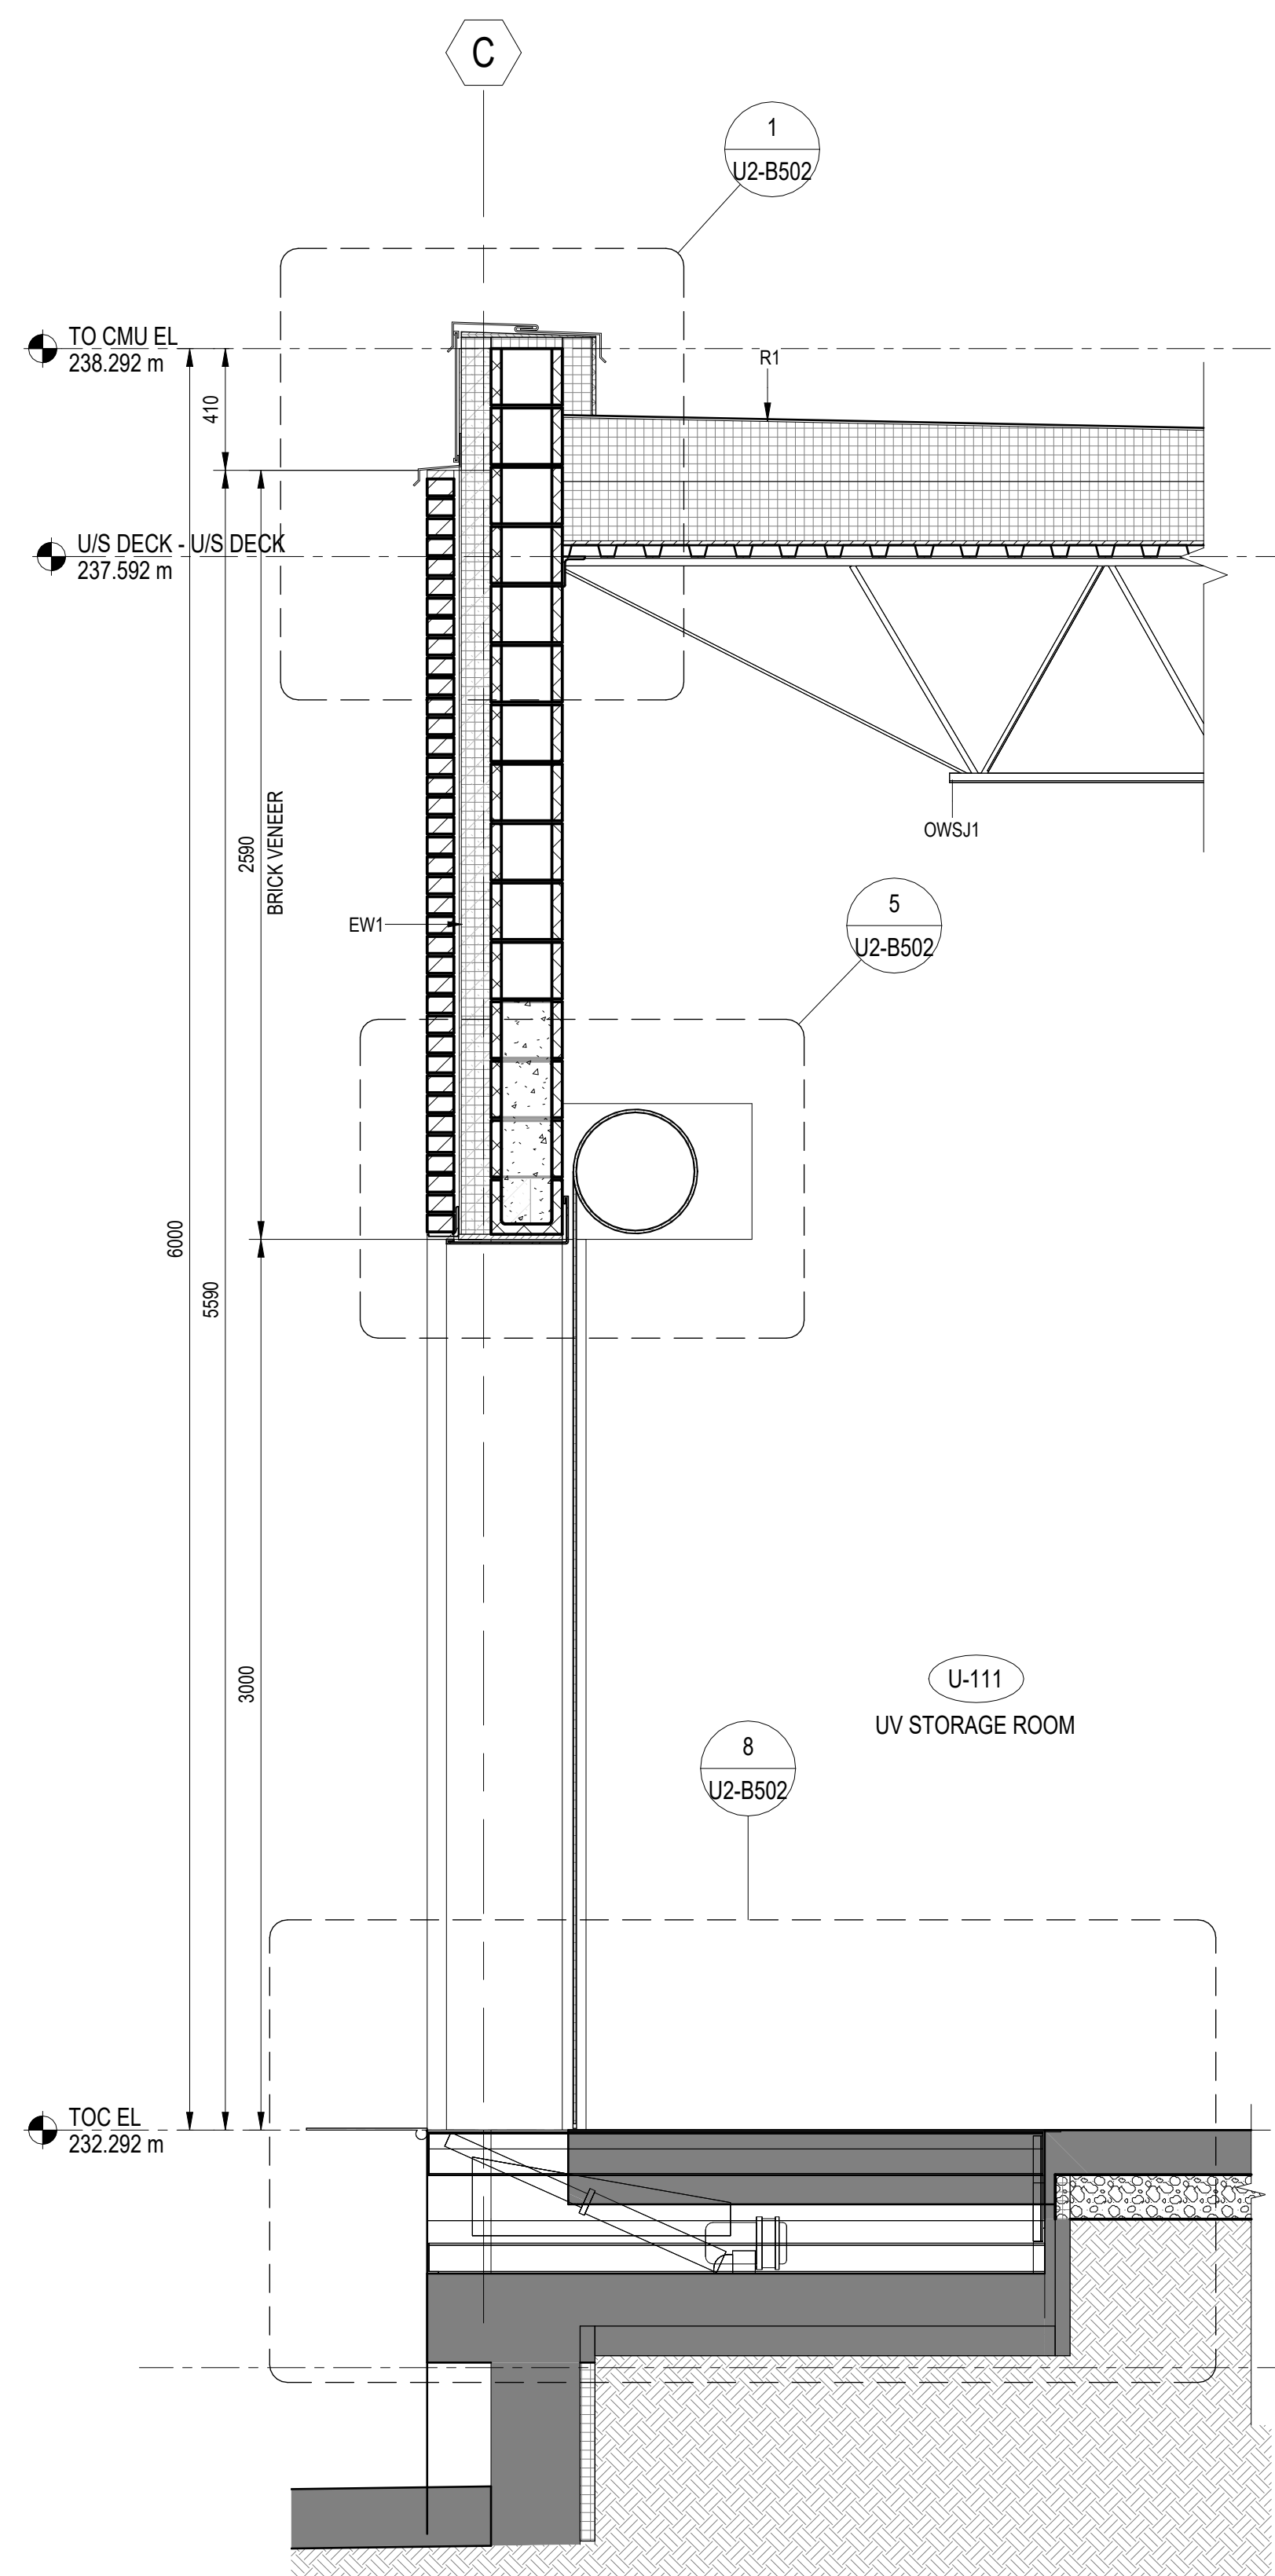


1 WALL SECTION - 1
U2-B201 SCALE: 1 : 20

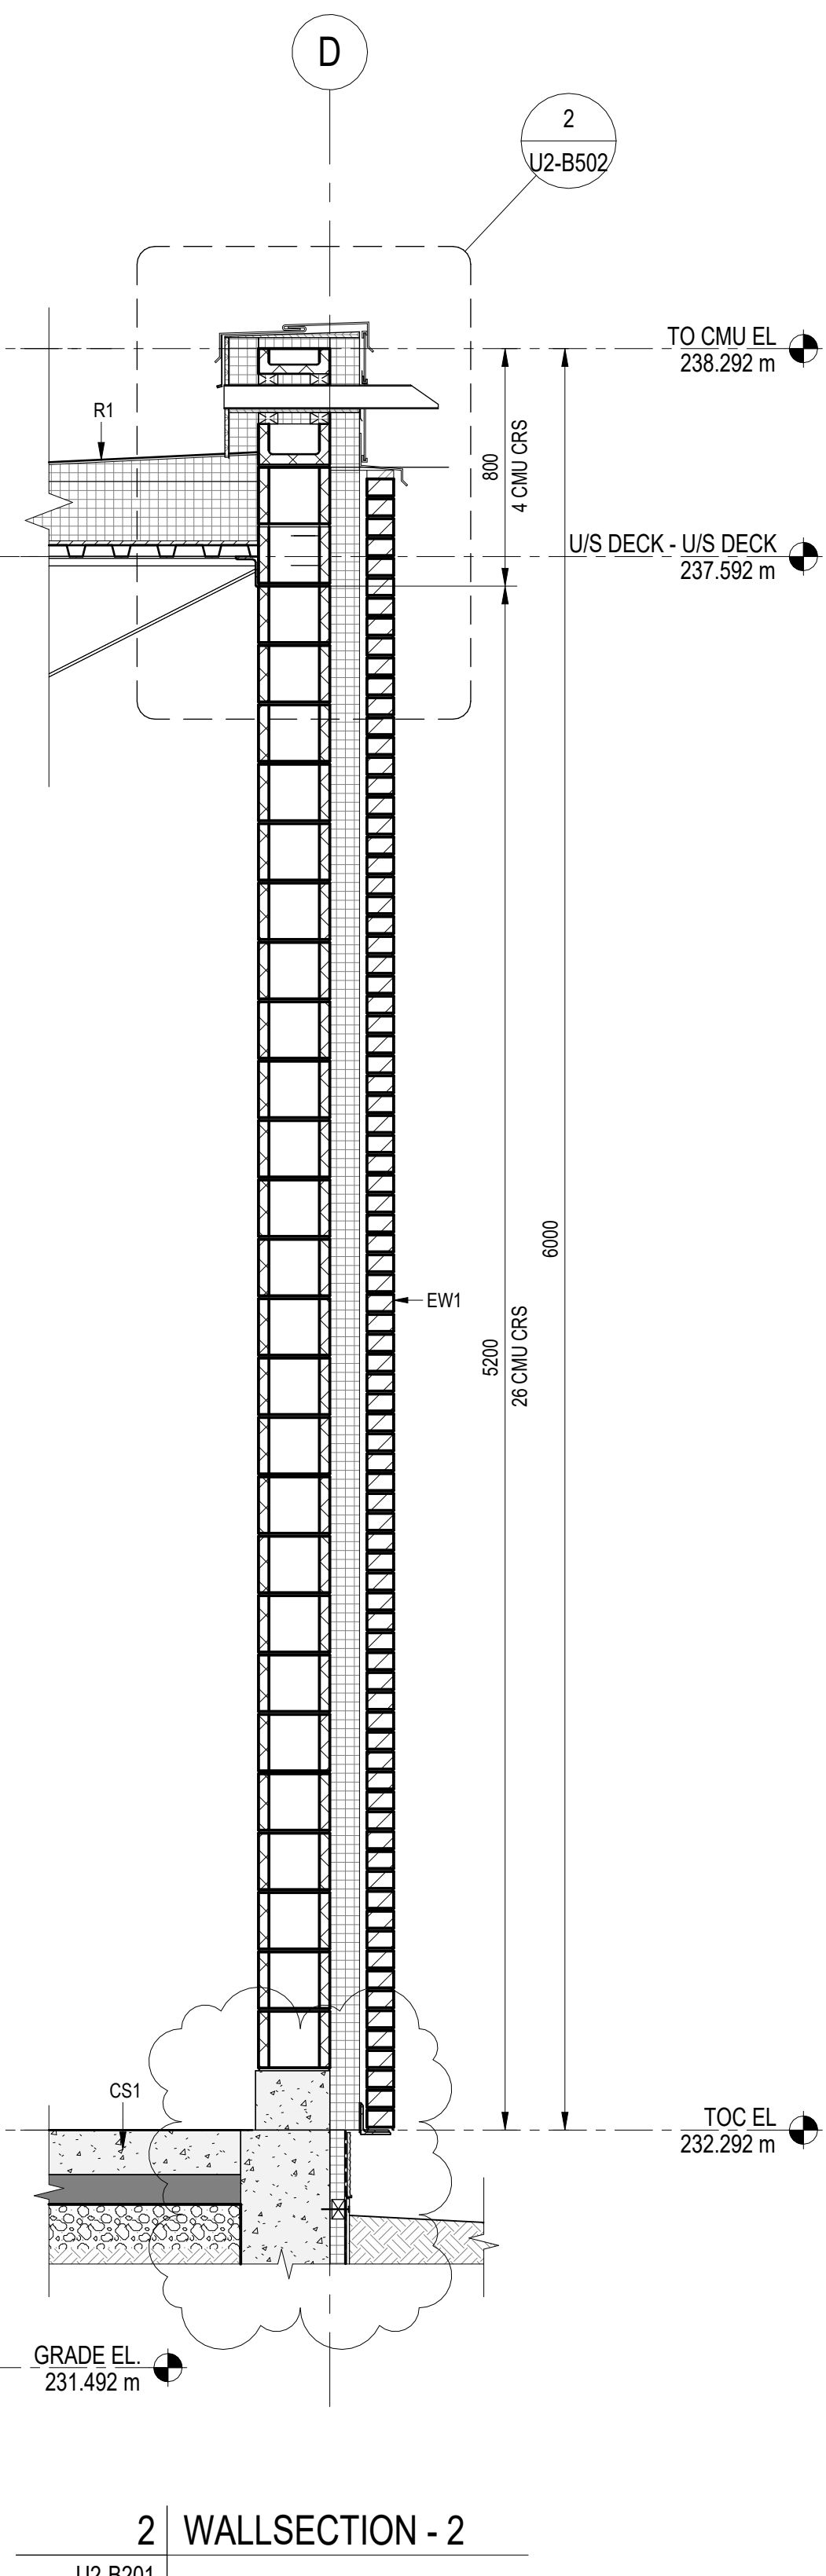


2 WALLSECTION - 2
U2-B201

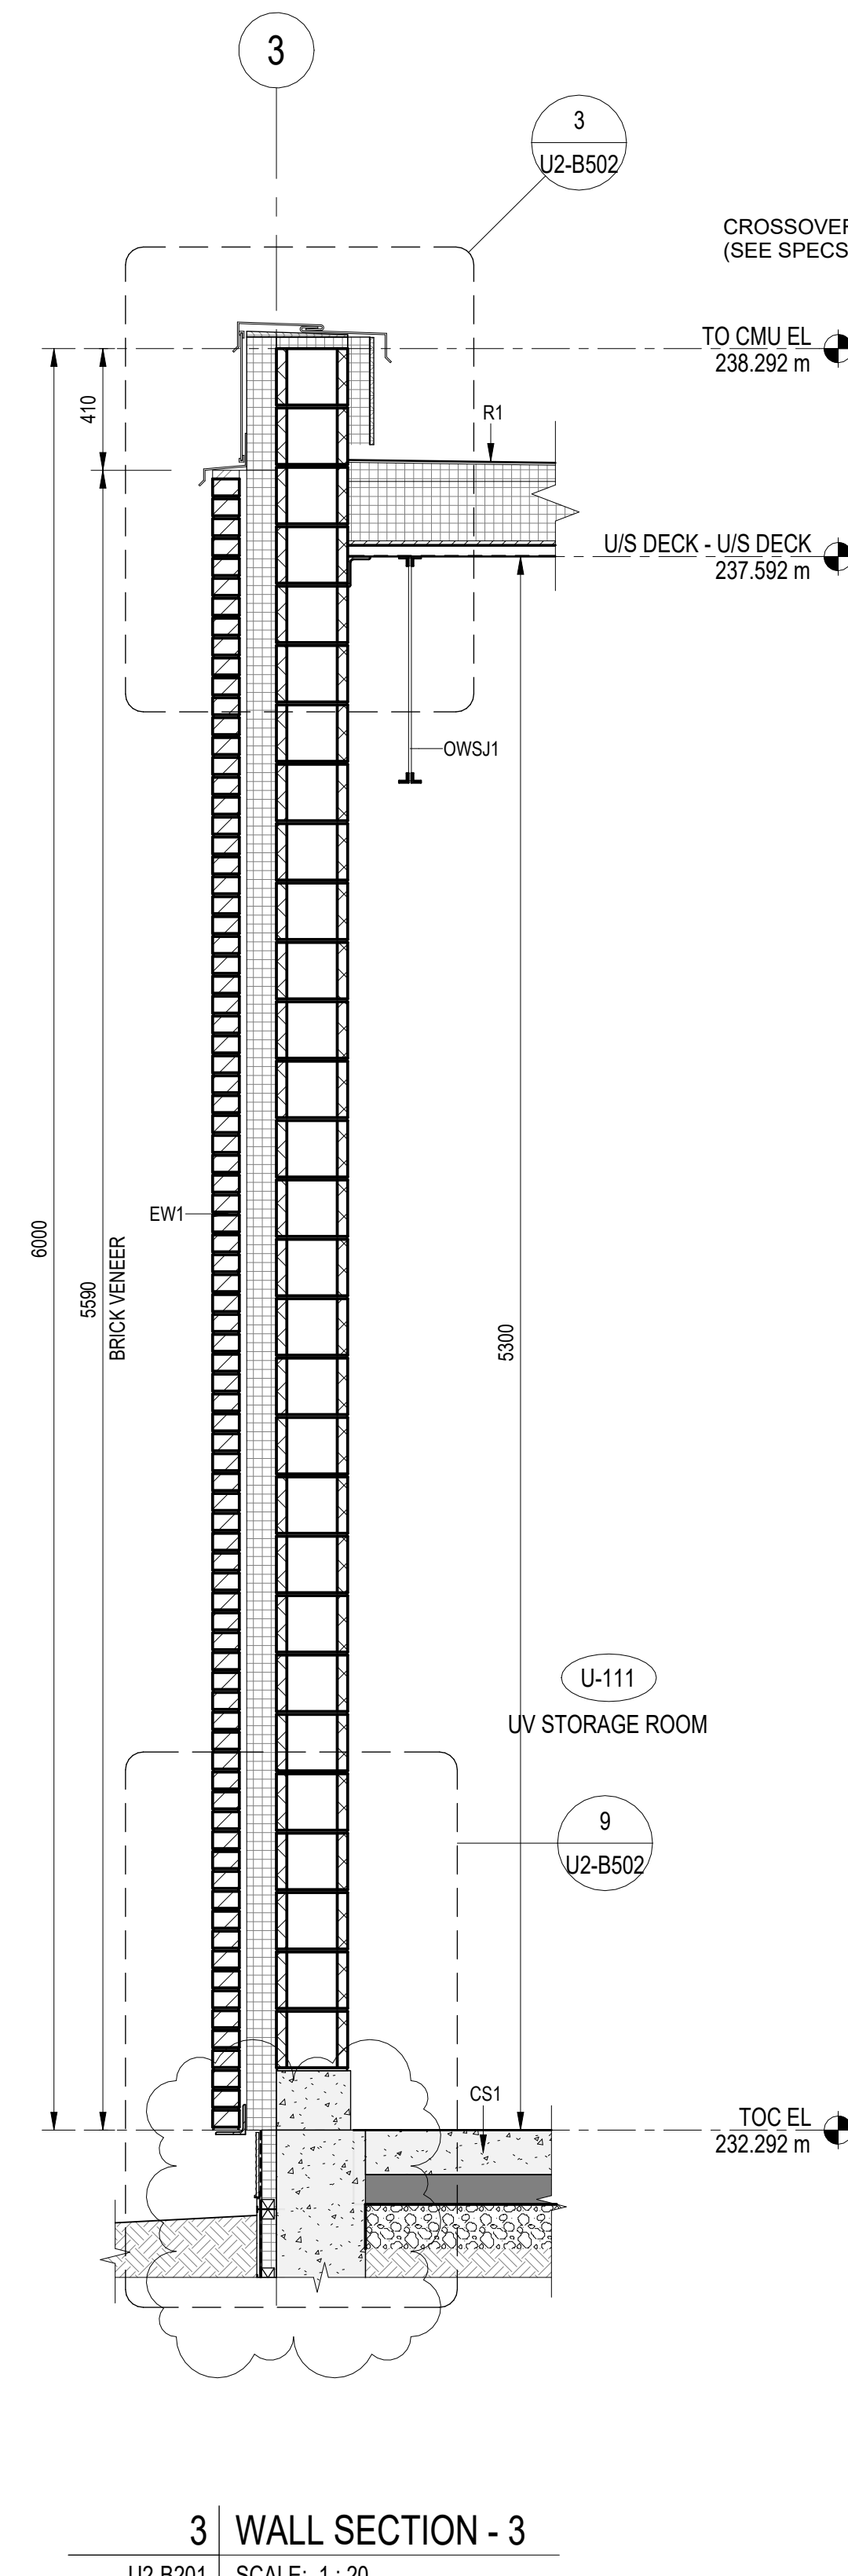

3 WALL SECTION - 3
U2-B201 SCALE: 1 : 20

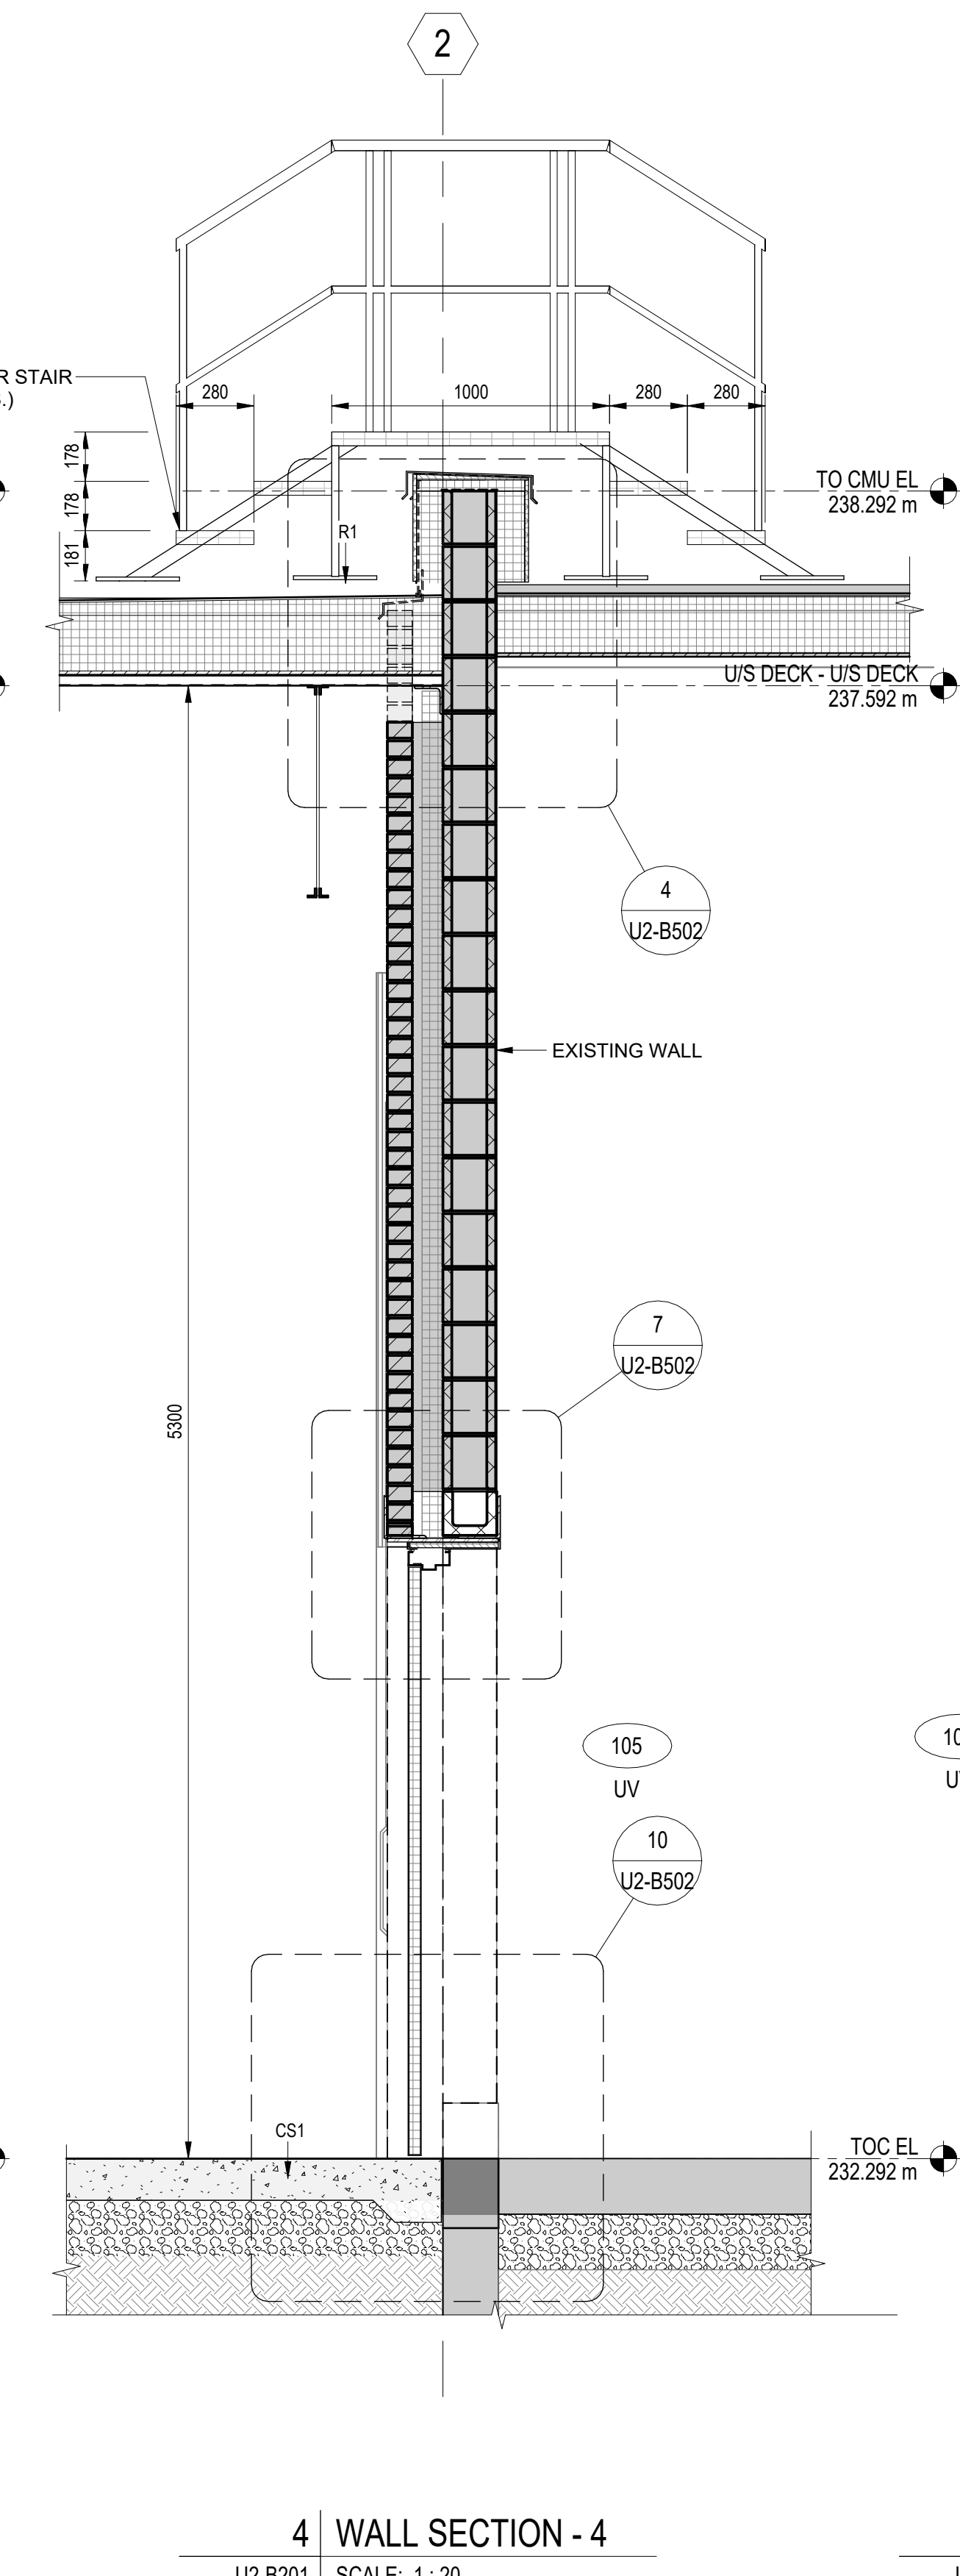


4 WALL SECTION - 4
U2-B201 SCALE: 1 : 20

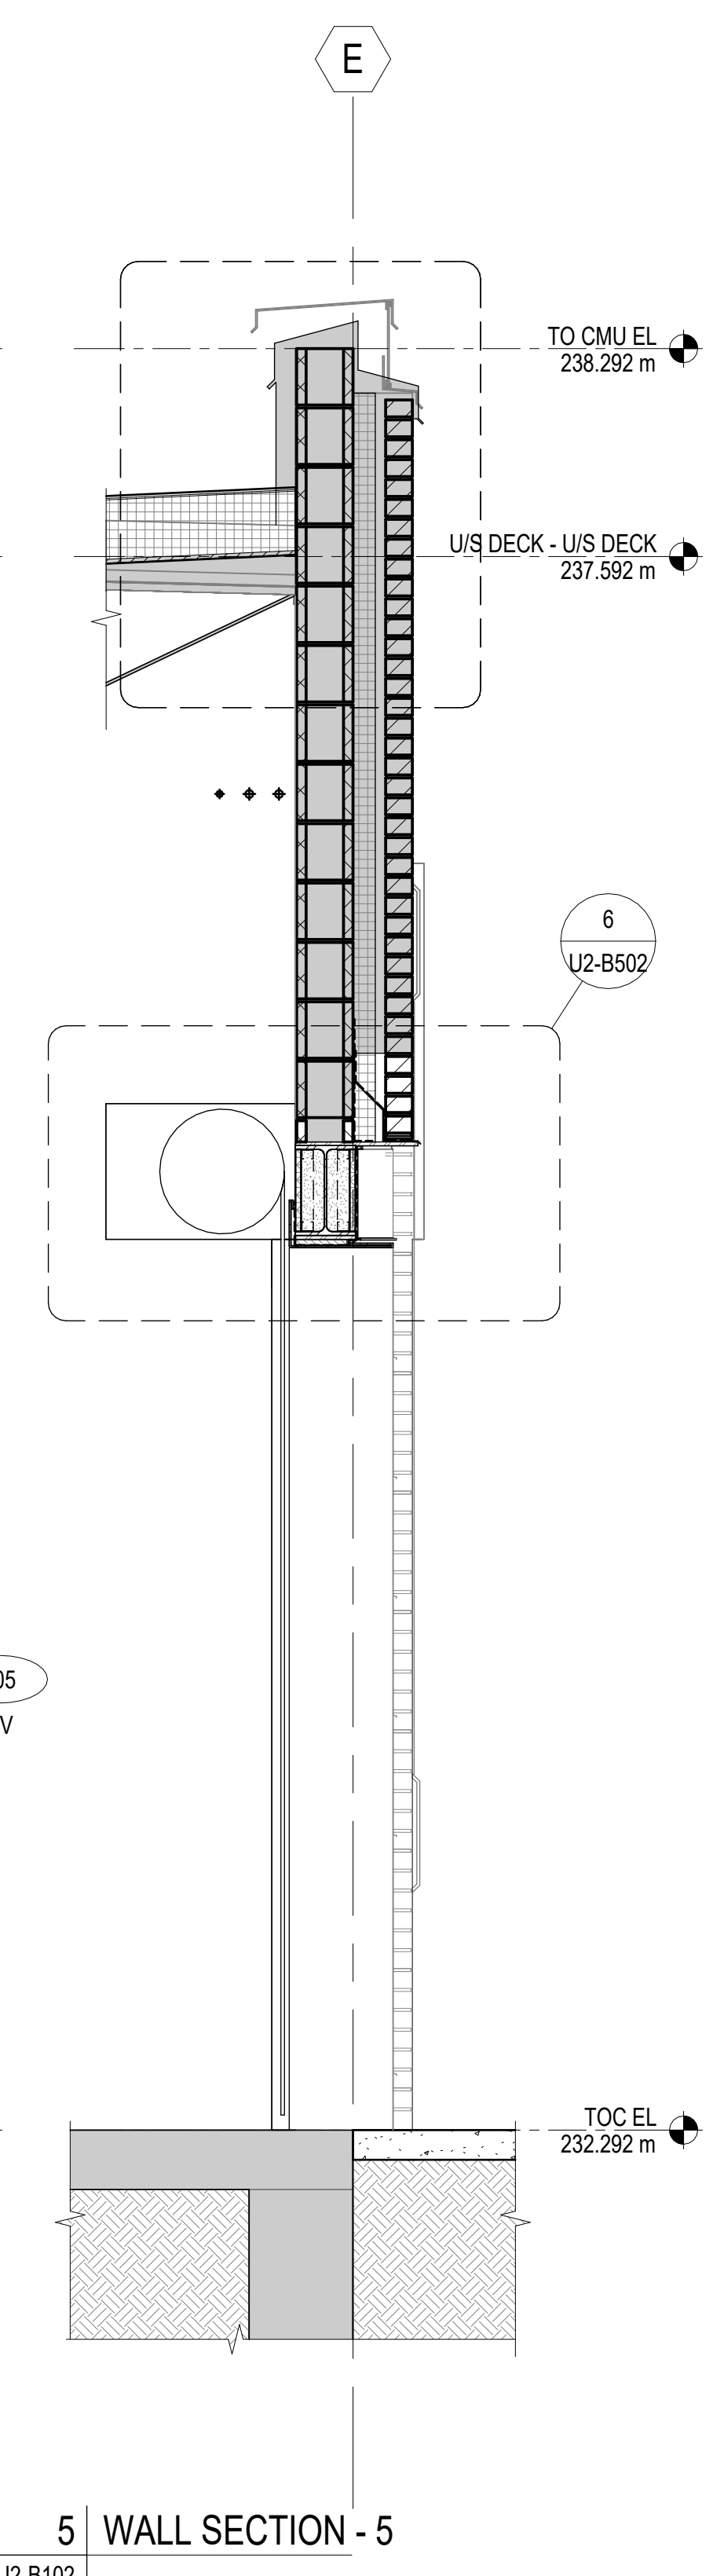

5 WALL SECTION - 5
U2-B102



				AECOM			
				DESIGNED BY:	AC/KS		
				CHECKED BY:	JC		
				DRAWN BY:	AC		
				APPROVED BY:	KS		
				SCALE:	As indicated		
				RELEASED FOR CONSTRUCTION BY:			
				DATE:	2025-02-26		
				DATE:			
				CONSULTANT NO.:	U2-B301		
01	ISSUED FOR ADDENDUM 7	2025-04-28	AC	JC			
00	ISSUED FOR TENDER	2025-02-26	AC	JC			
NO.	REVISIONS	DATE	DESIGN	CHECK			

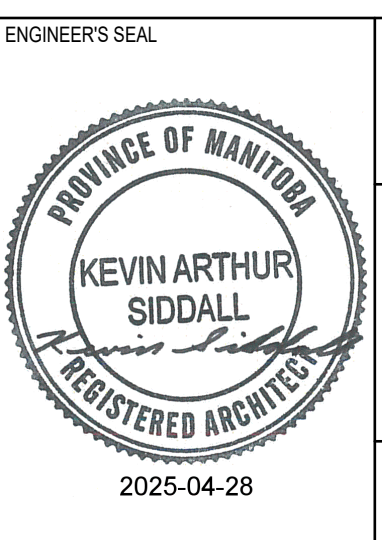

TENDER NO. 30-2025

THE CITY OF WINNIPEG
WATER AND WASTE DEPARTMENT

NORTH END SEWAGE TREATMENT PLANT
NEWPCC UV UPGRADES
ARCHITECTURAL
NEW UV STORAGE ROOM
WALL SECTIONS

CITY DRAWING NUMBER

SHEET

REV. 01

SIZE A1