


AI SIZE -- 594 x 841 mm

LAST SAVE: 2024/06/20 -- 12:49pm

PATH: R:\Projects\2023\23-0107-010\Wwg\Mech\1_Preliminary Design\1-0101B-A0010-001.dwg

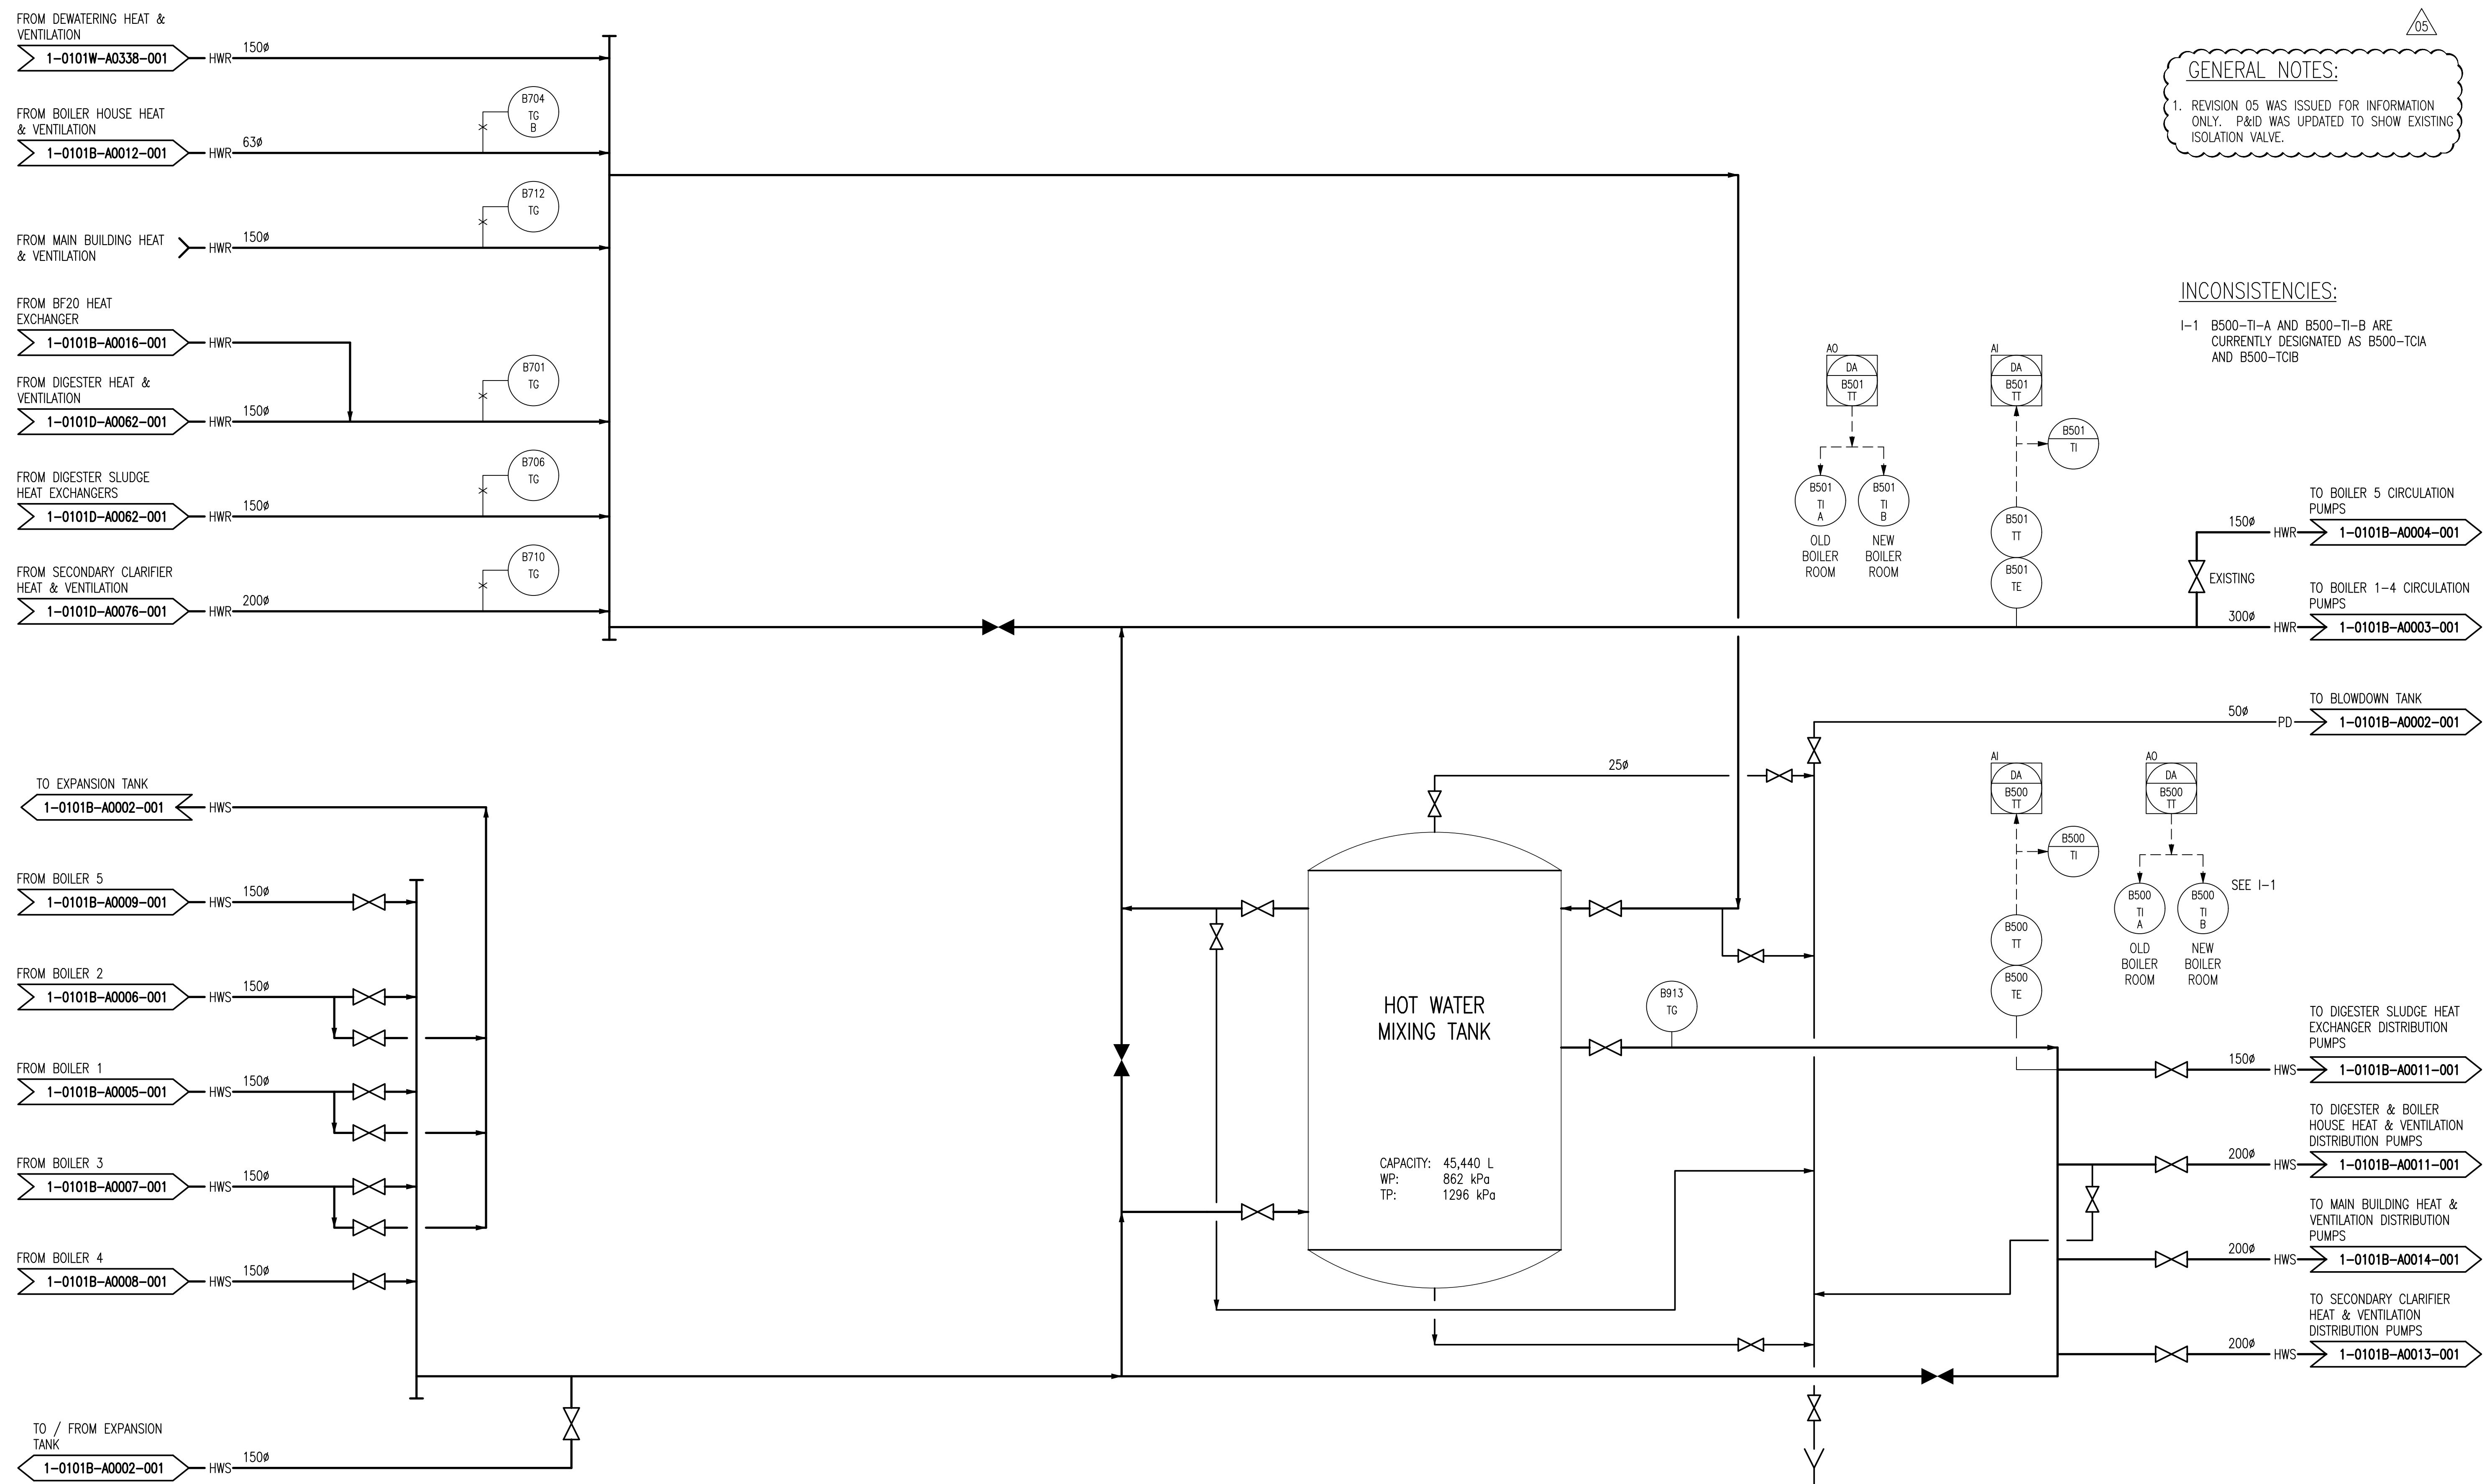

GENERAL NOTES:

1. REVISION 05 WAS ISSUED FOR INFORMATION ONLY. P&ID WAS UPDATED TO SHOW EXISTING ISOLATION VALVE.

INCONSISTENCIES:

I-1 B500-TI-A AND B500-TI-B ARE CURRENTLY DESIGNATED AS B500-TCIA AND B500-TCIB

ENGINEERS
GEOSCIENTISTS
MANITOBA

Certificate of Authorization
KGS Group
No. 245

05

BID OPPORTUNITY NO.: 792-2023
PROJECT COMPLETION DATE: 05 APRIL 2024
CONTRACTOR: RANDALL PLUMBING & HEATING LIMITED

B.M. ELEV.		FIELD BOOK #:		KGS GROUP		ENGINEER'S SEAL		 THE CITY OF WINNIPEG WATER AND WASTE DEPARTMENT				
POSTED TO LBIS												
05	ISSUED RECORD DRAWING - 792-2023	2024/06/20		DESIGNED BY JS	CHECKED BY AJF	NORTH END WATER POLLUTION CONTROL CENTRE BOILERS PROCESS & INSTRUMENTATION DIAGRAM HOT WATER MIXING TANK						
04	ISSUED FOR CONSTRUCTION - 792-2023	2023/10/05	JS	DRAWN BY RP	APPROVED BY JS							
03	ORIG # WAS 1-0101B-G-A0276-001-02D.dwg	2010/12/06	SPH	HOR. SCALE NTS	RELEASED FOR CONSTRUCTION							
02	RENUMBERED FACILITY CODE	2005/10/06	CJR	VERTICAL								
01	ISSUED FOR C.O.W. USE	2005/09/15	CJR	DATE. 2023/09/12	DATE							
00	RELEASED FOR CUSTOMER REVIEW	2005/08/22	CJR	FILENAME: 1-0101B-A0010-001.dwg		2024-06-20 REV. 05 CHANGES ONLY		CITY DRAWING NUMBER 1-0101B-A0010		SHEET 001	REV. 05	SIZE
NO. REVISIONS		DATE	BY									

1-0101A-A0001	PROCESS AND INSTRUMENT DIAGRAMS LEGEND AND DETAILS
DRAWING NUMBER	REFERENCE DRAWINGS