



PROPERTY & DEVELOPMENT SERVICES DEPARTMENT

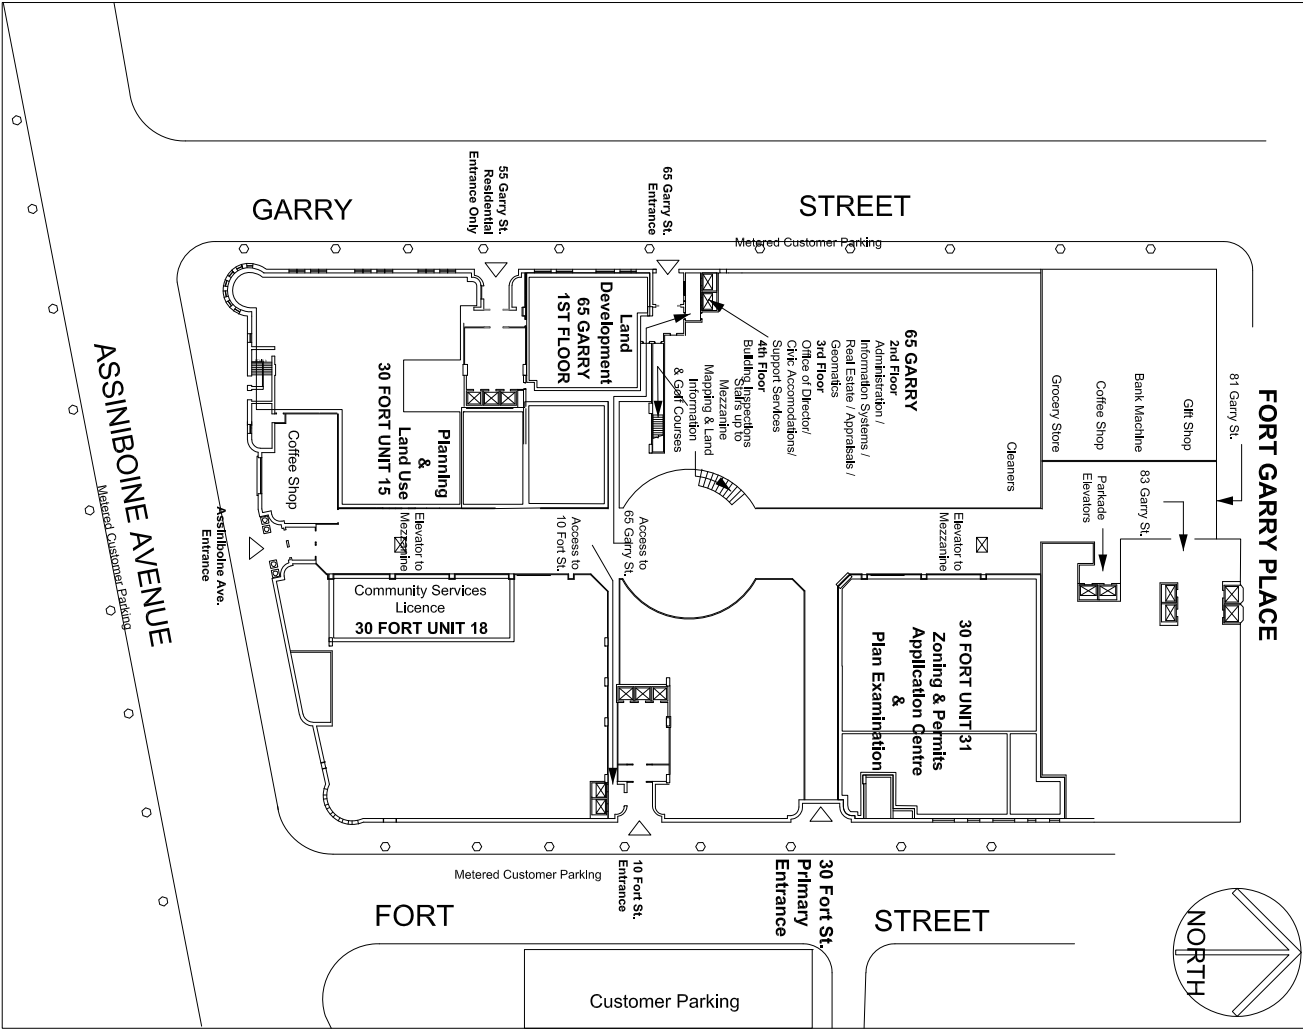

1 PP&D OVERALL MALL PLAN
1A1 NTS

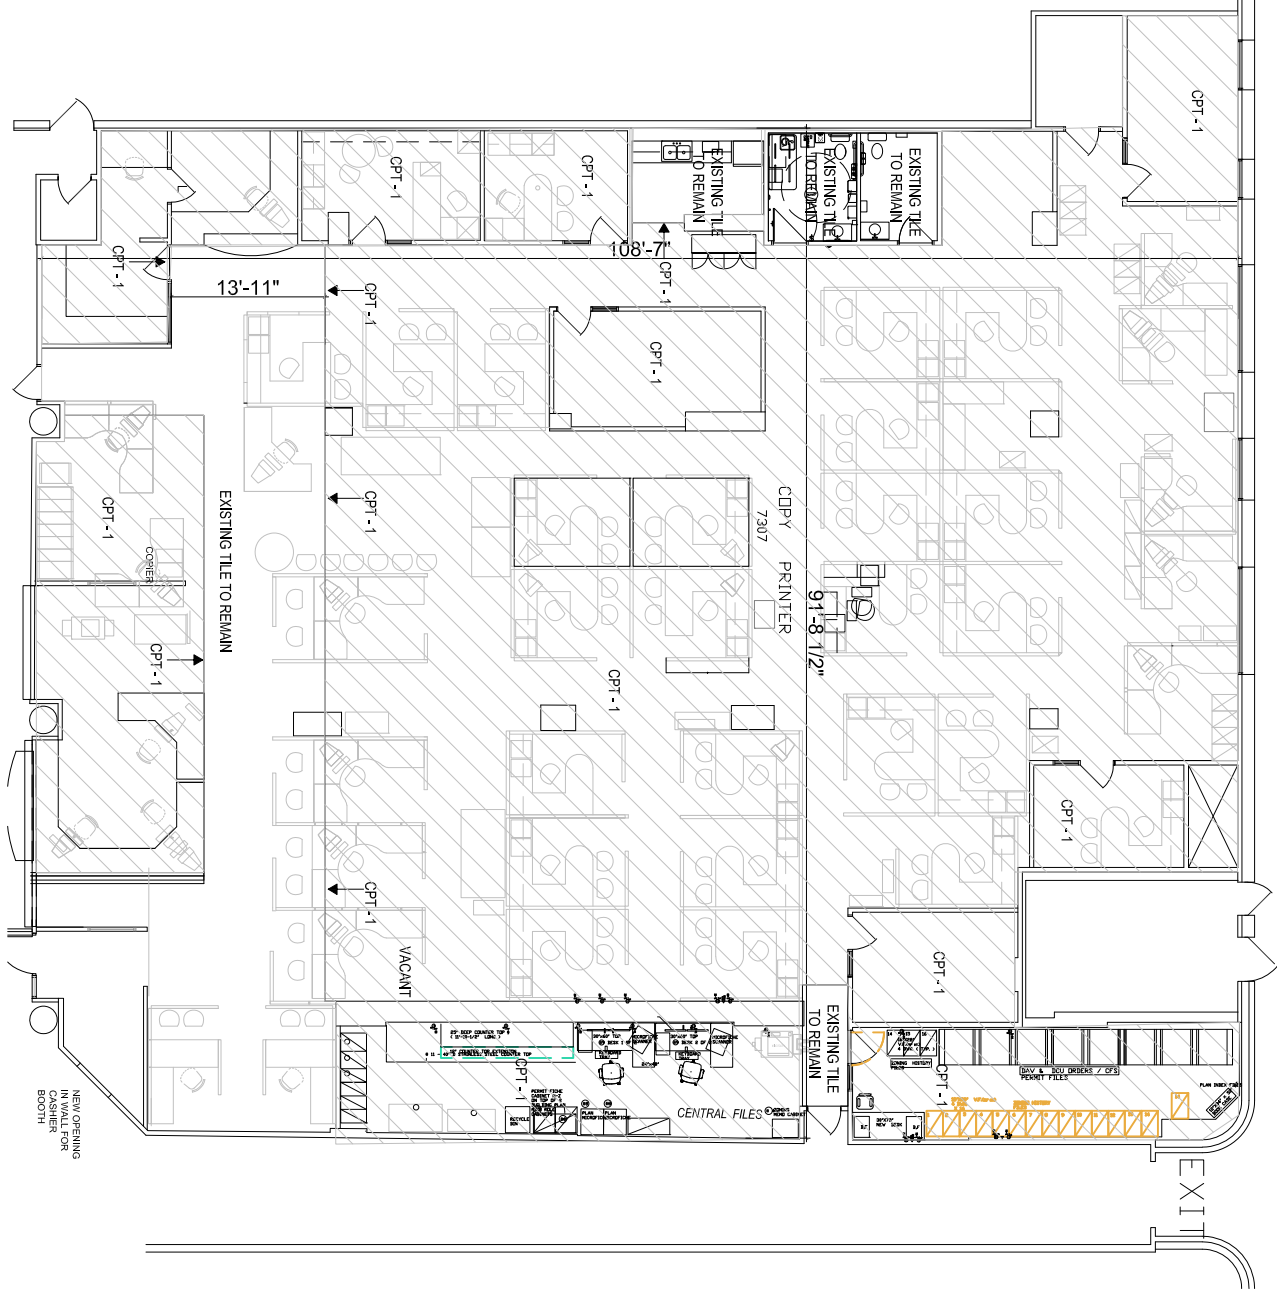

1 ZONING & PERMITS- OVERALL PLAN
1A1 SCALE: 1/8"=1'-0"

LEGEND	
CPT-1	MANUFACTURER: PATCRAFT COLLECTION: VISUAL ENERGY STYLE: WMD 1002 COLOUR: POWER 0092 INSTALLATION: LOW-VOC ADHESIVE, MONOLITHIC (EAST-WEST)
TS-1	MANUFACTURER: JOHNSONITE PRODUCT: SLIM LINE TRANSITIONS COLOUR: BURNT UMBER 63 INSTALLATION: LOW VOC ADHESIVE INSTALLER TO SELECT APPROPRIATE SIZE FOR TRANSITION BETWEEN ALL FLOORING CHANGES, BOTH NEW AND EXISTING
RB-1	MANUFACTURER: JOHNSONITE PRODUCT: 5" RUBBER BASE COLOUR: BURNT UMBER 63 INSTALLATION: LOW VOC ADHESIVE

GENERAL NOTES

1. THESE DRAWINGS SHALL NOT BE SCALED.
2. THE CONTRACTOR SHALL VISIT THE SITE AND VERIFY ALL MEASUREMENTS AND DETAILED INFORMATION SHOWN ARE CORRECT.
3. THE CONTRACTOR IS TO REVIEW AND COORDINATE ALL ARCHITECTURAL, MECHANICAL, ELECTRICAL, AND PLUMBING WORK WITH THE EXISTING BUILDING. ALL OPENINGS THROUGH FLOORS, WALLS, AND CEILINGS FOR DUCT, PIPE & ELECTRICAL RISERS AND ALL OPENINGS NOT SHOWN ON DRAWINGS, SHALL BE STOPPED AND SEALED WITH FIRE-RESISTANT MATERIAL TO MAINTAIN THE INTEGRITY OF THE FIRE SEPARATION. PROVIDE A SMOKE-TIGHT BARRIER.
4. ALL OPENINGS THROUGH FIRE ASSEMBLIES ARE TO BE STOPPED AND SEALED WITH FIRE-RESISTANT MATERIAL TO MAINTAIN THE INTEGRITY OF THE FIRE SEPARATION. PROVIDE A SMOKE-TIGHT BARRIER.
5. ALL PRODUCTS AND MATERIALS TO BE USED AND MANUFACTURERS SHALL CONFORM WITH MANUFACTURER'S SPECIFICATIONS & APPLICABLE CODES.
6. THE CONTRACTOR SHALL BE RESPONSIBLE TO PATCH AND MAKE GOOD ALL EXISTING CONSTRUCTION AFFECTED BY THE REMOVAL OF ALL ITEMS FORMING THE PART OF THE RENOVATION WORK.
7. WHERE NEW FLOORING AND BASE IS TO BE INSTALLED IN EXISTING AREAS (REFER TO FLOOR PLAN AND ROOM SCHEDULE) THE EXISTING FLOORING SURFACE AND BASE MUST BE REMOVED, UNLESS OTHERWISE NOTED. ALL FLOOR SURFACES SHALL BE PATCHED AND PREPARED TO ACCEPT NEW MATERIAL, UNLESS OTHERWISE NOTED.

No.	REVISION/DESCRIPTION	BY	DATE
2			
1			
0			

DATE	DESIGN	DRAWN	CHECKED	APPROVED
2024.10.07	BY: KUN	BY: NIT	BY: NIT	BY: NIT
THE CITY OF WINNIPEG ASSETS & PROJECT MANAGEMENT DEPARTMENT MUNICIPAL ACCOMMODATIONS DIVISION 3405 GARRY STREET, R1C 4K4				
PROJECT FORT GARRY PLACE PLANNING, PROPERTY & DEVELOPMENT				
31-30 FORT STREET				
SHEET TITLE ZONING AND PERMITS FLOORING FINISH PLAN				

SCALE	PROJECT NO.	SHEET NO.
AS SHOWN		A1