


- DETAIL NOTES:
1. ALL GROUNDING AND BONDING TO BE DONE WITH #6 BRAIDED COPPER CONDUCTOR.
 2. REFER TO SPECIFICATION FOR FURTHER GROUNDING DETAILS.


A MAIN GROUNDING LAYOUT

SCALE: N.T.S.

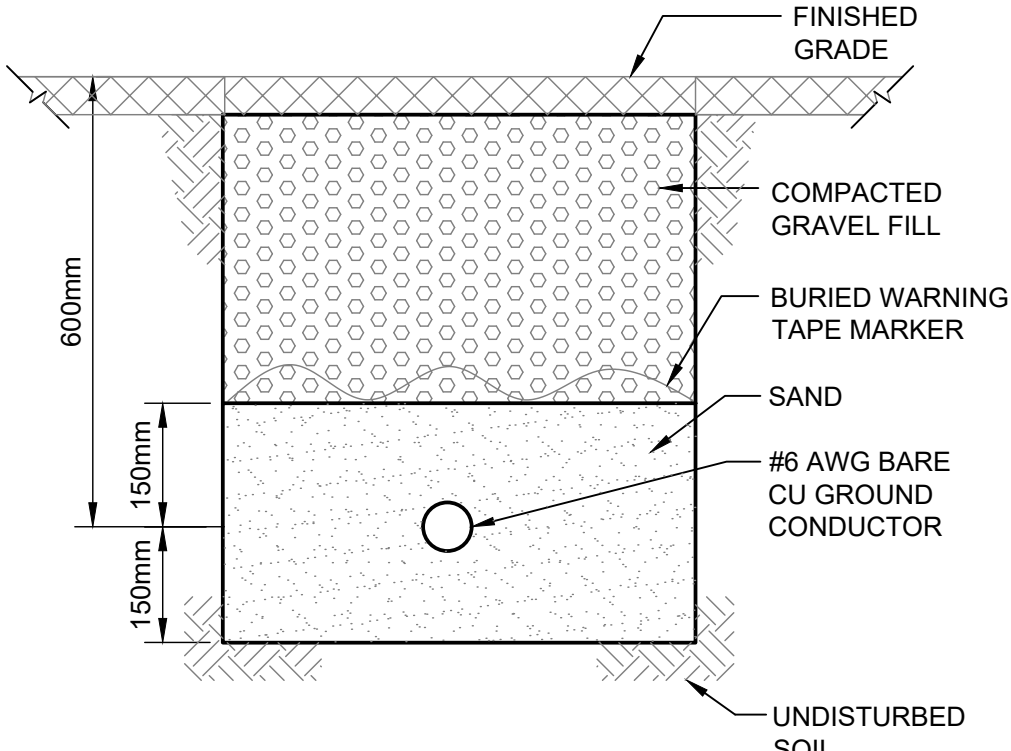


B GROUNDING TRENCH DETAIL

SCALE: N.T.S.

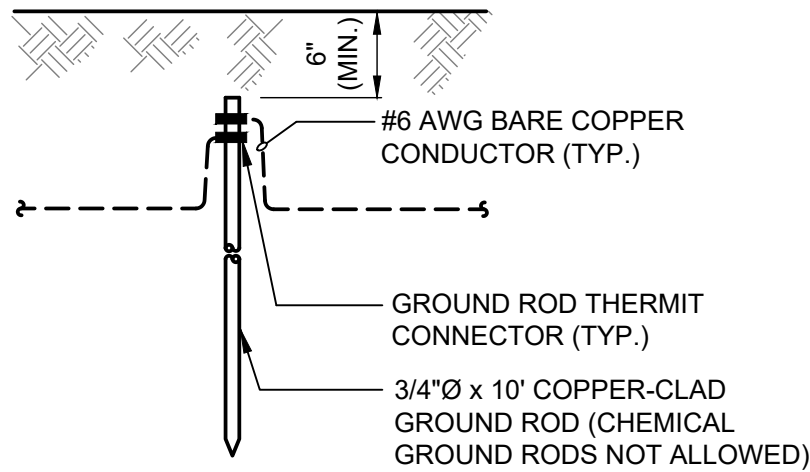

C GROUND ROD DETAIL

SCALE: N.T.S.

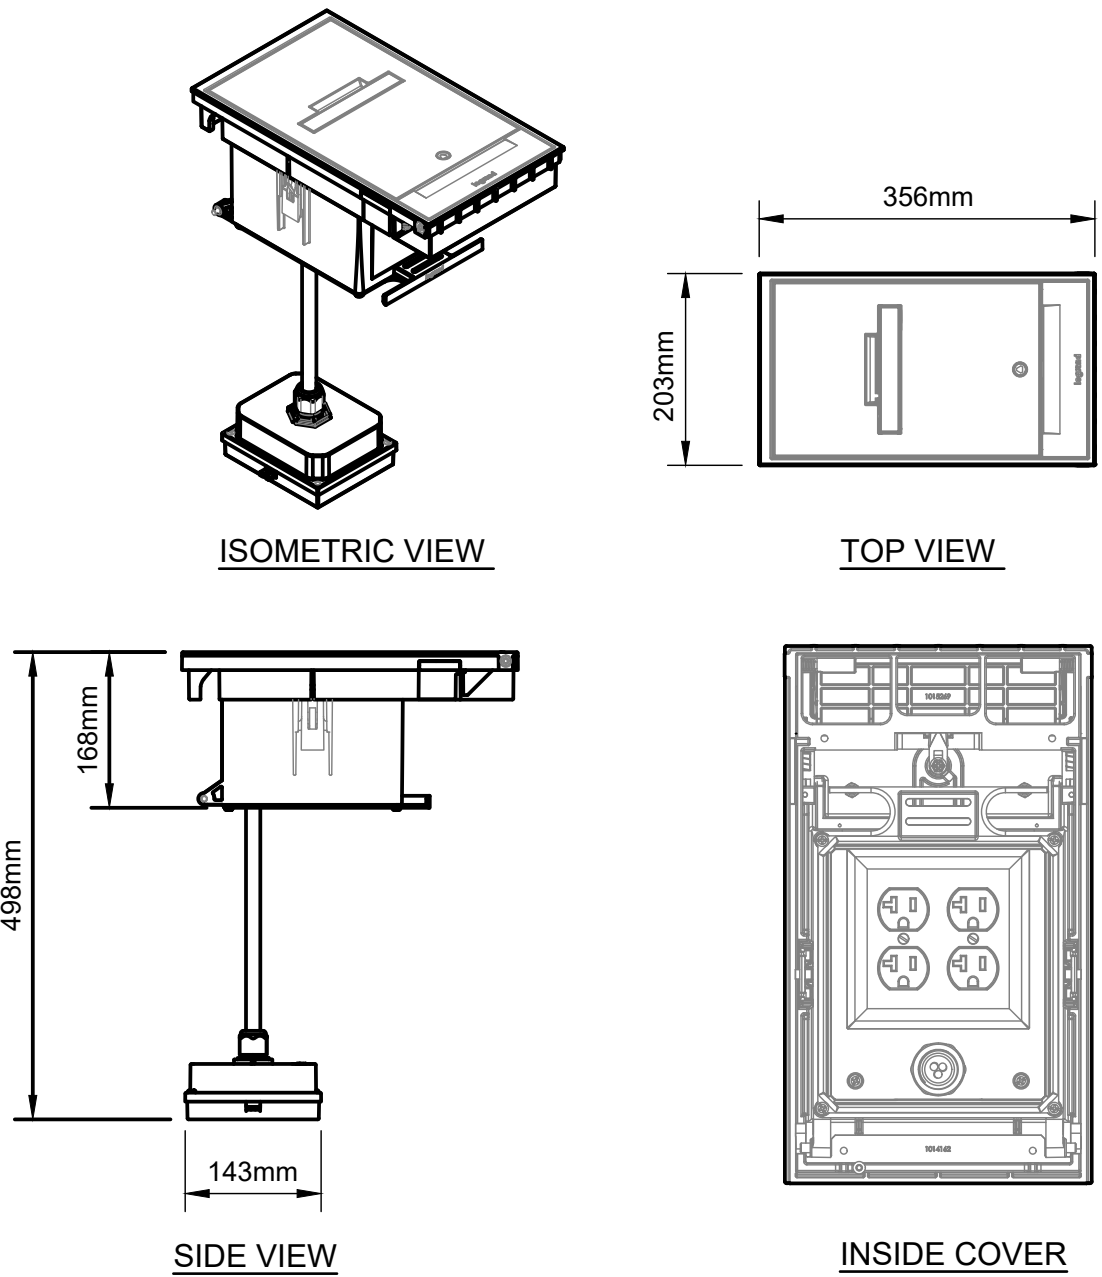

- DETAIL NOTES:
1. GROUND BOX SHALL CONSIST OF THE FOLLOWING:
 - COLOUR GRAY
 - TEXTURED SURFACE PLATE
 - HANDLE
 - NEMA 6P RATED WIRING ENCLOSURE
 - 2x 5-20A DUPLEX WEATHER RESISTANT RECEPTACLES
 - TAMPER - RESISTANT KEY AND LOCK
 2. ACCEPTABLE MANUFACTURER: LEGRAND
 3. REFER TO ARCHITECTURAL FOR INSTALLATION DETAIL.

D EXTERIOR GROUND BOX COVER ASSEMBLY DETAIL

SCALE: N.T.S.

NOTES:

1. -

KGS
GROUP

REV	YY / MM / DD	DESCRIPTION	BY
0	25/05/15	ISSUED FOR TENDER	PL

A. SECTION LETTER OR DETAIL NUMBER.
B. DRAWING WHERE SECTION OR DETAIL IS DRAWN.

OR

DRAWING WHERE SECTION OR DETAIL IS INDICATED.
--- SECTION OR DETAIL SHOWN ON SAME DRAWING.

A

B

A

PROFESSIONAL'S SEAL

PROVINCE OF MANITOBA

LAPORTE


Licence No. 41812

2025-05-16

REGISTERED ENGINEERING LICENSEE

SCATLIFF + MILLER + MURRAY

visionary urban design + landscapes

CONSULTANT FILE NAME ODEON PARK UDAC			
CLIENT CITY OF WINNIPEG PLANNING, PROPERTY & DEVELOPMENT			
 AIR CANADA WINDOW PARK REDEVELOPMENT			
CITY DRAWING NUMBER	SHEET	OF	
	3	6	
ELECTRICAL SITE DETAILS			
DESIGN	DRAWN	DATE - Y / M / D	SCALE
CB	JDP/RD	25/05/15	N.T.S.
CHECKED	APPROVED	PROJECT No.	DRAWING No.
PL	PL	24-0107-012	E1.1

