
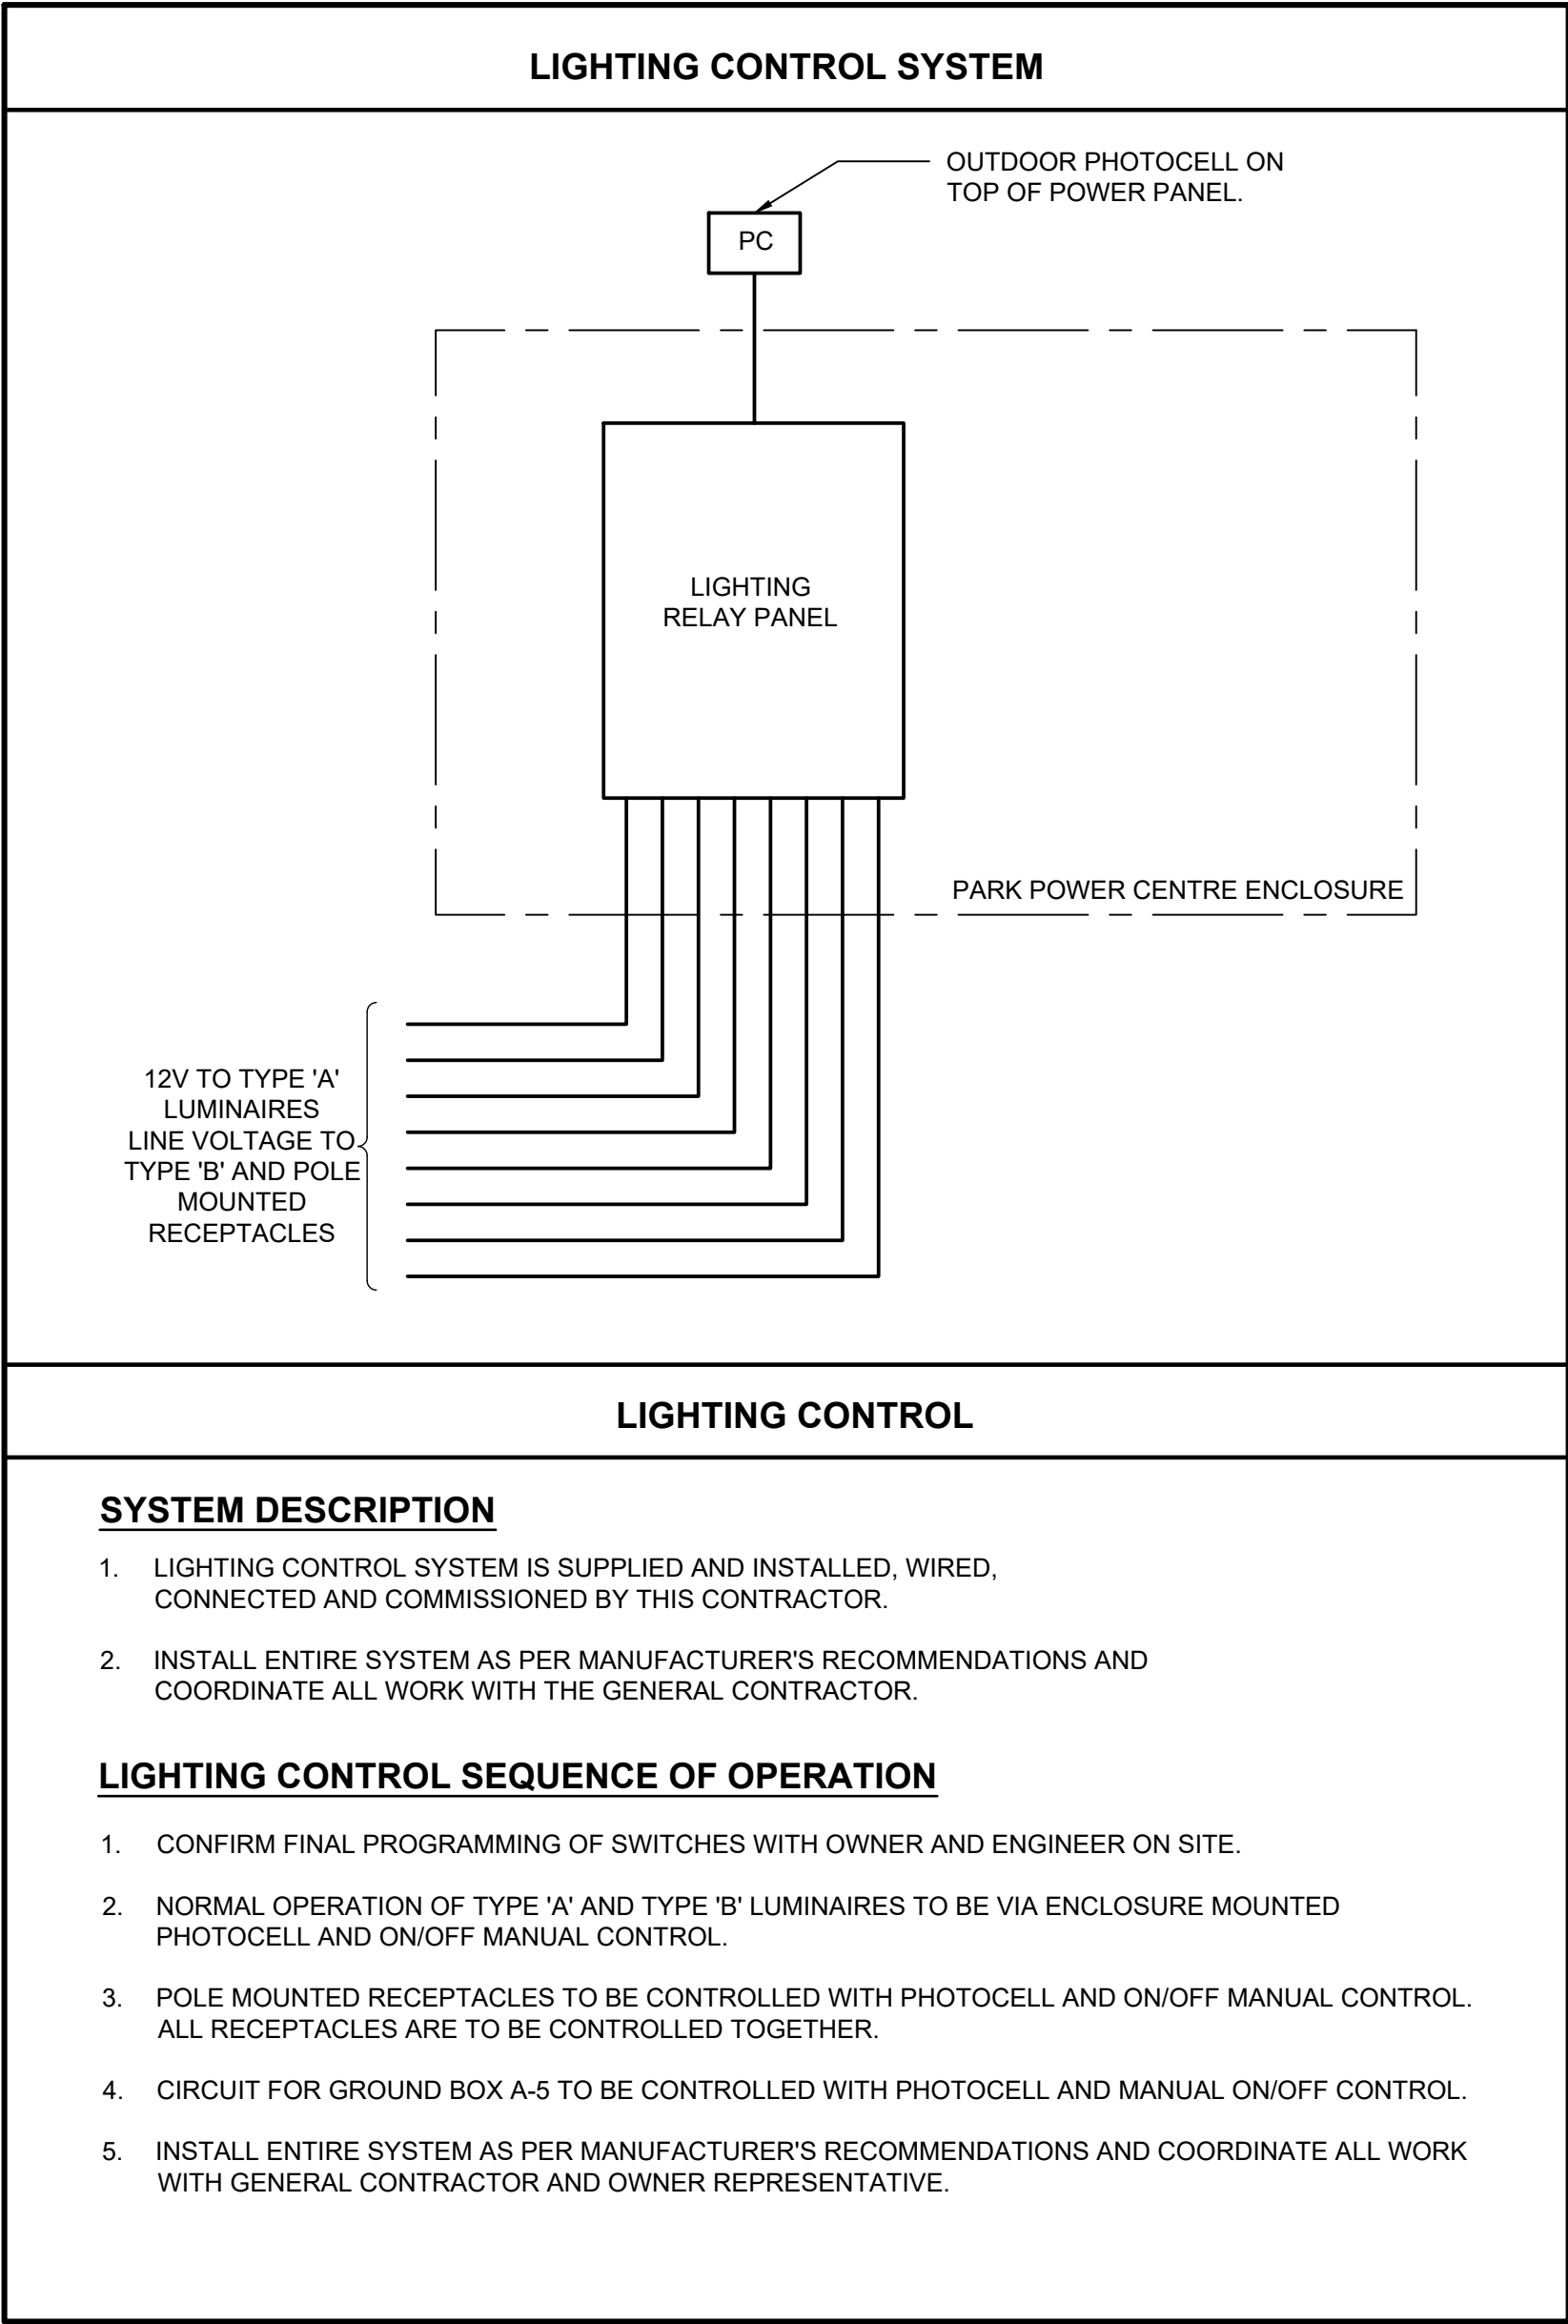
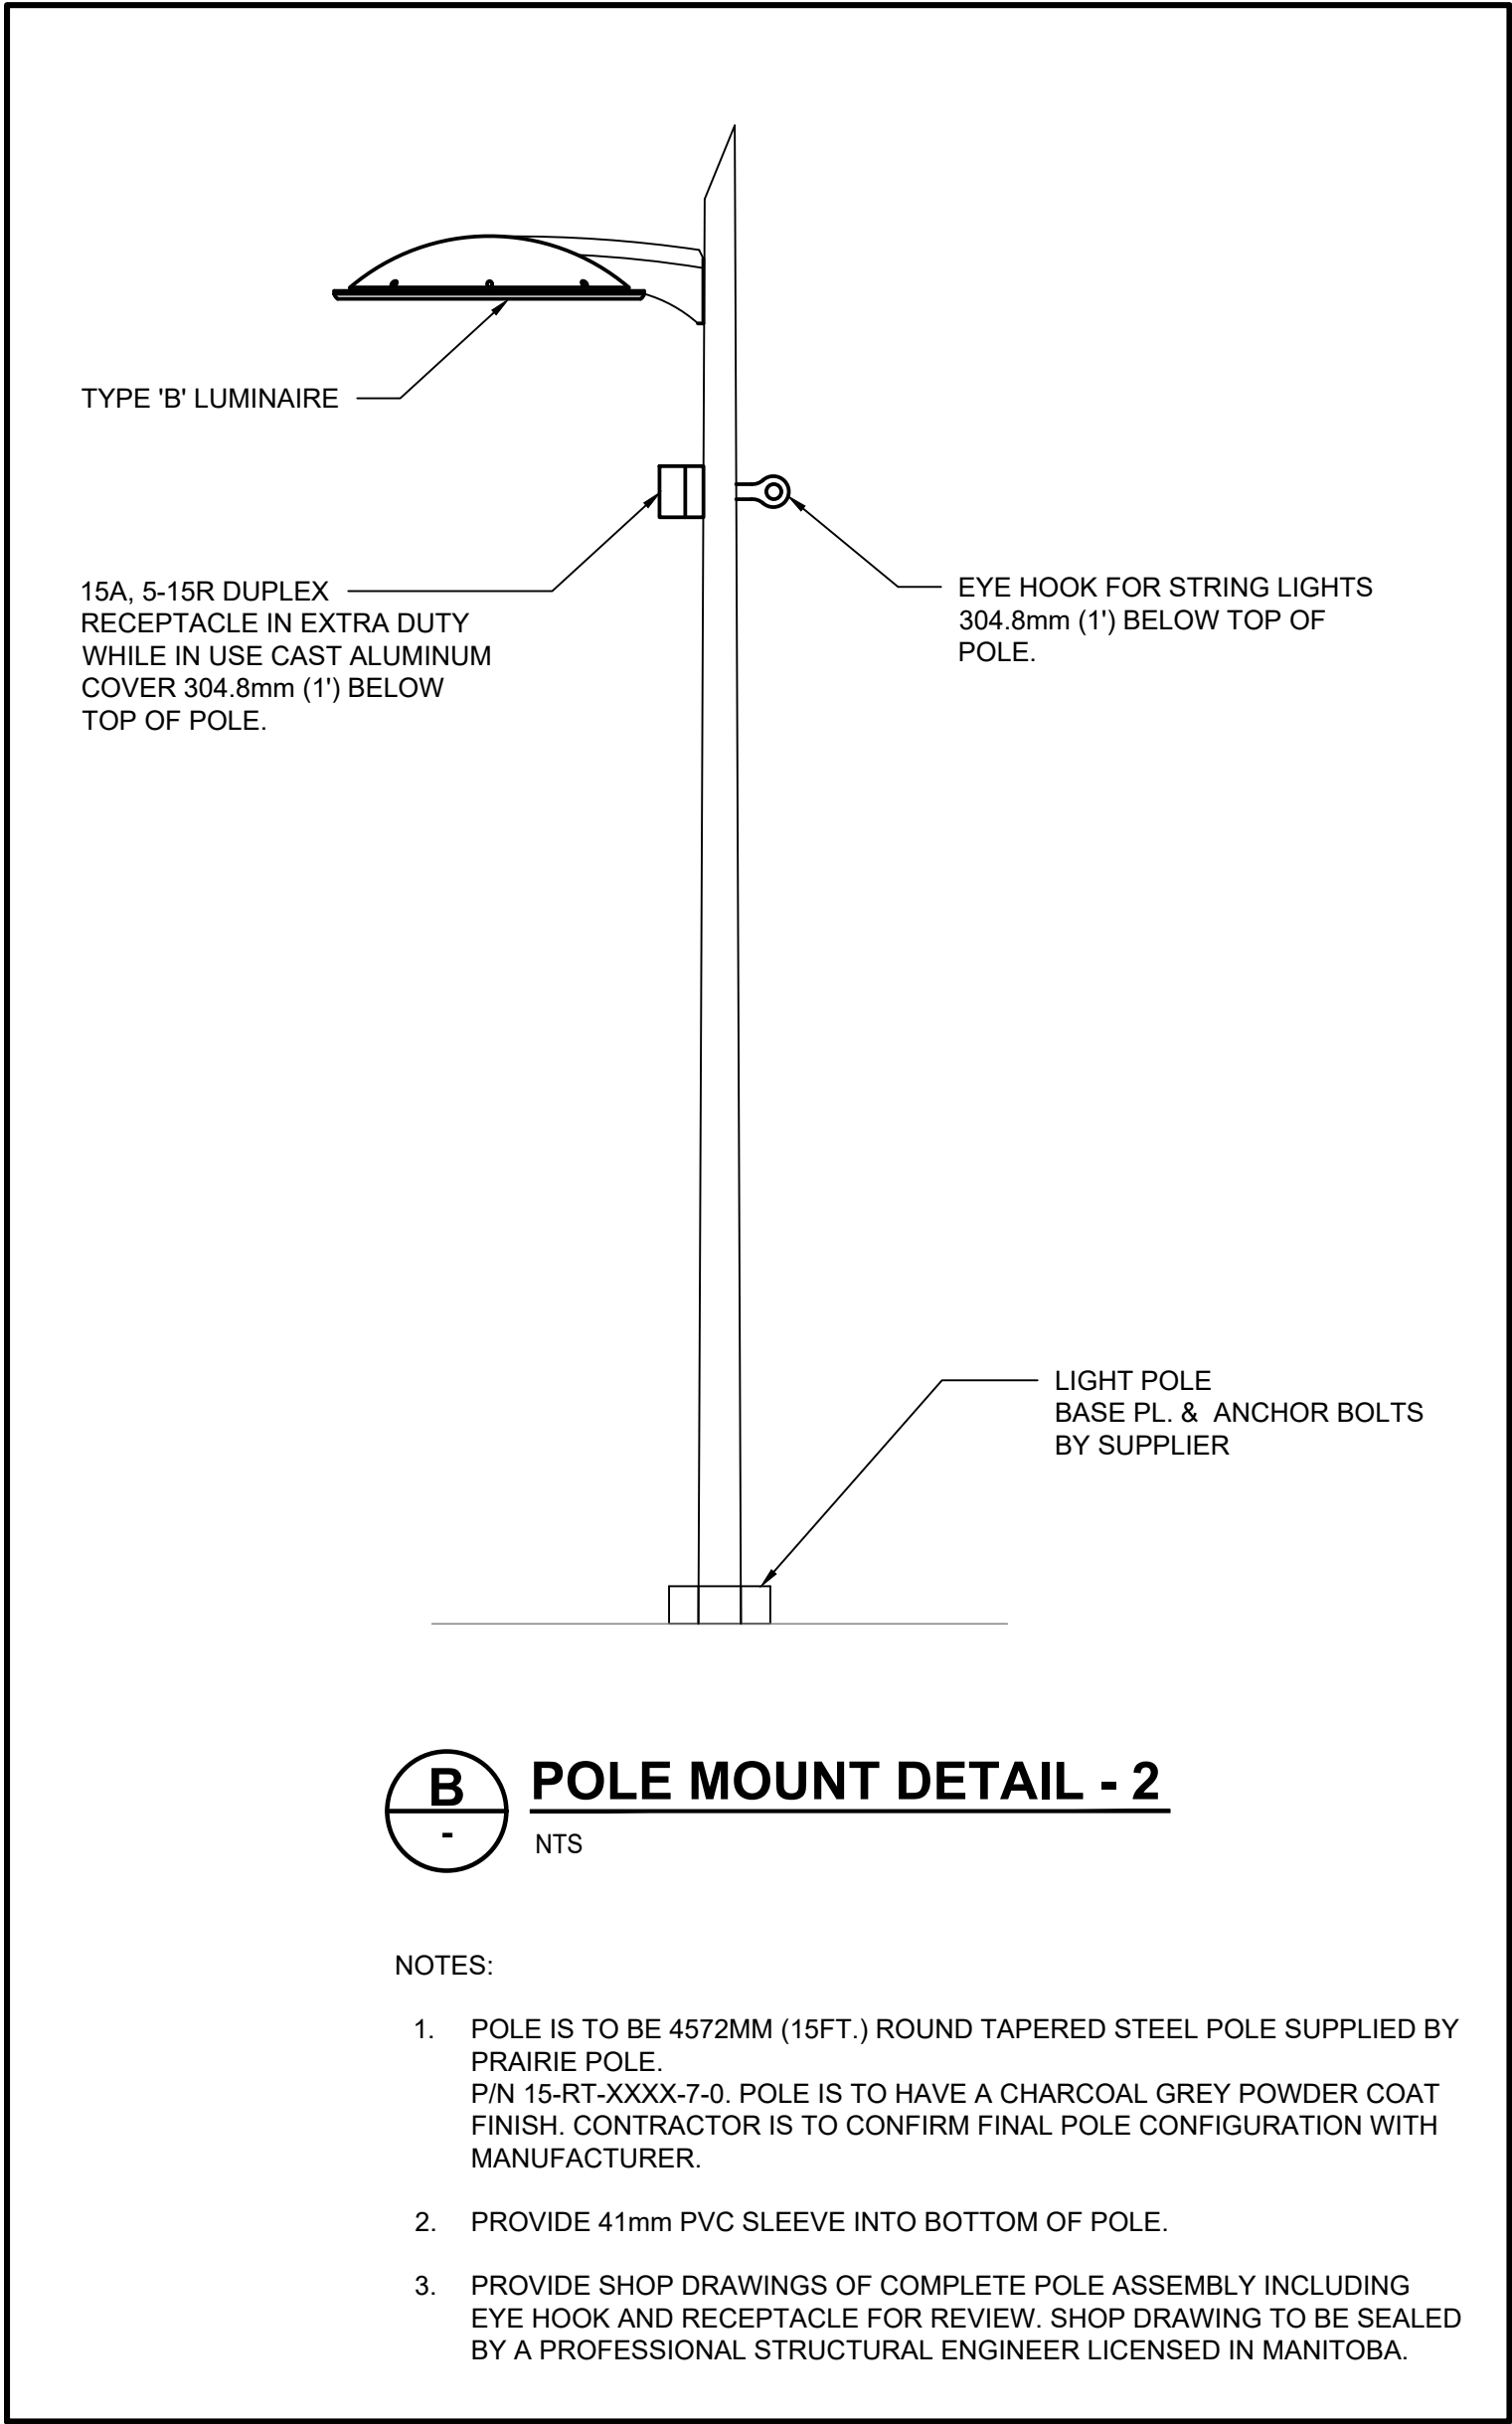


LUMINAIRE SCHEDULE													
TYPE	MANUFACTURER	PART/MODEL #	MOUNTING			LAMPS			POWER		NOTES		
			CEILING	WALL	RECESSED SURFACE	SUSPENDED	QTY PER LUMINAIRE	TYPE	COLOR TEMP (°K)	LUMENS (LM)		VOLTAGE (V)	WATTS PER LUMINAIRE (W)
A	TIVOLI LIGHTING	LSL2-K-24-S-30-C-12	-	-	-	-	1	LED	3000K	1053	120V	14W	REFER TO NOTE#4.
B	COOPER LIGHTING	TT-D1-830-U-T4-PM	-	-	-	-	1	LED	3000K	4000	120V	29W	-
NOTES:													
1. CONFIRM ALL LUMINAIRE FINISHES WITH THE LANDSCAPE ARCHITECT PRIOR TO ORDERING.													
2. PROVIDE ALL ACCESSORIES INCLUDING TRIM RINGS, STEMS, CANOPIES, CORDS, MOUNTING HARDWARE, RESTRAINTS, ETC., NECESSARY TO MOUNT THE LUMINAIRE IN A COMPLETE AND APPROVED METHOD.													
3. POLE FOR TYPE 'B' LUMINAIRES ARE TO BE 4572MM (15FT) TALL POLES.													
4. PROVIDE 120/12V TRANSFORMER FOR FESTOON LIGHTING, PART NUMBER ADN-150-2-5-12-D. MOUNT TRANSFORMER WITHIN LIGHTING CONTROL SECTION OF DISTRIBUTION ENCLOSURE. FESTOON LIGHTING IS TO BE SPLIT INTO TWO RUNS.													

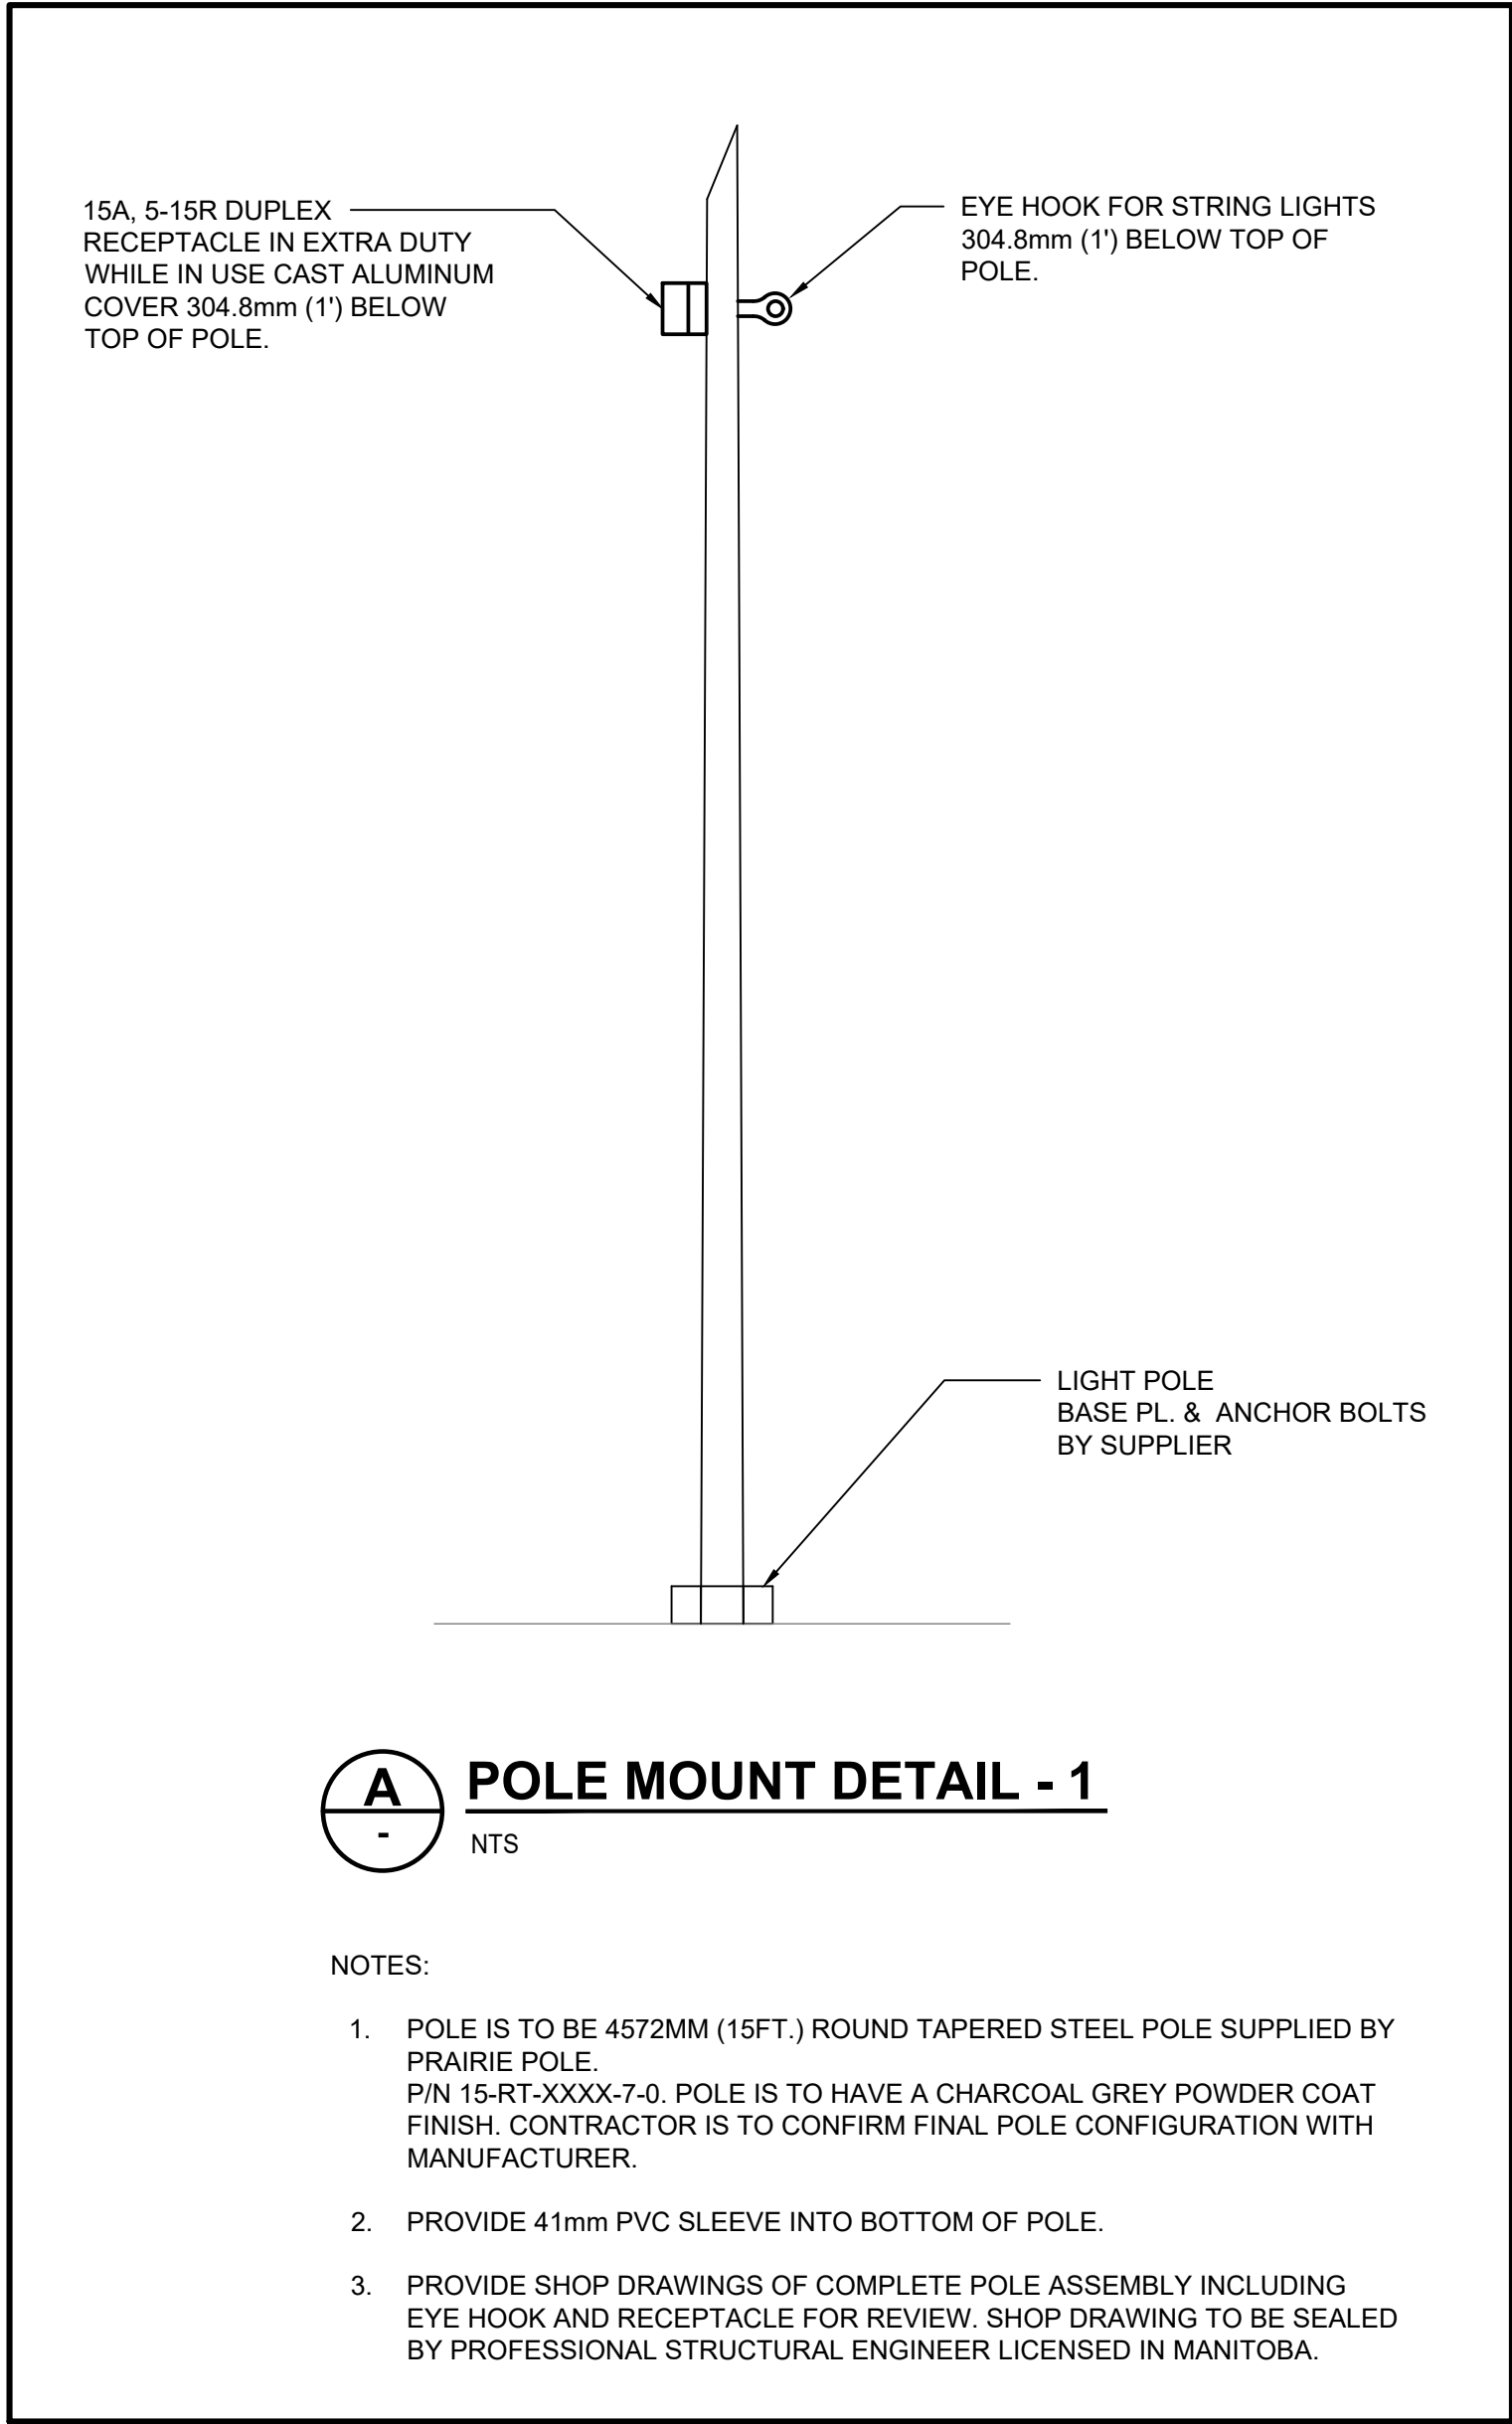


NOTES:

1. -

[illegible]

0	25/05/15	ISSUED FOR TENDER	PL
REV	YY / MM / DD	DESCRIPTION	BY

 A. SECTION LETTER OR DETAIL NUMBER,
B. DRAWING WHERE SECTION OR DETAIL IS DRAWN,
OR
DRAWING WHERE SECTION OR DETAIL IS INDICATED,
--- SECTION OR DETAIL SHOWN ON SAME DRAWING.



SCATLIFF + MILLER + MURRAY
visionary urban design + landscapes

CONSULTANT FILE NAME ODEON PARK UDAC

CLIENT

CITY OF WINNIPEG

PLANNING, PROPERTY & DEVELOPMENT



AIR CANADA WINDOW PARK REDEVELOPMENT

CITY DRAWING NUMBER	SHEET	OF
	4	6

ELECTRICAL
LUMINAIRE SCHEDULE, LIGHTING CONTROL & DETAIL

DESIGN	DRAWN	DATE - Y / M / D	SCALE
CB	JDP/RD	25/05/15	AS SHOWN
CHECKED	APPROVED	PROJECT No.	DRAWING No.
PL	PL	24-0107-012	E2.0

